


F.A.I. RTE.	SECTION	COUNTY	TOTAL SHEETS	SHEET NO.
74	*	TAZEWELL	1366	288
STA. 3+500.000 TO STA. 3+650.000				
FED. ROAD DIST. NO. 4			ILLINOIS FED. AID PROJECT	
* (90-11)R-2;90(13,14,14-1)R-1				


### DISPOSITION OF EXISTING DRAINAGE FEATURES

- [A] STRUCTURE TO BE ADJUSTED WITH NEW FRAME AND GRATE
- (A) STRUCTURE TO BE ADJUSTED WITH NEW FRAME AND LID
- [ADJ] STRUCTURE TO BE ADJUSTED
- [C] STRUCTURE TO BE CLEANED
- [F] STRUCTURE TO BE FILLED
- [REC] STRUCTURE TO BE RECONSTRUCTED WITH NEW FRAME AND LID
- [R] STRUCTURE TO BE REMOVED
- [AB] ITEM TO BE ABANDONED
- [REL] ITEM TO BE RELOCATED
- [SSR] STORM SEWER REMOVAL
- [SSC] STORM SEWER TO BE CLEANED

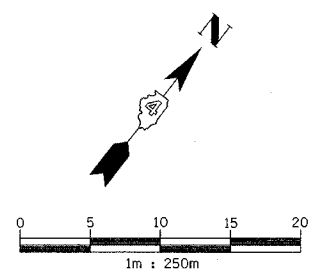

### EXISTING DRAINAGE AND UTILITY LEGEND

- A — OVERHEAD ELECTRIC
- S — STORM SEWER
- SS — SANITARY SEWER
- C — CULVERT PIPE
- T — TRENCH DRAIN
- T — UNDERGROUND TELEPHONE
- FC — UNDERGROUND FIBER OPTIC
- D — UNDERGROUND COMMUNICATIONS DUCT
- WM — UNDERGROUND WATER MAIN
- GM — UNDERGROUND GAS MAIN
- H — HEADWALL
- I — INLET
- C — CONC END SECTION
- U — UTILITY MANHOLE
- E — ELECTRIC/TELEPHONE SPLICE BOX
- T — TRAFFIC SIGNAL HANDHOLE
- P — POWER POLE
- T — TELEPHONE POLE
- H — HIGH MAST LIGHT
- T — ABOVE GROUND TRANSFORMER
- V — WATER VALVE OR UTIL. BOX
- F — FIRE HYDRANT
- S — RAILROAD SWITCH
- S — RAILROAD SIGNAL
- J — FIBER OPTIC JUNCTION BOX

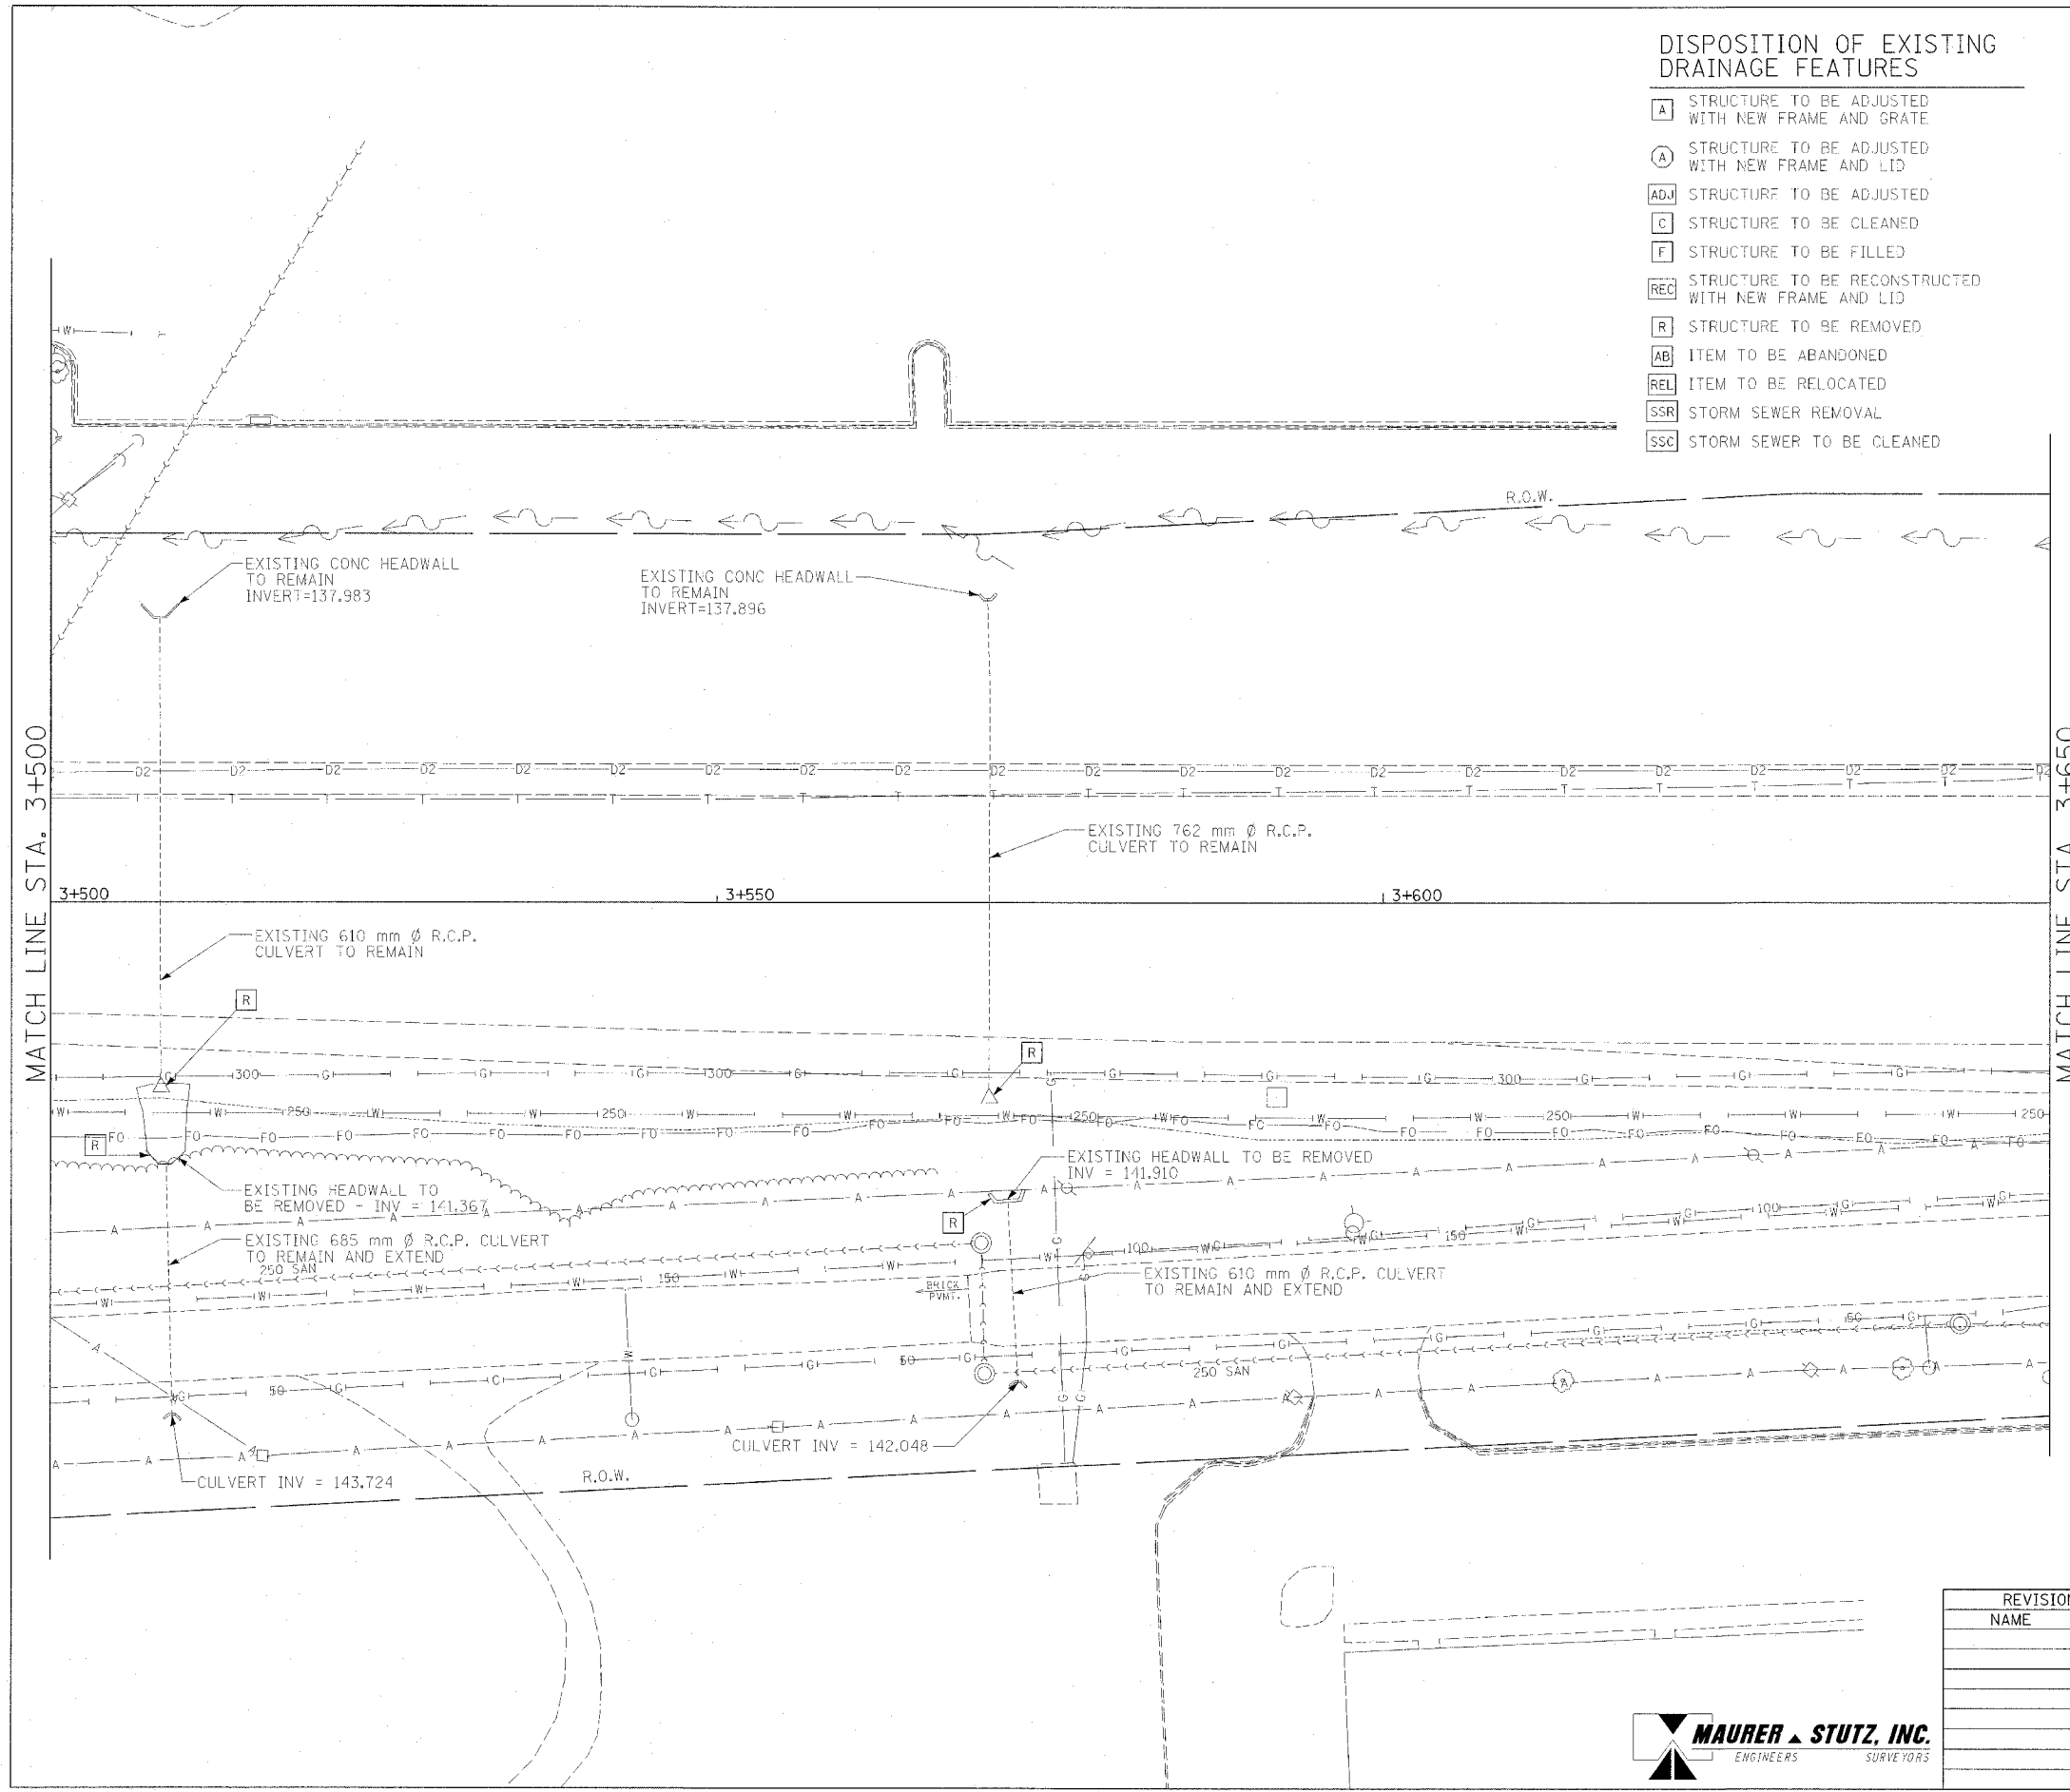

MATCH LINE STA. 3+650

MATCH LINE STA. 3+500

### EXISTING CONDITIONS

REVISIONS	
NAME	DATE

ILLINOIS DEPARTMENT OF TRANSPORTATION  
**DRAINAGE AND UTILITY PLAN**  
**MAIN STREET**  
 STA 3+500 to 3+650

DATE 12/20/04

DRAWN BY JAM  
 CHECKED BY MJS

