
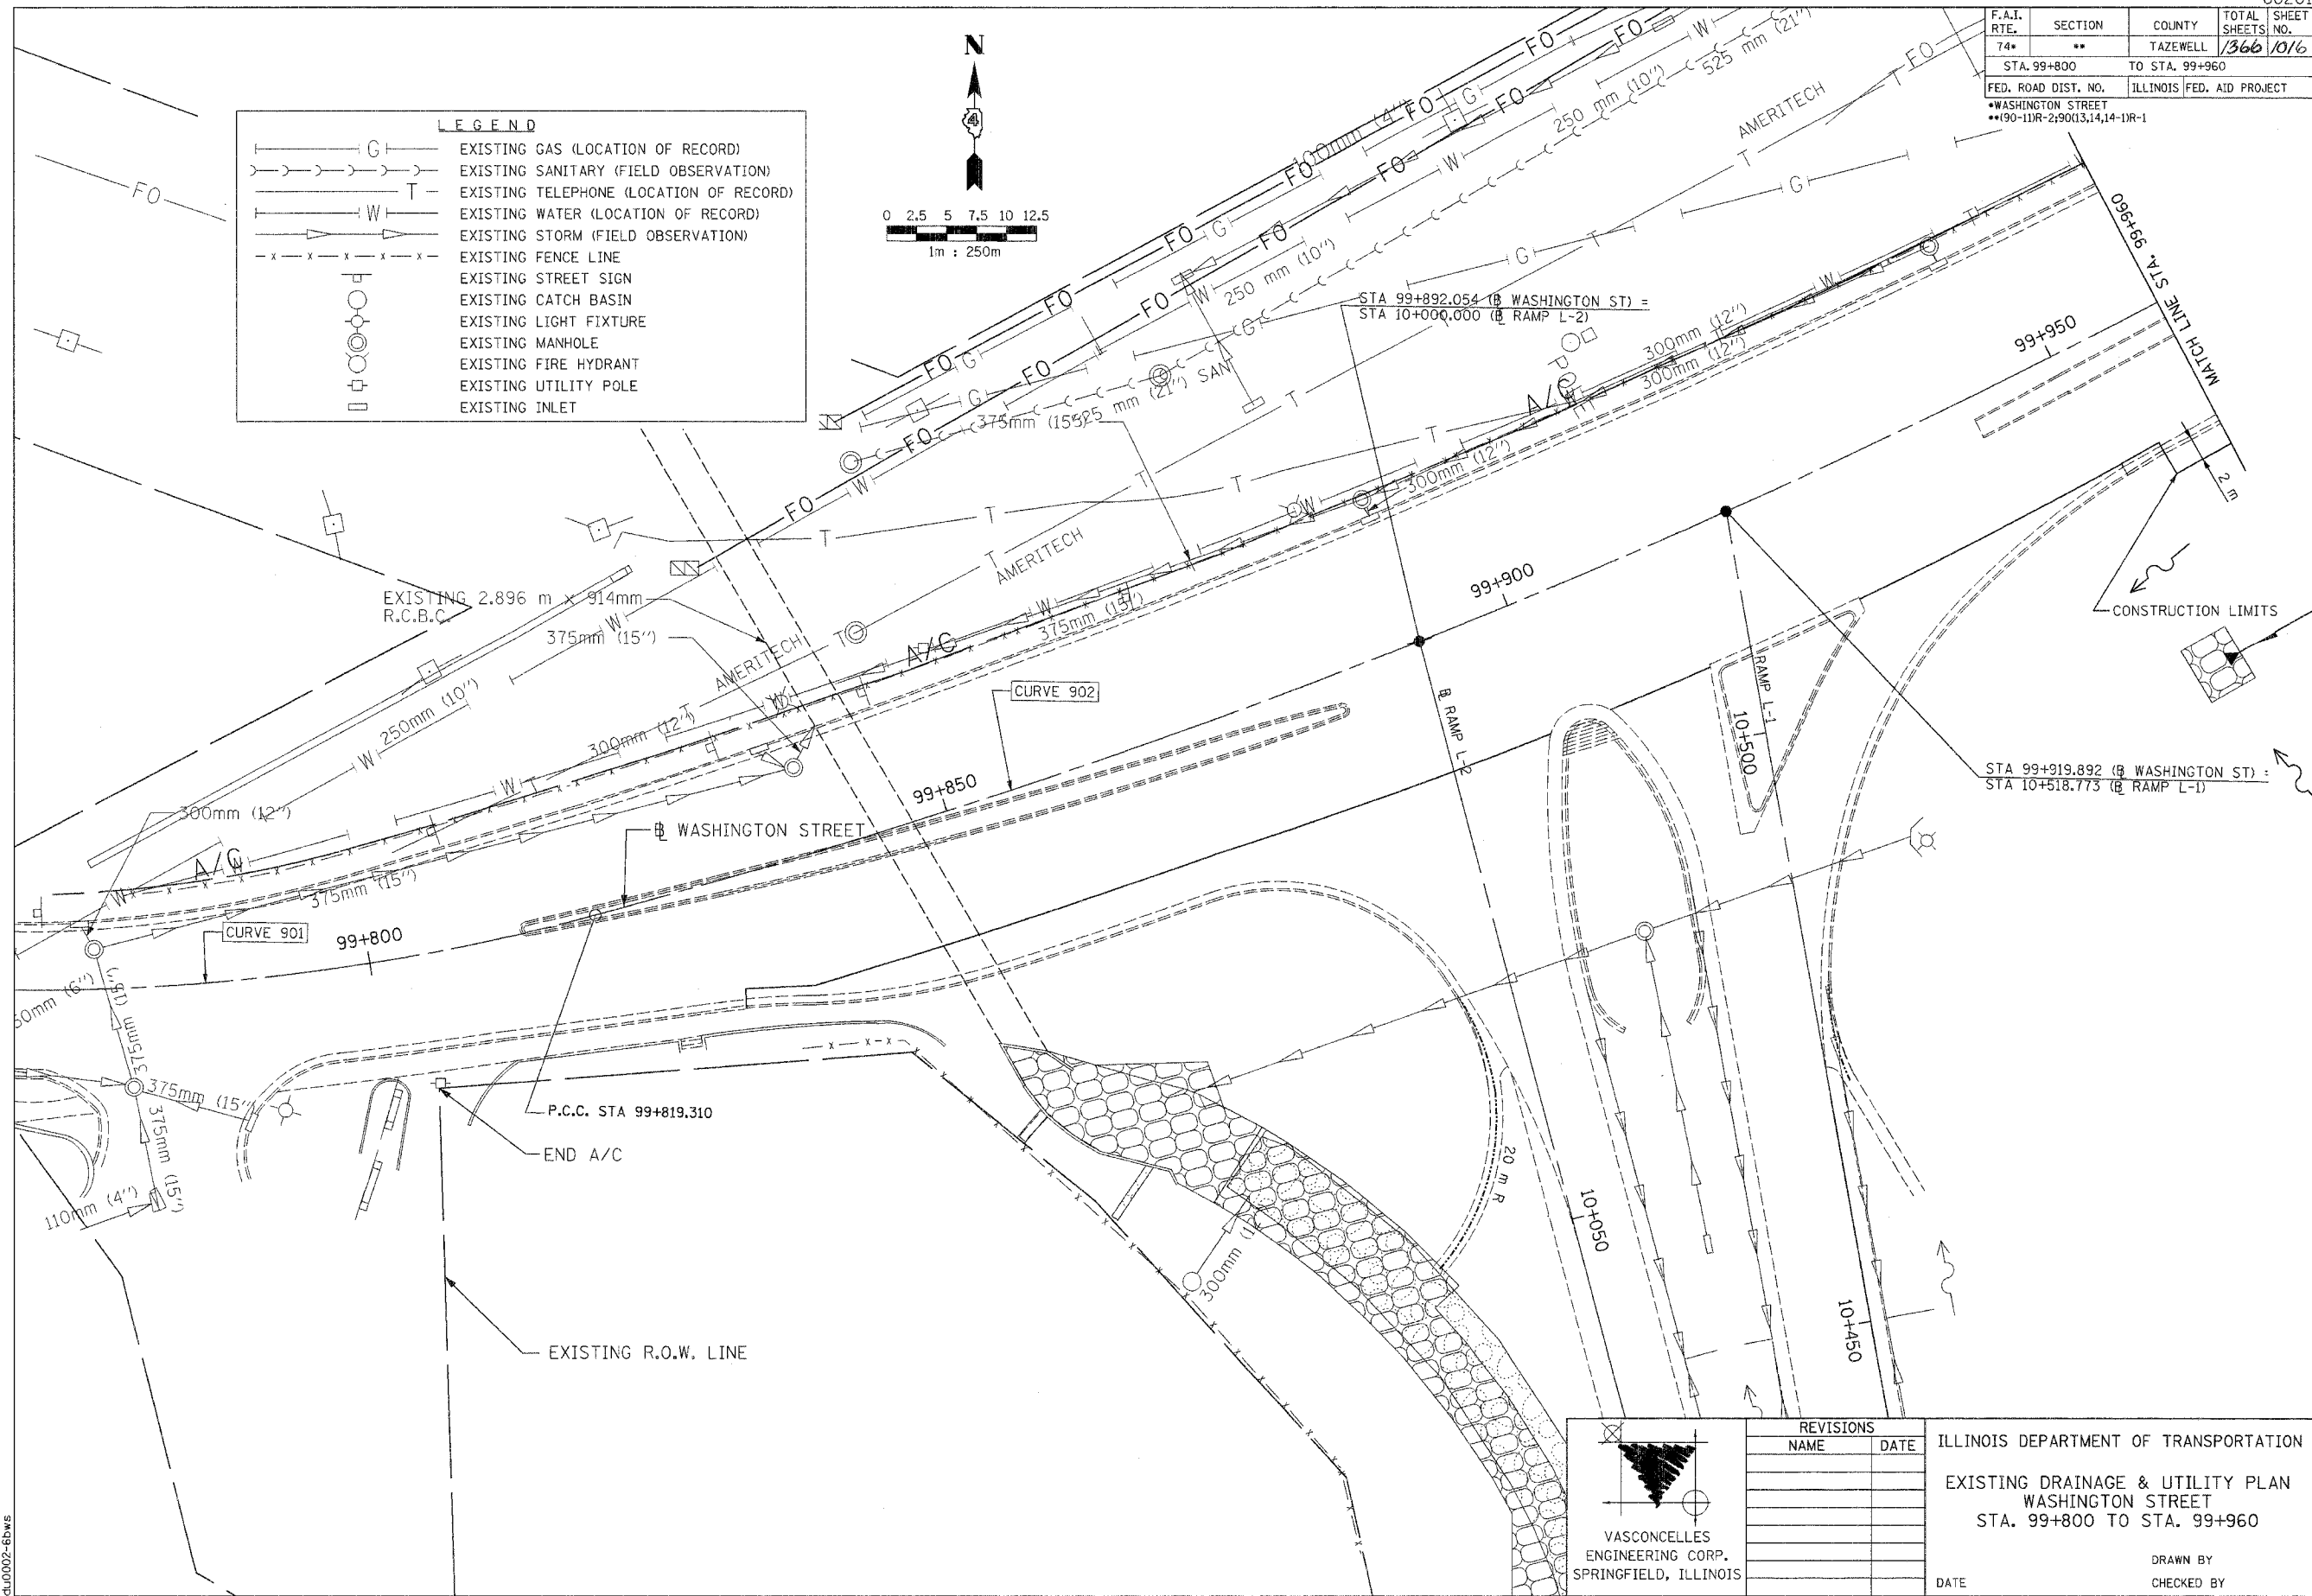


F.A.I. RTE.	SECTION	COUNTY	TOTAL SHEETS	SHEET NO.
74*	**	TAZEWELL	1366	1016
STA. 99+800		TO STA. 99+960		
FED. ROAD DIST. NO.	ILLINOIS	FED. AID PROJECT		

WASHINGTON STREET
 **90-11R-2;9013.14,14-1R-1

LEGEND

— G —	EXISTING GAS (LOCATION OF RECORD)
- - - - -	EXISTING SANITARY (FIELD OBSERVATION)
- - - - -	EXISTING TELEPHONE (LOCATION OF RECORD)
- - - - -	EXISTING WATER (LOCATION OF RECORD)
- - - - -	EXISTING STORM (FIELD OBSERVATION)
- x - x - x - x - x -	EXISTING FENCE LINE
⊠	EXISTING STREET SIGN
⊡	EXISTING CATCH BASIN
⊠	EXISTING LIGHT FIXTURE
⊡	EXISTING MANHOLE
⊡	EXISTING FIRE HYDRANT
⊡	EXISTING UTILITY POLE
⊡	EXISTING INLET

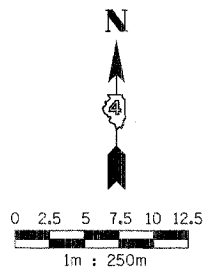

dl0002-6bws

VASCONCELLES ENGINEERING CORP.
 SPRINGFIELD, ILLINOIS

REVISIONS	
NAME	DATE

ILLINOIS DEPARTMENT OF TRANSPORTATION
 EXISTING DRAINAGE & UTILITY PLAN
 WASHINGTON STREET
 STA. 99+800 TO STA. 99+960

DATE _____ DRAWN BY _____
 CHECKED BY _____

CONTRACT III PLAN SET 2 OF 3 PRE-FINAL 02/02/04 VEC 24 OF 53. JOB NO. 751-501 VASCONCELLES ENGINEERING CORP. DESIGN FIRM REGISTRATION NUMBER 18-002107