
 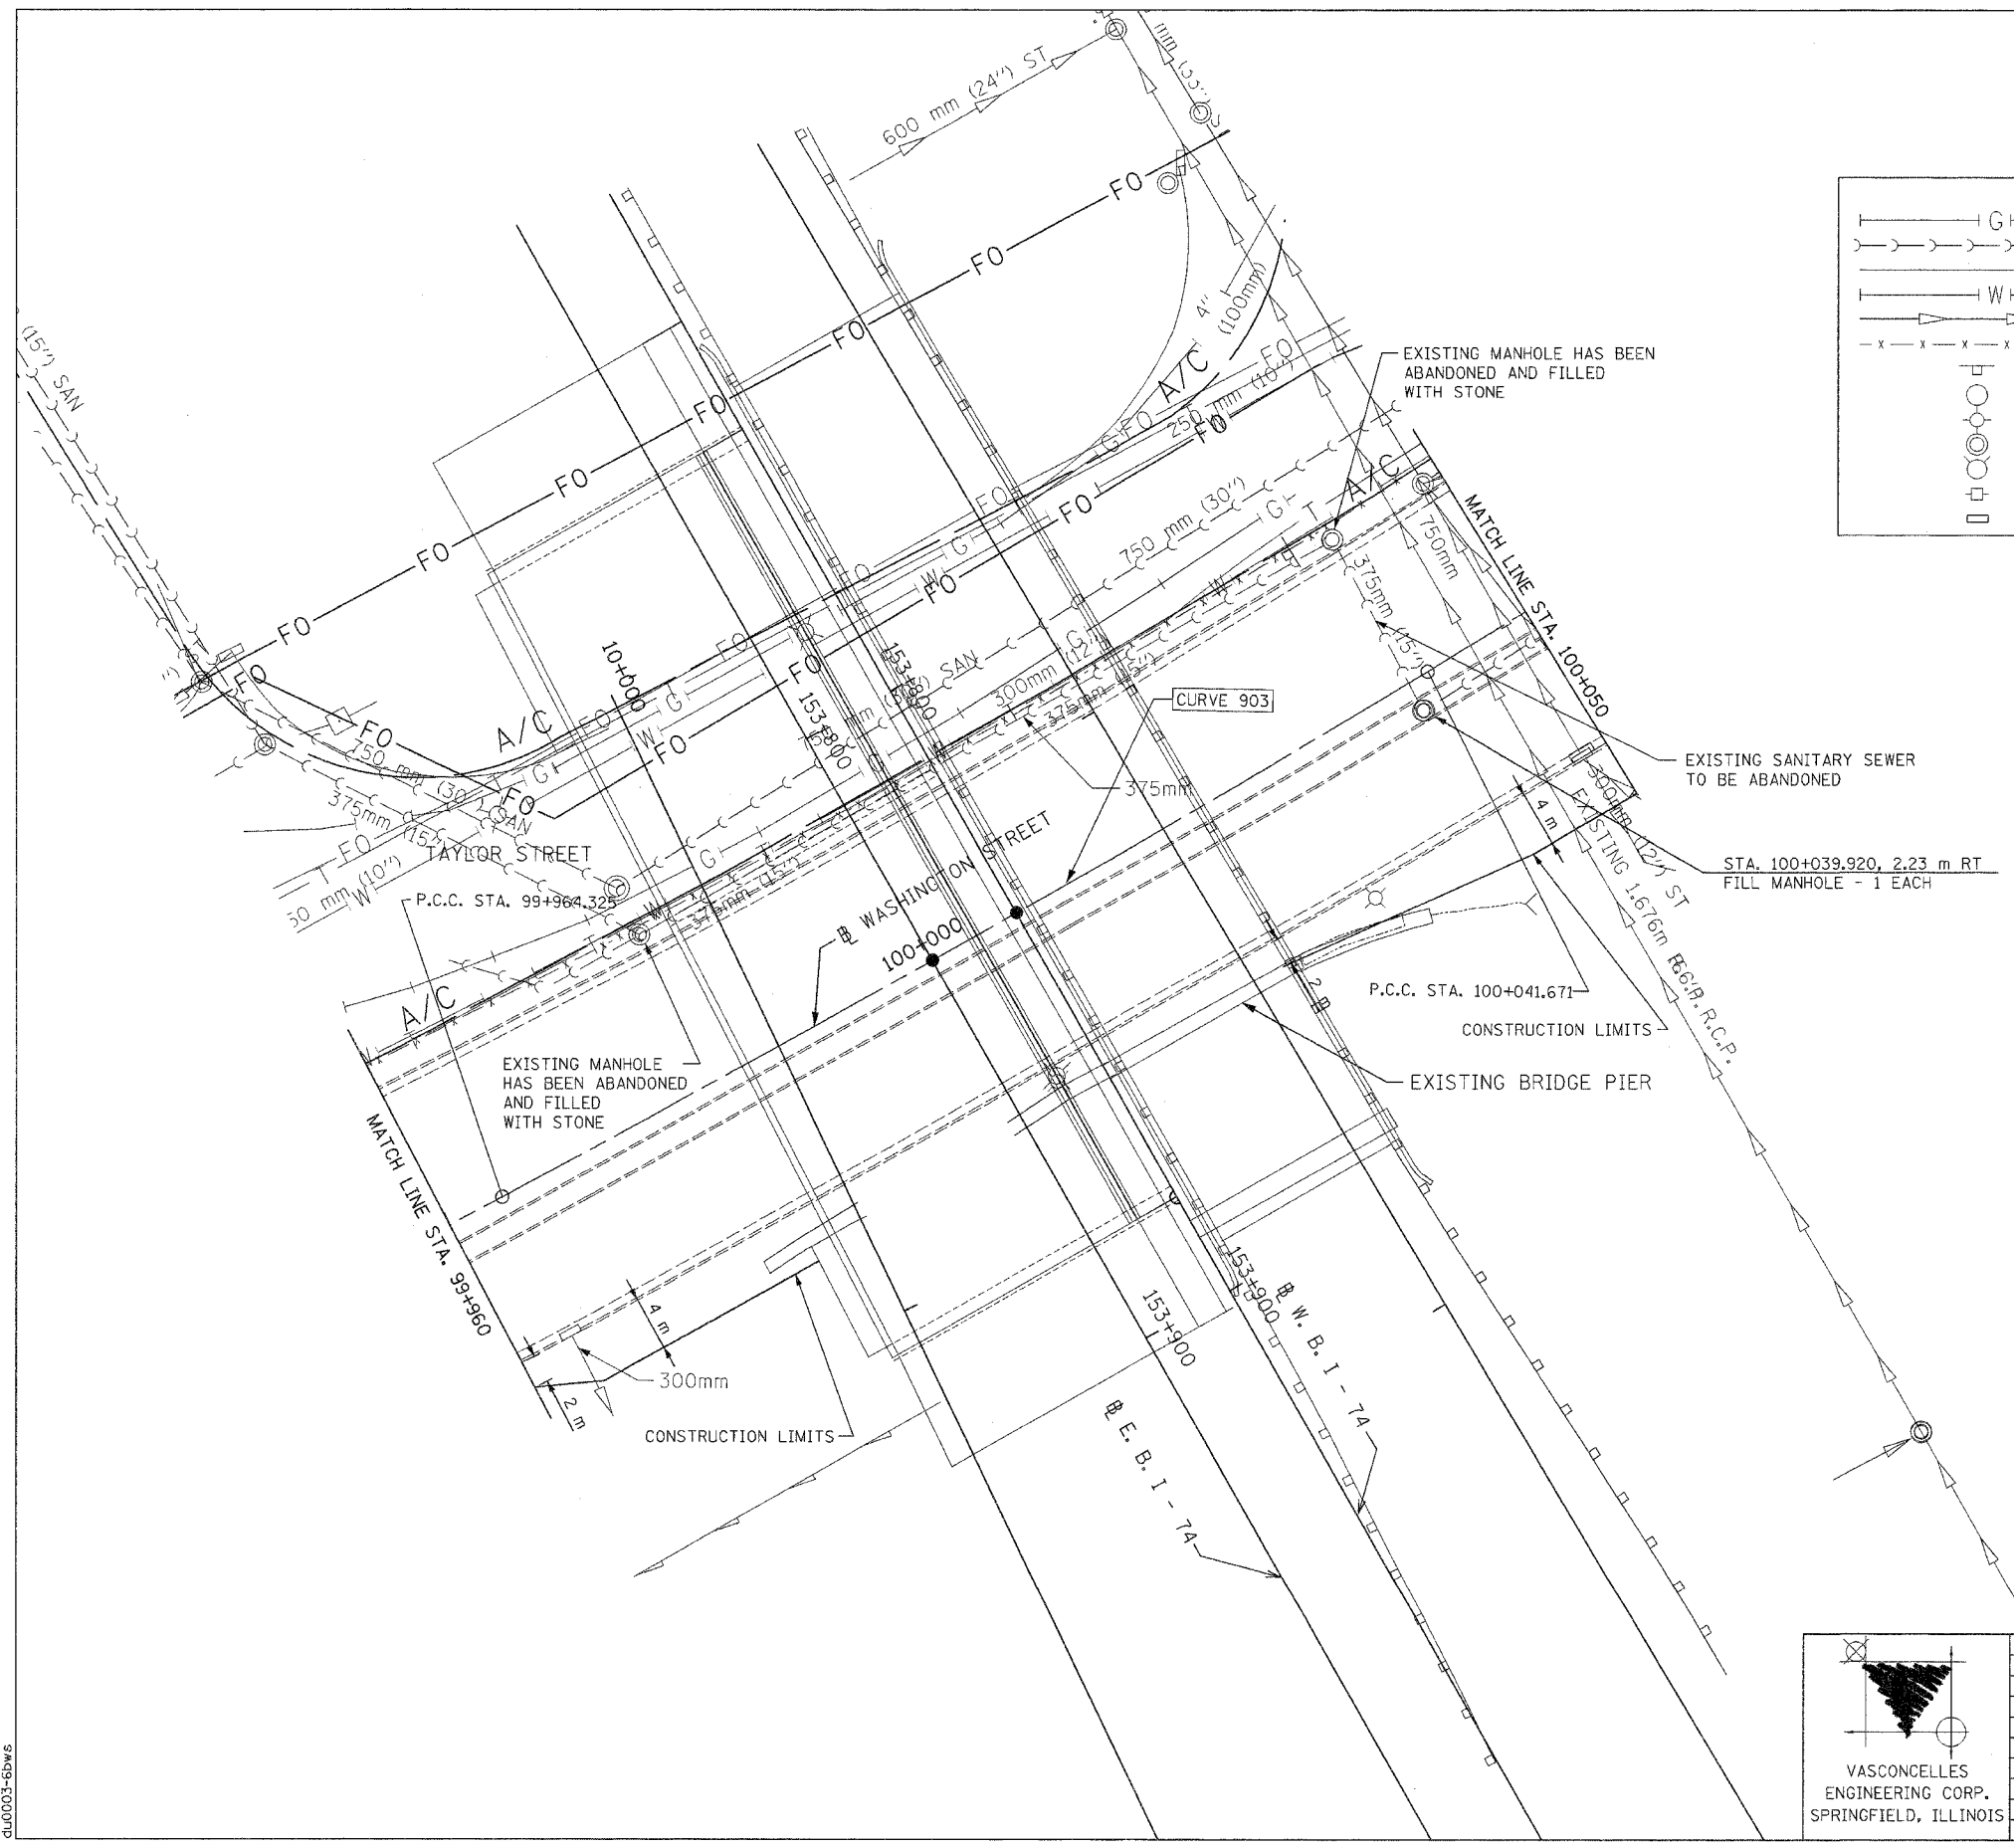


F.A.I. RTE.	SECTION	COUNTY	TOTAL SHEETS	SHEET NO.
74*	**	TAZEWELL	1366	1018
STA. 99+900		TO STA. 100+050		
FED. ROAD DIST. NO.	ILLINOIS	FED. AID PROJECT		
*WASHINGTON STREET				
**190-11R-2,90(13,14,14-1R-1				

LEGEND	
	EXISTING GAS (LOCATION OF RECORD)
	EXISTING SANITARY (FIELD OBSERVATION)
	EXISTING TELEPHONE (LOCATION OF RECORD)
	EXISTING WATER (LOCATION OF RECORD)
	EXISTING STORM (FIELD OBSERVATION)
	EXISTING FENCE LINE
	EXISTING STREET SIGN
	EXISTING CATCH BASIN
	EXISTING LIGHT FIXTURE
	EXISTING MANHOLE
	EXISTING FIRE HYDRANT
	EXISTING UTILITY POLE
	EXISTING INLET



VASCONCELLES
ENGINEERING CORP.
SPRINGFIELD, ILLINOIS

REVISIONS	
NAME	DATE

ILLINOIS DEPARTMENT OF TRANSPORTATION
EXISTING DRAINAGE & UTILITY PLAN
WASHINGTON STREET
STA. 99+960 TO 100+050

DATE _____ DRAWN BY _____
CHECKED BY _____

CONTRACT 11: PLAN SET 2 OF 3 PRE-FINAL 02/02/04 VEC 26 OF 53. JOB NO. 751-001 VASCONCELLES ENGINEERING CORP. DESIGN FIRM REGISTRATION NUMBER 184-002107

dl0003-6bws