
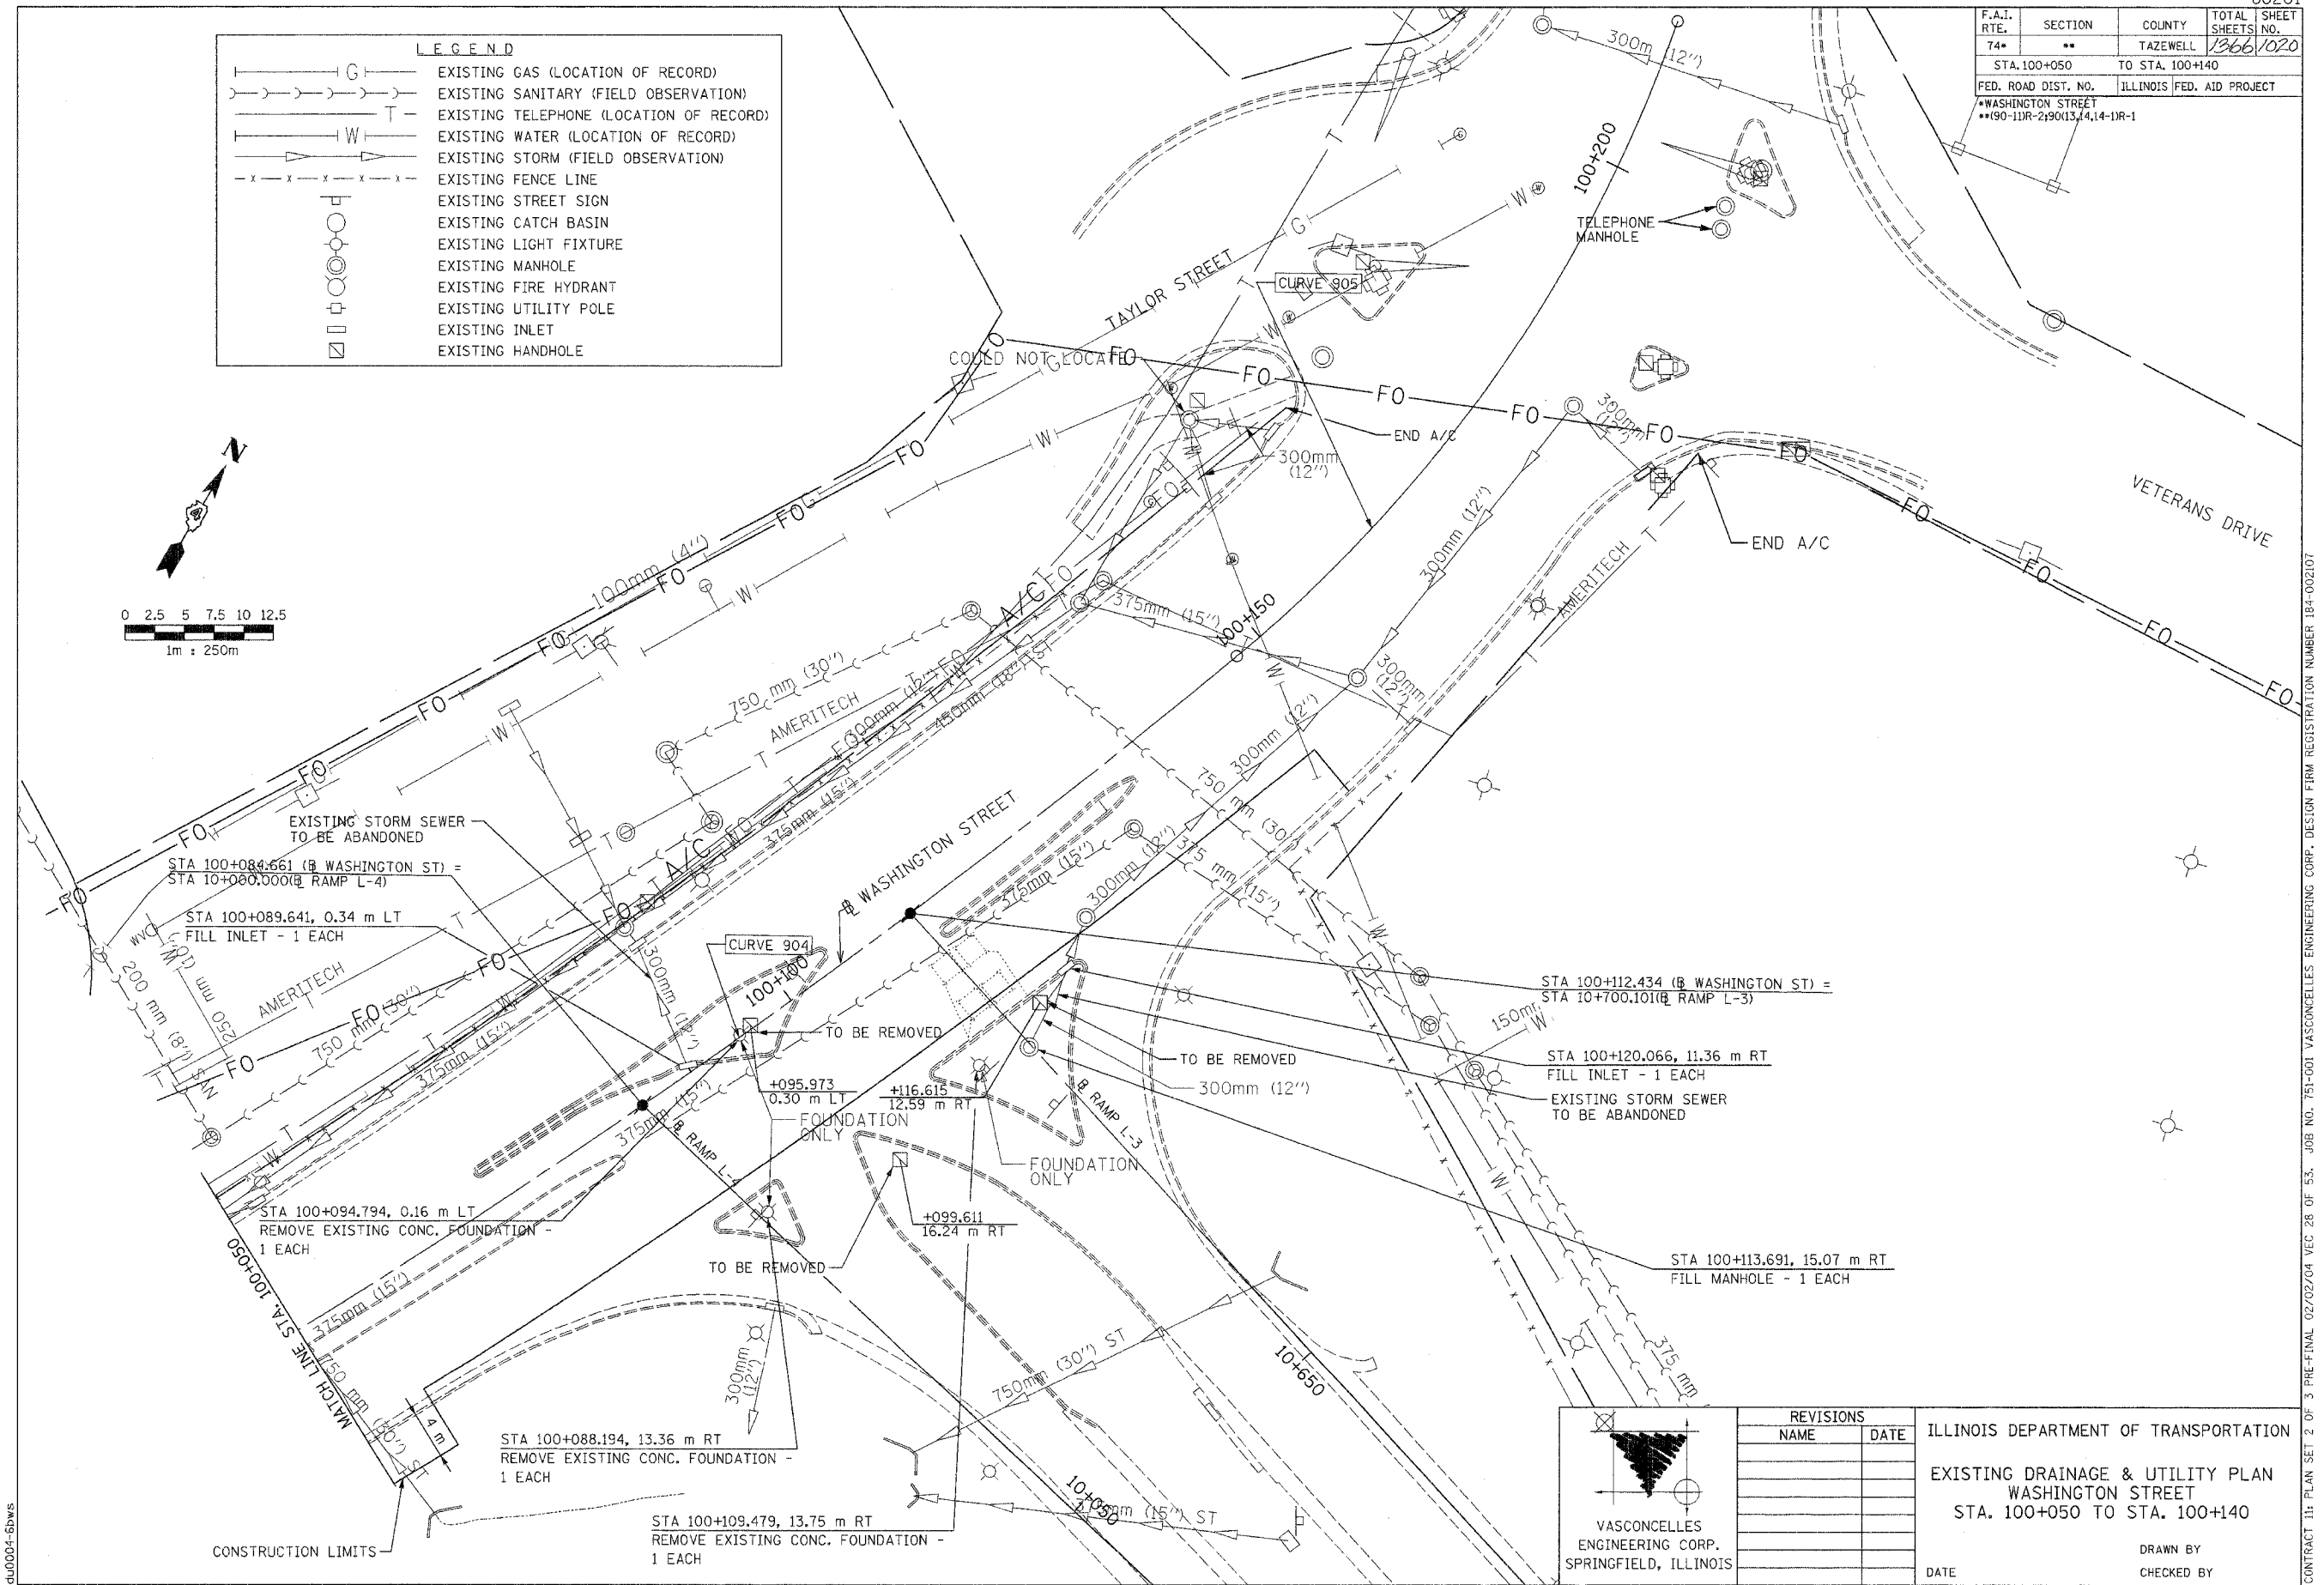


F.A.I. RTE.	SECTION	COUNTY	TOTAL SHEETS	SHEET NO.
74*	**	TAZEWELL	1366	1020
STA. 100+050		TO STA. 100+140		
FED. ROAD DIST. NO.		ILLINOIS FED. AID PROJECT		
*WASHINGTON STREET				
**90-11R-2190(13,14,14-1R-1				

LEGEND

	EXISTING GAS (LOCATION OF RECORD)
	EXISTING SANITARY (FIELD OBSERVATION)
	EXISTING TELEPHONE (LOCATION OF RECORD)
	EXISTING WATER (LOCATION OF RECORD)
	EXISTING STORM (FIELD OBSERVATION)
	EXISTING FENCE LINE
	EXISTING STREET SIGN
	EXISTING CATCH BASIN
	EXISTING LIGHT FIXTURE
	EXISTING MANHOLE
	EXISTING FIRE HYDRANT
	EXISTING UTILITY POLE
	EXISTING INLET
	EXISTING HANDHOLE

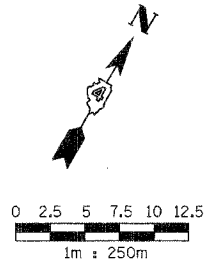

VASCONCELLES ENGINEERING CORP. SPRINGFIELD, ILLINOIS

REVISIONS	
NAME	DATE

ILLINOIS DEPARTMENT OF TRANSPORTATION
 EXISTING DRAINAGE & UTILITY PLAN
 WASHINGTON STREET
 STA. 100+050 TO STA. 100+140

DATE _____ DRAWN BY _____
 CHECKED BY _____

CONTRACT 11: PLAN SET 2 OF 3 PRE-FINAL 02/02/04 VEC 28 OF 53. JOB NO. 751-001 VASCONCELLES ENGINEERING CORP. DESIGN FIRM REGISTRATION NUMBER 184-002107