


F.A.I. RTE.	SECTION	COUNTY	TOTAL SHEETS	SHEET NO.
74		TAZEWELL	1366	1221
STA.	TO STA.			
FED. ROAD DIST. NO.	ILLINOIS	FED. AID PROJECT		
• (90-11R-2;90(13, 14, 14-1R-1				
CONTRACT NO. 68201				

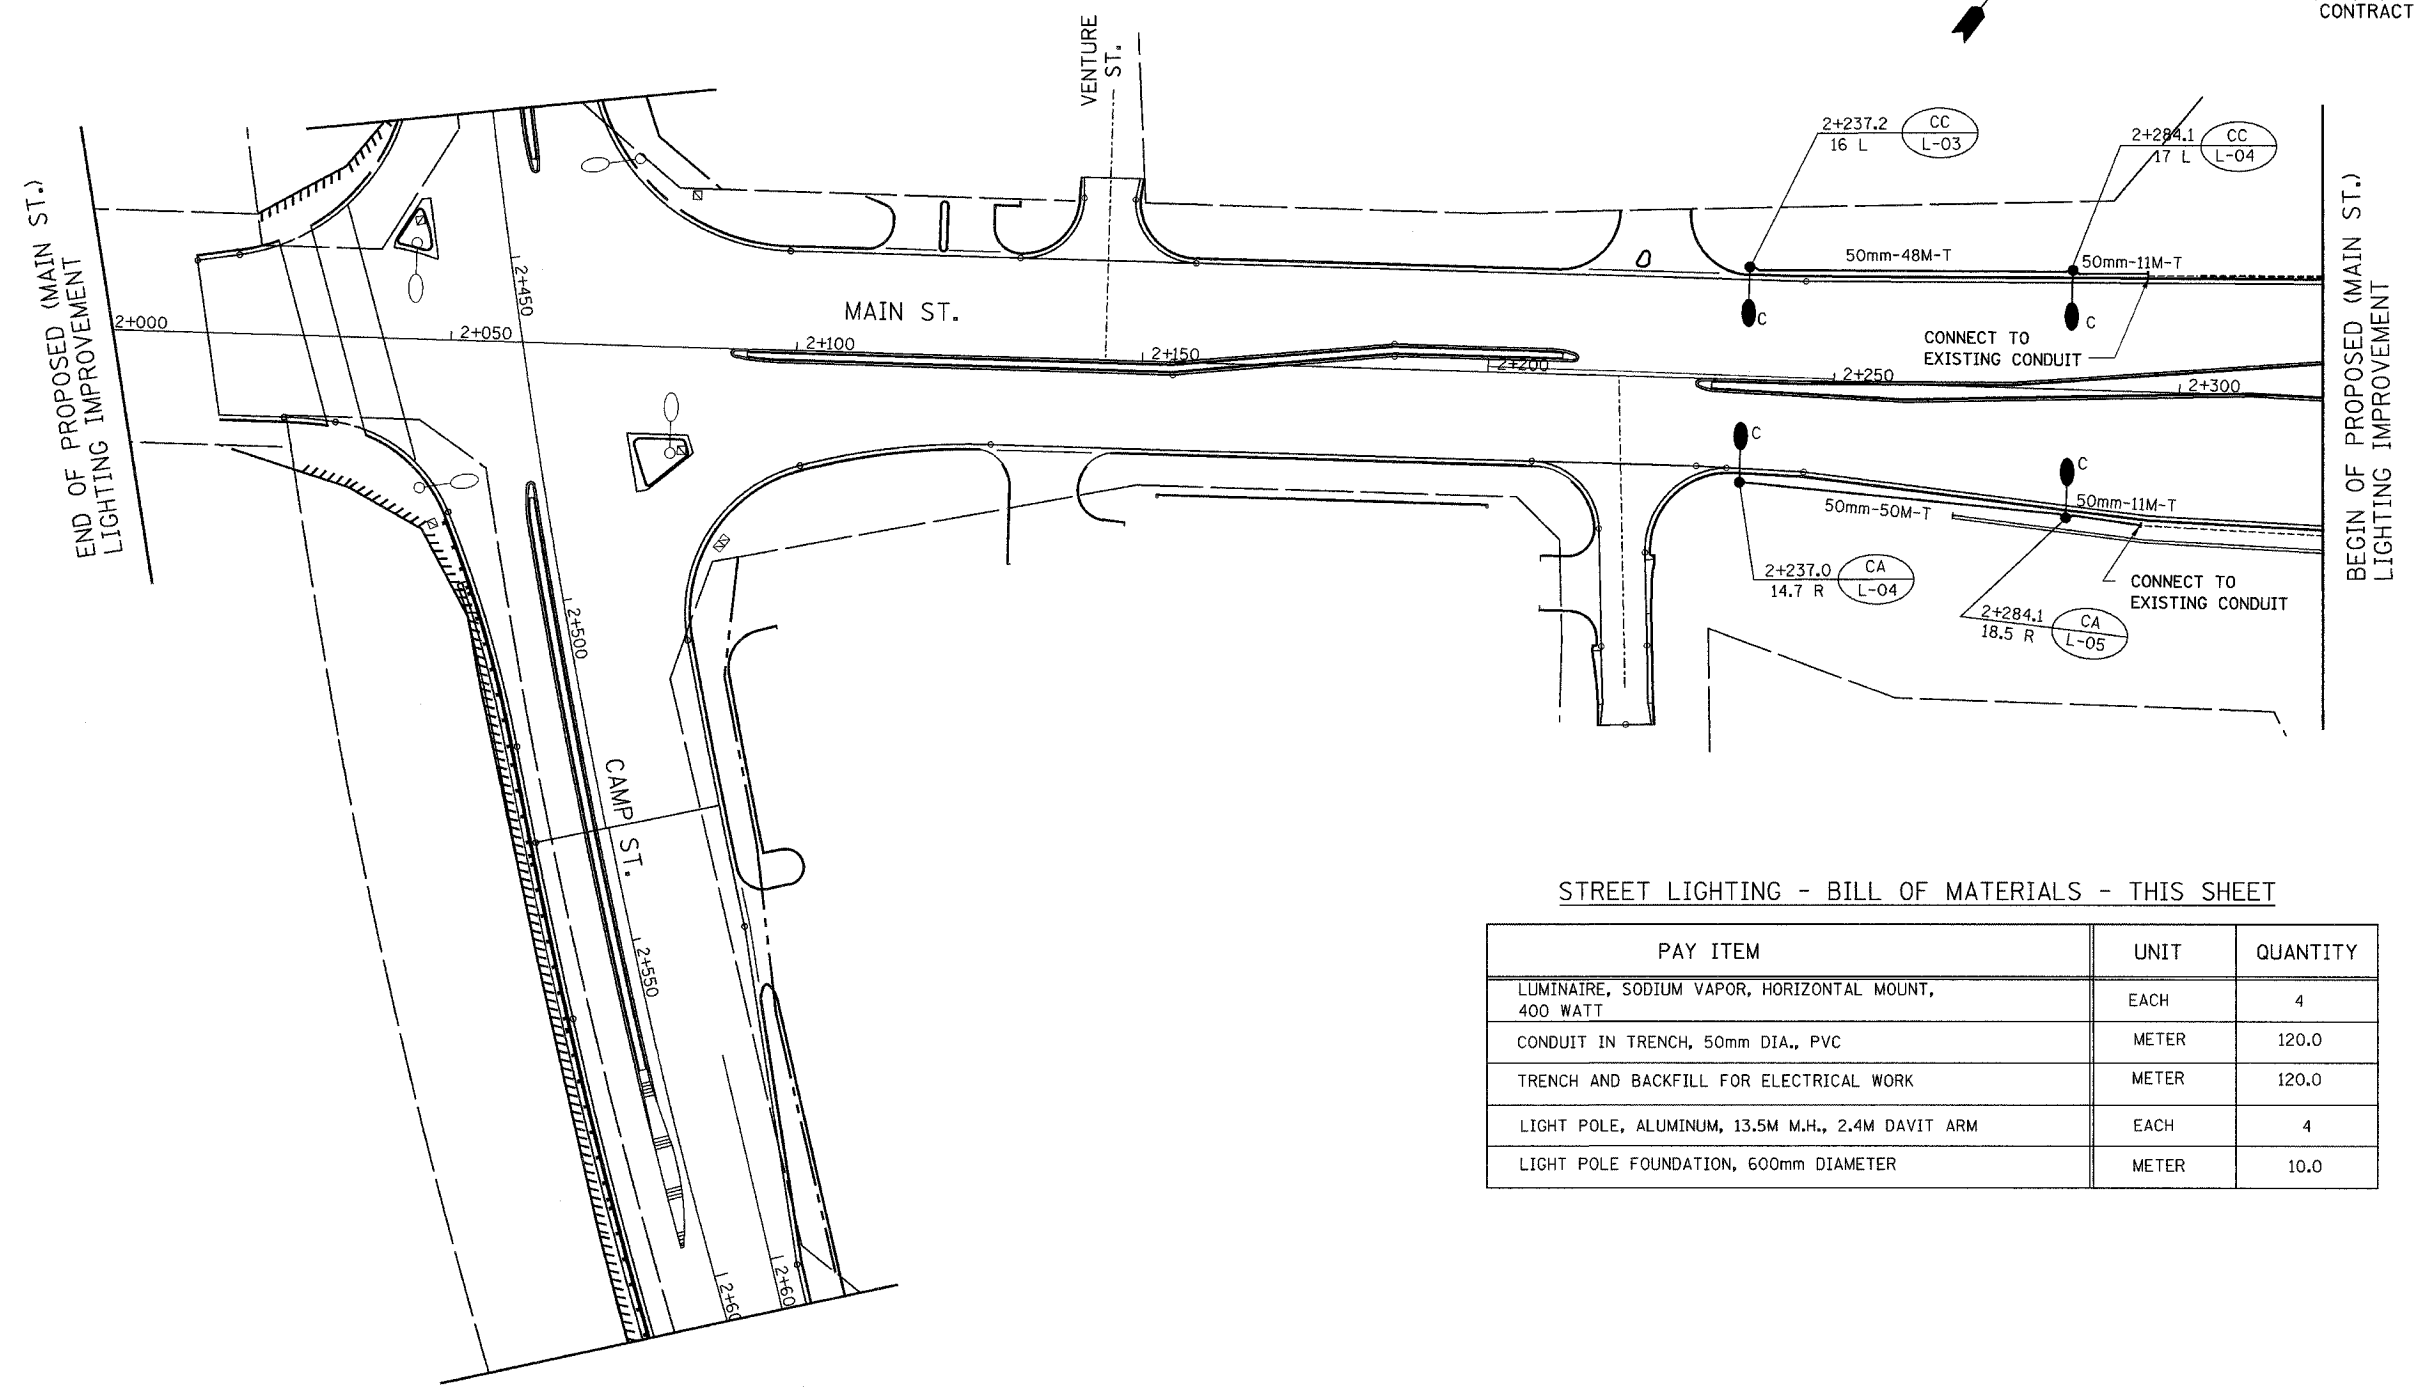

END OF PROPOSED (MAIN ST.) LIGHTING IMPROVEMENT


BEGIN OF PROPOSED (MAIN ST.) LIGHTING IMPROVEMENT

STREET LIGHTING - BILL OF MATERIALS - THIS SHEET

PAY ITEM	UNIT	QUANTITY
LUMINAIRE, SODIUM VAPOR, HORIZONTAL MOUNT, 400 WATT	EACH	4
CONDUIT IN TRENCH, 50mm DIA., PVC	METER	120.0
TRENCH AND BACKFILL FOR ELECTRICAL WORK	METER	120.0
LIGHT POLE, ALUMINUM, 13.5M M.H., 2.4M DAVIT ARM	EACH	4
LIGHT POLE FOUNDATION, 600mm DIAMETER	METER	10.0

NOTE:
USE CONDUIT COUPLING AND ADAPTER TO CONNECT PROPOSED TO EXISTING CONDUIT. COST IS INCLUDED IN " CONDUIT IN TRENCH, 50MM, DIA., PVC " PAY ITEM.

 LIGHTING SHEET 11 OF 41



ab alfred benesch & company
CONSULTING ENGINEERS
205 NORTH MICHIGAN AVENUE, CHICAGO, ILLINOIS 60601

REVISIONS	
NAME	DATE
ADDENDUM NO.1	6/11/04

ILLINOIS DEPARTMENT OF TRANSPORTATION
PROPOSED LIGHTING PLAN
N. MAIN ST.
STA. 2+000 TO STA. 2+321
DRAWN BY
CHECKED BY MKR
DATE: 12/20/04

m:\proj\1573\lighting\4.contract\1111017.dwg
12/20/2004 12:47 PM