


T:\16843A-CongressParkway\Bridges\Drawings\0162445-60P18-FSR-063M2.dgn
 3/25/2011 6:53:41 PM

 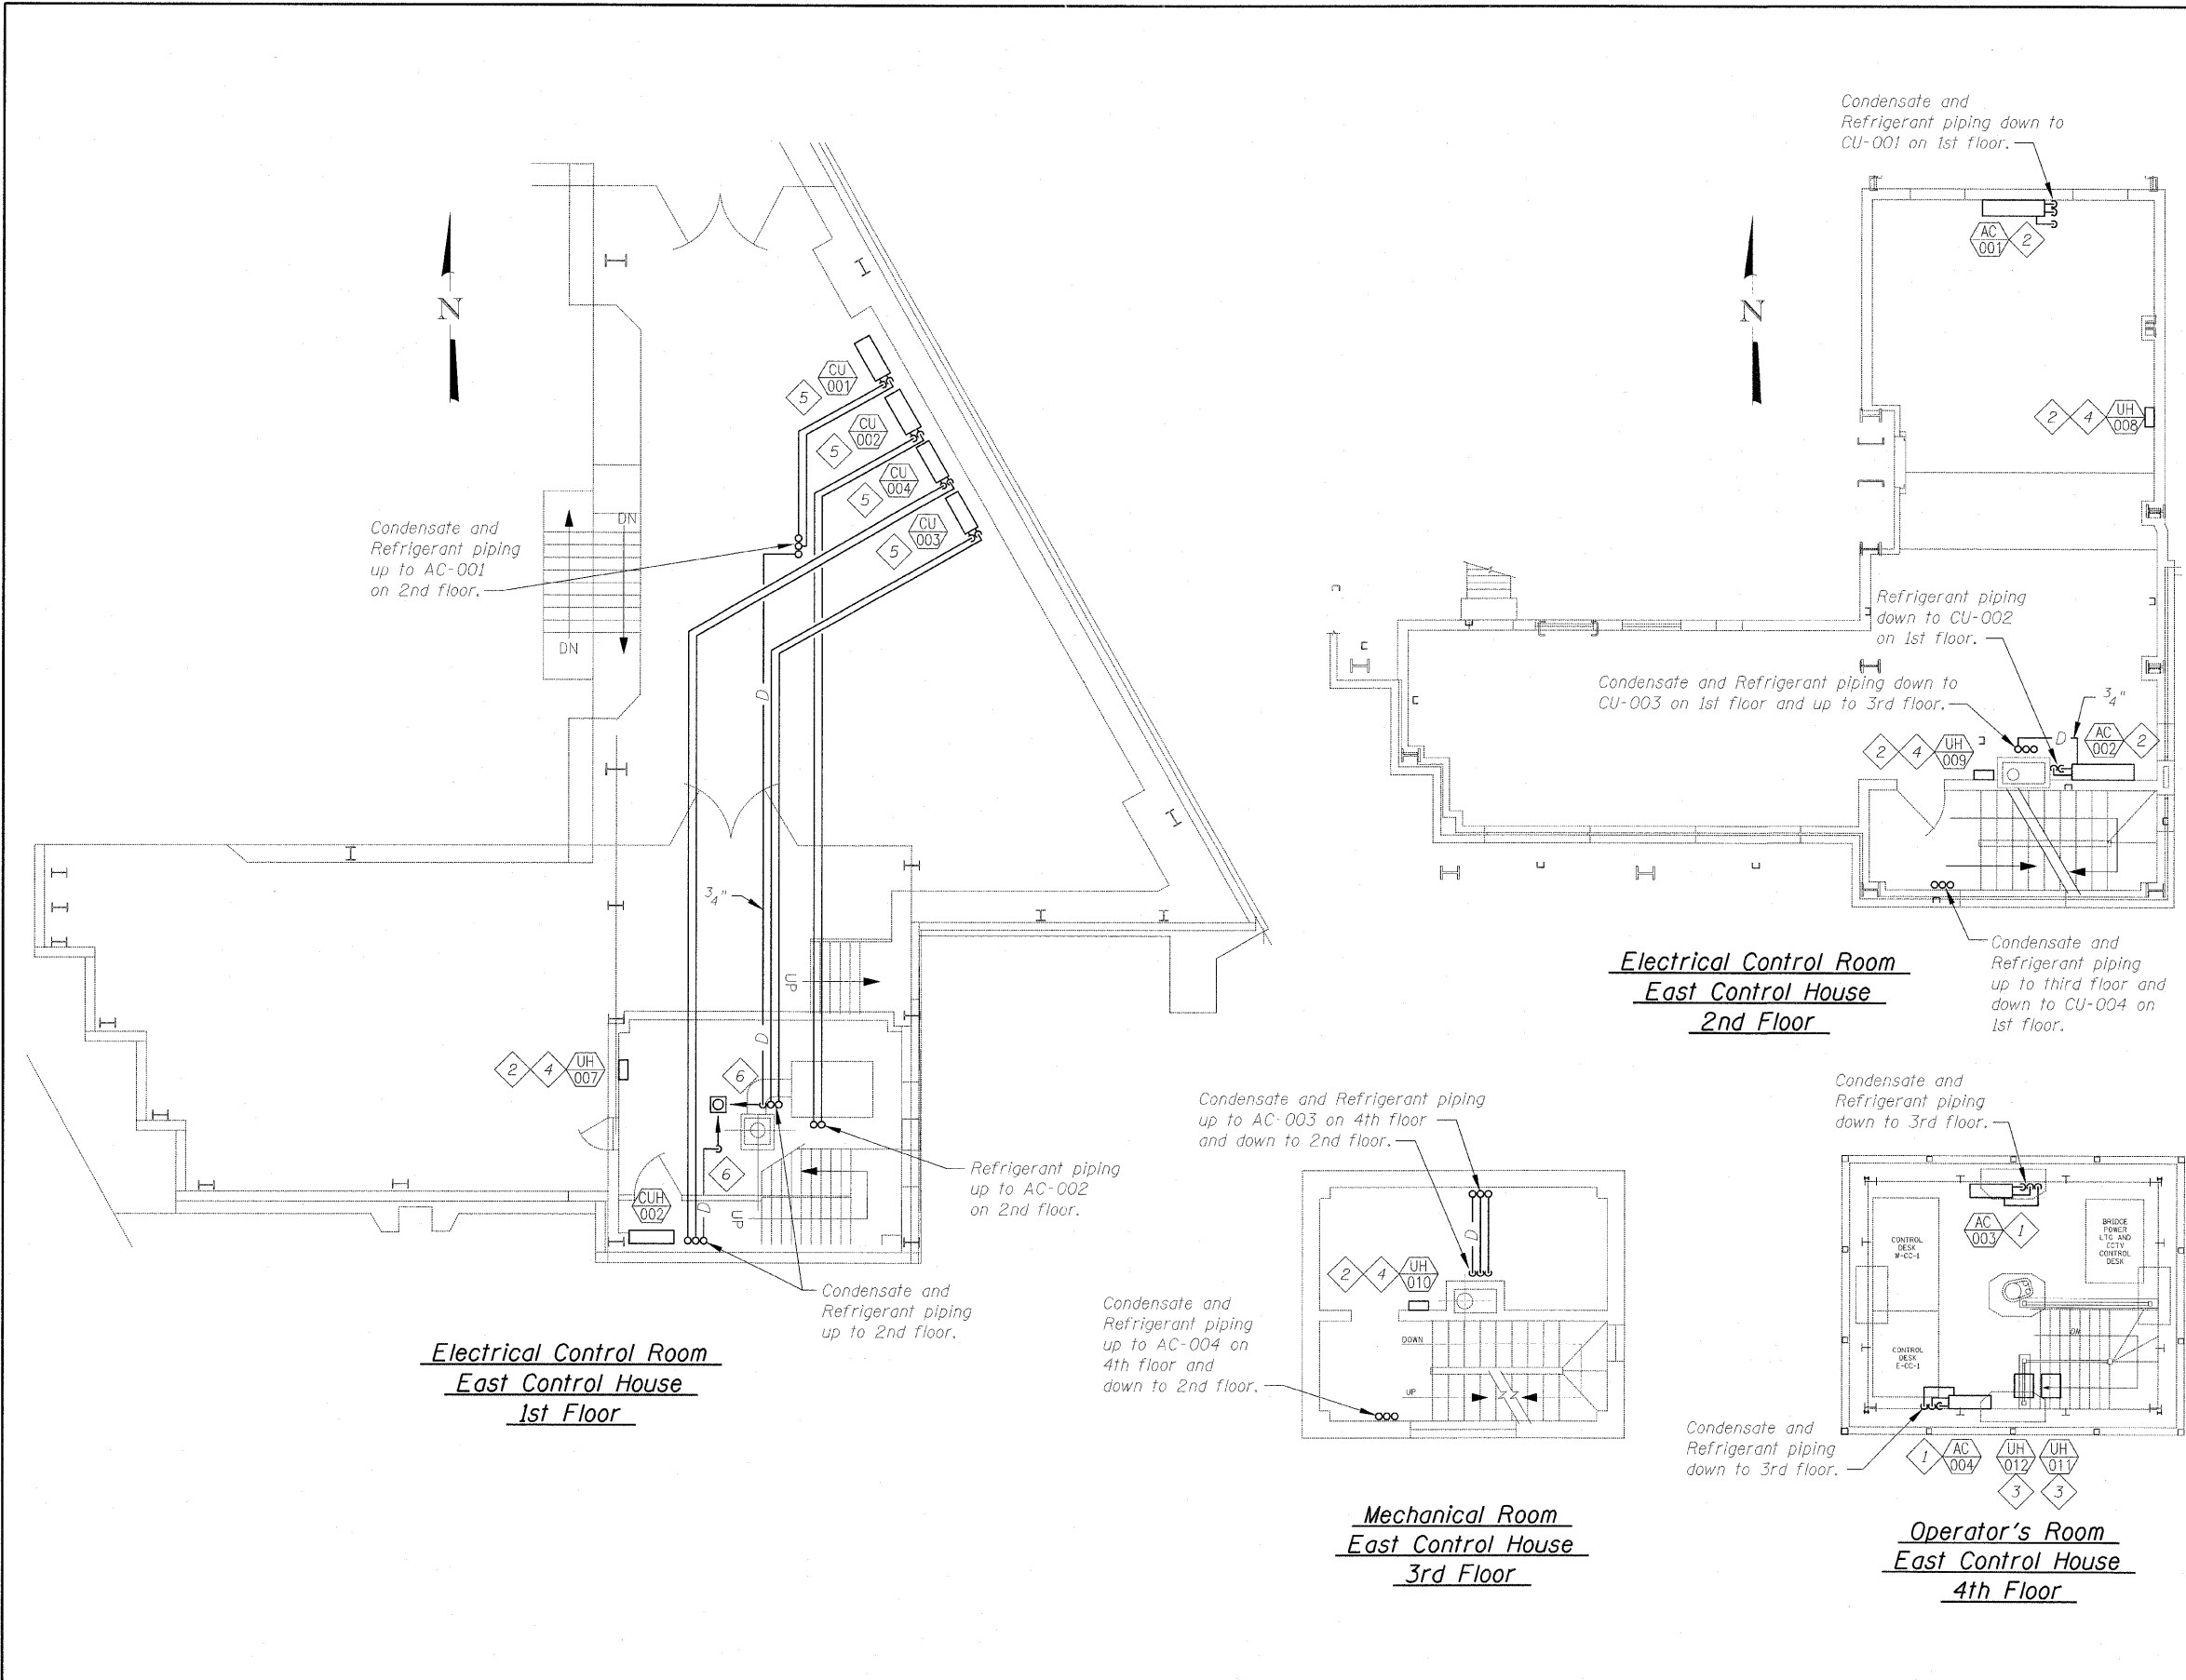


Sheet Notes:

1. Mechanical equipment locations to be coordinated with electrical equipment locations.
2. Size refrigerant piping per manufacturer's recommendations.
3. Cost of all AC and CU units and all piping is included in the cost of the Split System Air Conditioner.
4. Cost of all UH and CUH is included in the cost of Unit Heaters.

Sheet Key Notes:

- 1 Bottom of Equipment (BOE) = 0'-2" AFF
- 2 BOE = 6'-0" AFF
- 3 Ceiling mounted vertical discharge.
- 4 Horizontal discharge.
- 5 Install on 6" concrete slab. Secure condensing unit using Series I cage by Property Armor (www.propertyarmor.net) or equal. The cost of this item is included in the cost of the Split System Air Conditioner.
- 6 Extend condensate drain to nearest floor drain. The cost of this item is included in the cost of the Split System Air Conditioner.



USER NAME	kienstra	DESIGNED	S. KALYONCU	REVISED	
		CHECKED	K. TELLA	REVISED	
PLOT SCALE		DRAWN	E. KIENSTRA	REVISED	
PLOT DATE	3/25/2011	CHECKED	K. TELLA	REVISED	

**STATE OF ILLINOIS
 DEPARTMENT OF TRANSPORTATION**

**EAST CONTROL HOUSE RENOVATION
 FLOOR PLANS
 FOR STRUCTURE NO. 016-2445**

F.A.P. RTE.	SECTION	COUNTY	TOTAL SHEETS	SHEET NO.
389	2424.2B-I-2	COOK	14	8
CONTRACT NO. 60P18				
FED. ROAD DIST. NO. 7 [ILLINOIS] FED. AID PROJECT				

SHEET NO. M2 OF M4 SHEETS