




F.A.P. RTE.	SECTION	COUNTY	TOTAL SHEETS	SHEET NO.
348	10-00251-00-MS	COOK	16	14
STA.		TO STA.		
FED. ROAD DIST. NO.		ILLINOIS FED. AID PROJECT		

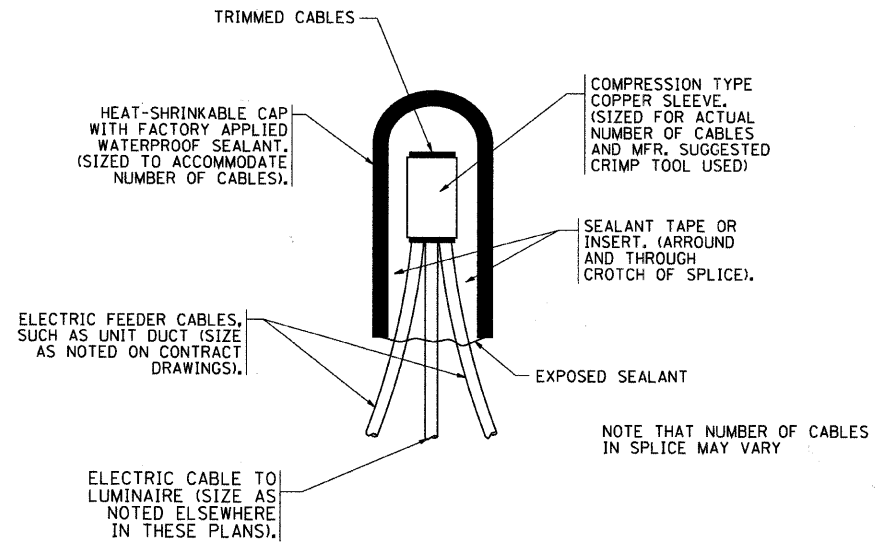

TYPICAL SPLICE DETAIL  
N.T.S.

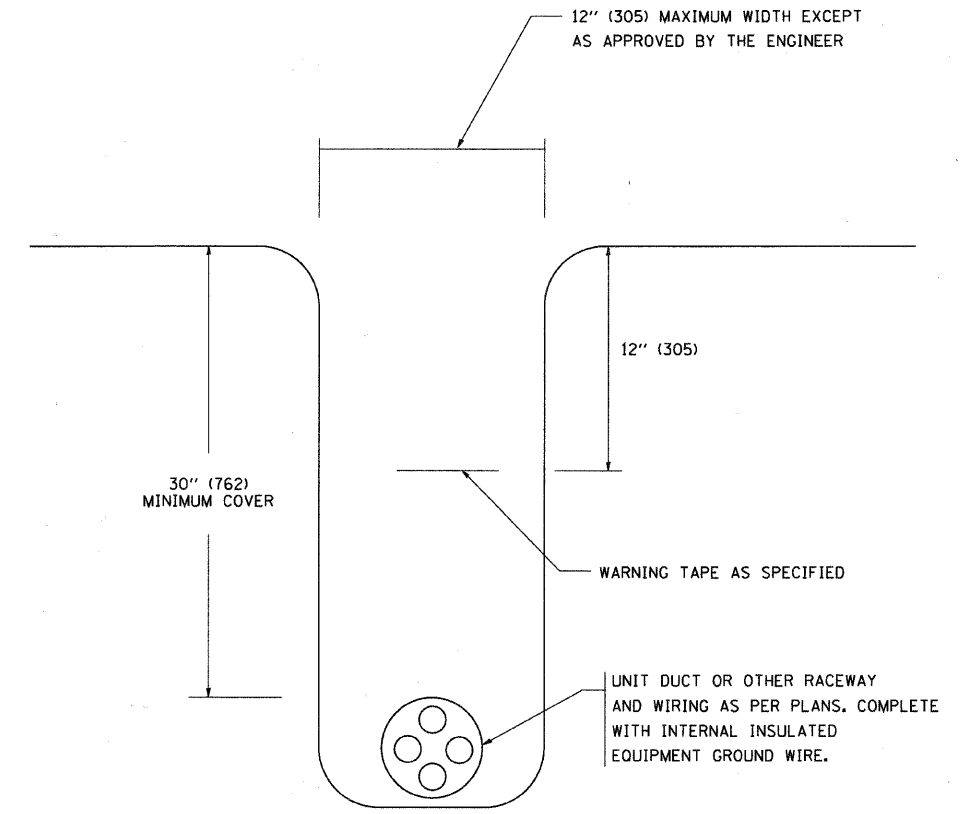

TYPICAL WIRING IN TRENCH DETAIL  
N.T.S.

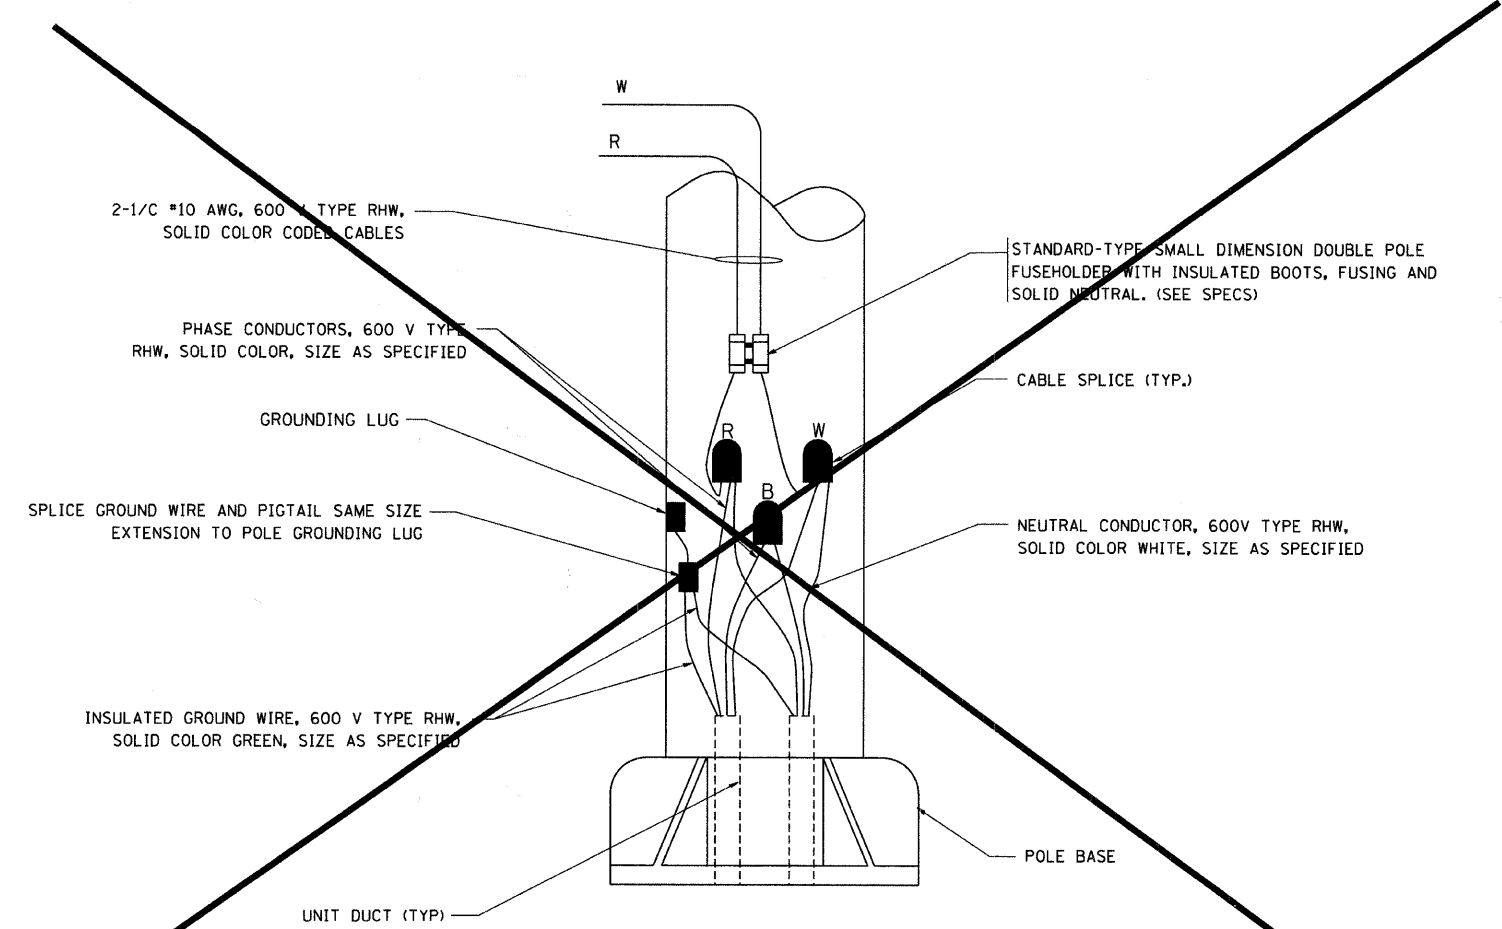

POLE WIRING DETAIL  
N.T.S.

PLOT DATE = 2/27/2007  
 FILE NAME = K:\chassis\bar762.dgn  
 PLOT SCALE = 1/8" = 1'-0"  
 USER NAME = bbarndt

REVISIONS	
NAME	DATE

ILLINOIS DEPARTMENT OF TRANSPORTATION

MISC. ELECTRICAL DETAILS  
SHEET A

SCALE: VERT. 1/8" = 1'-0"  
HORIZ. 1/8" = 1'-0"  
DATE: 2/27/2007

DRAWN BY  
CHECKED BY  
BE-702  
REVISION DATE: 01/01/07