



PLAN	SURVEYED	BY	DATE
	PLOTTED		
	CHECKED		
	BY		
	NO. OF WAY CHECKED		
	PAID FILE NAME		
	NO.		

PROFILE	SURVEYED	BY	DATE
	PLOTTED		
	CHECKED		
	BY		
	NO. OF WAY CHECKED		
	STRUCTURE NOTATIONS OK'D		
	NO.		

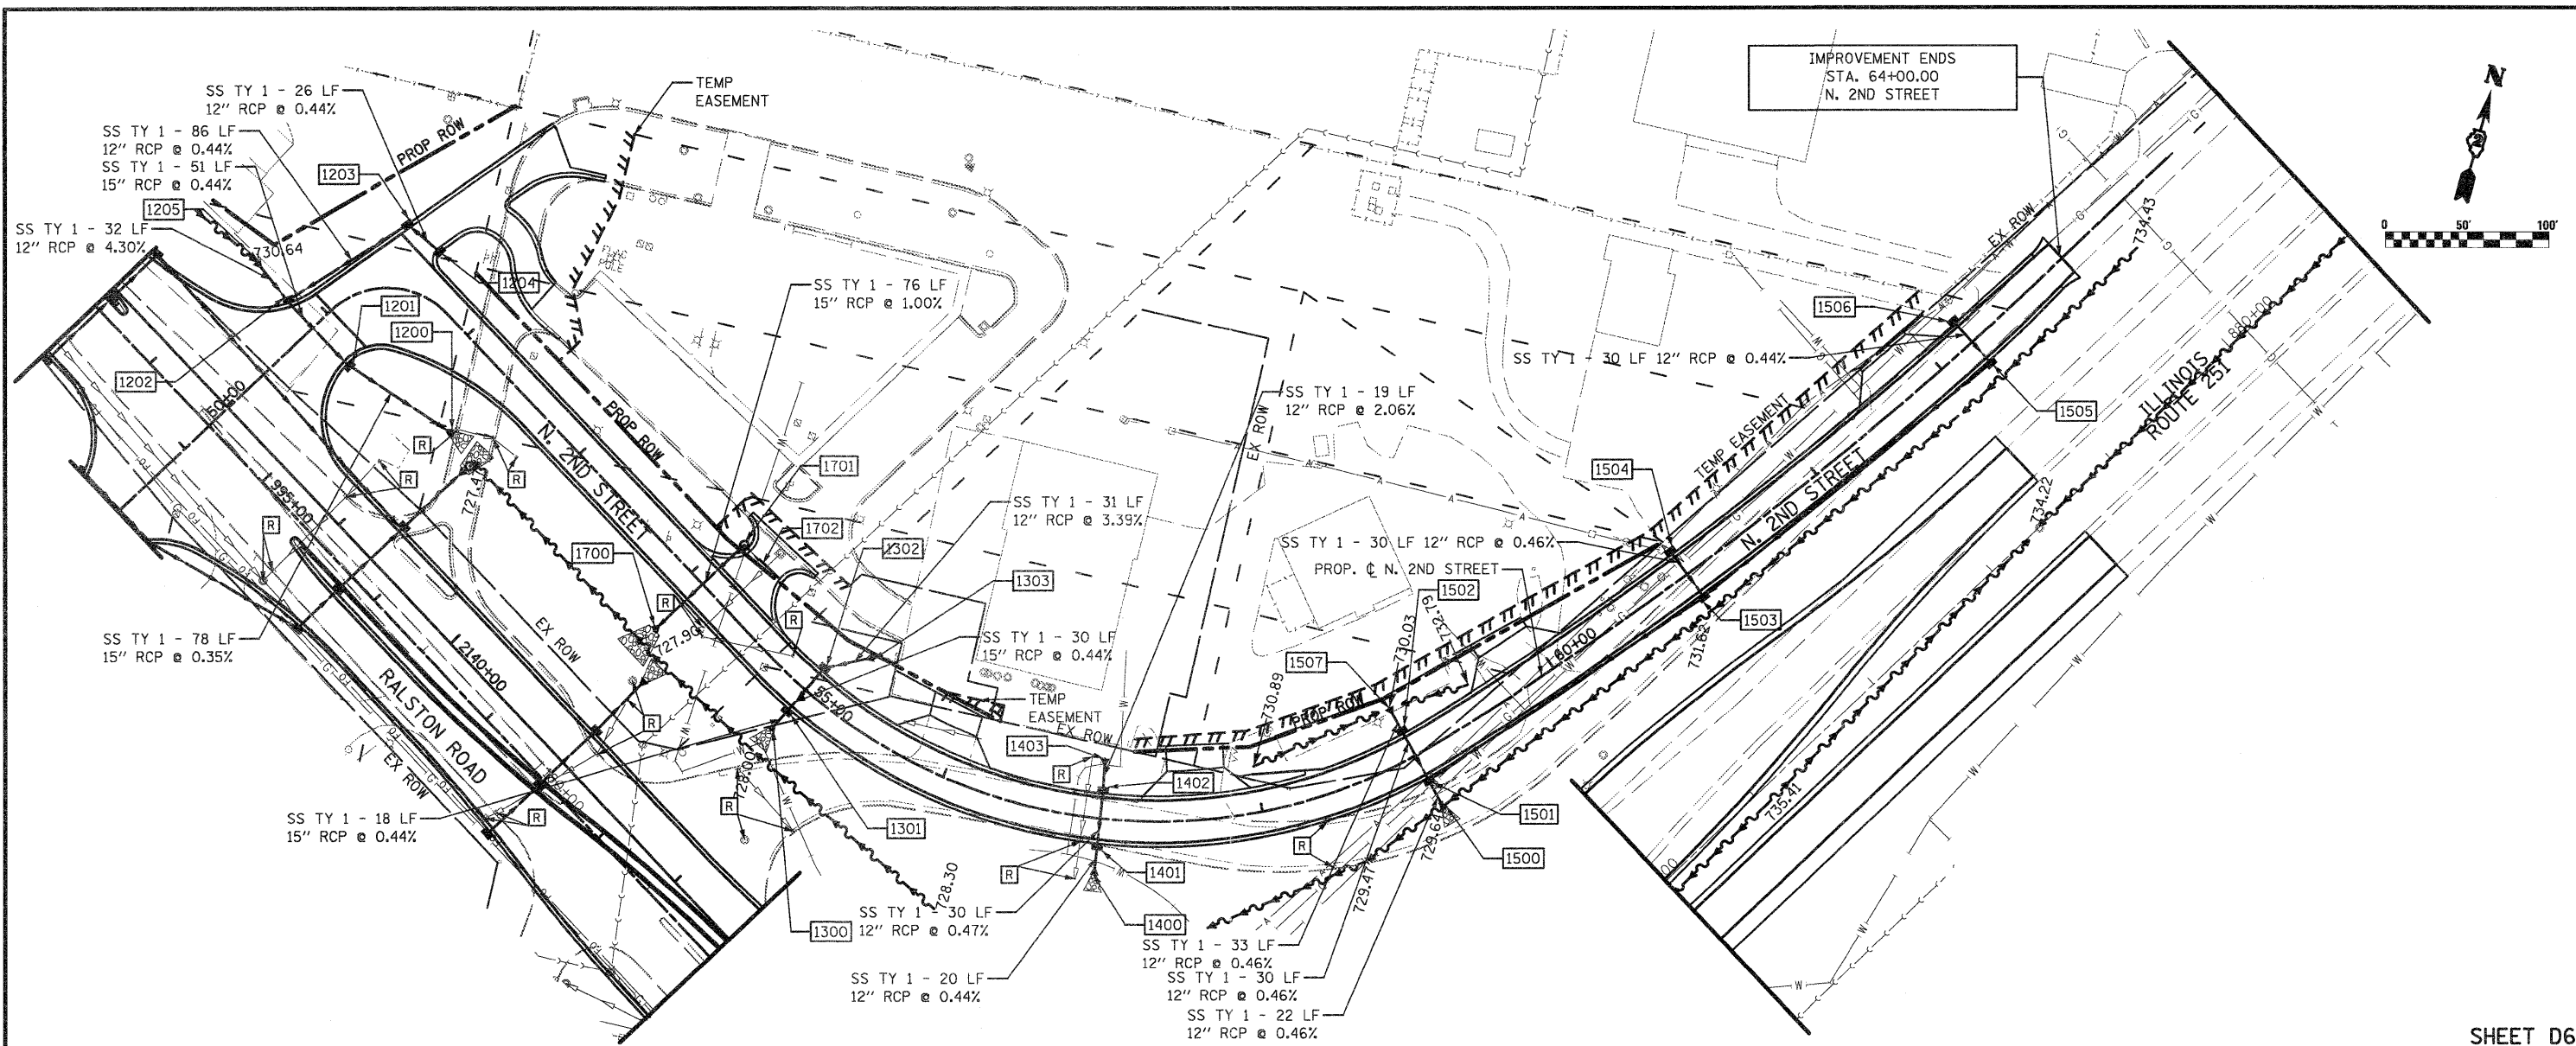

SHEET D6

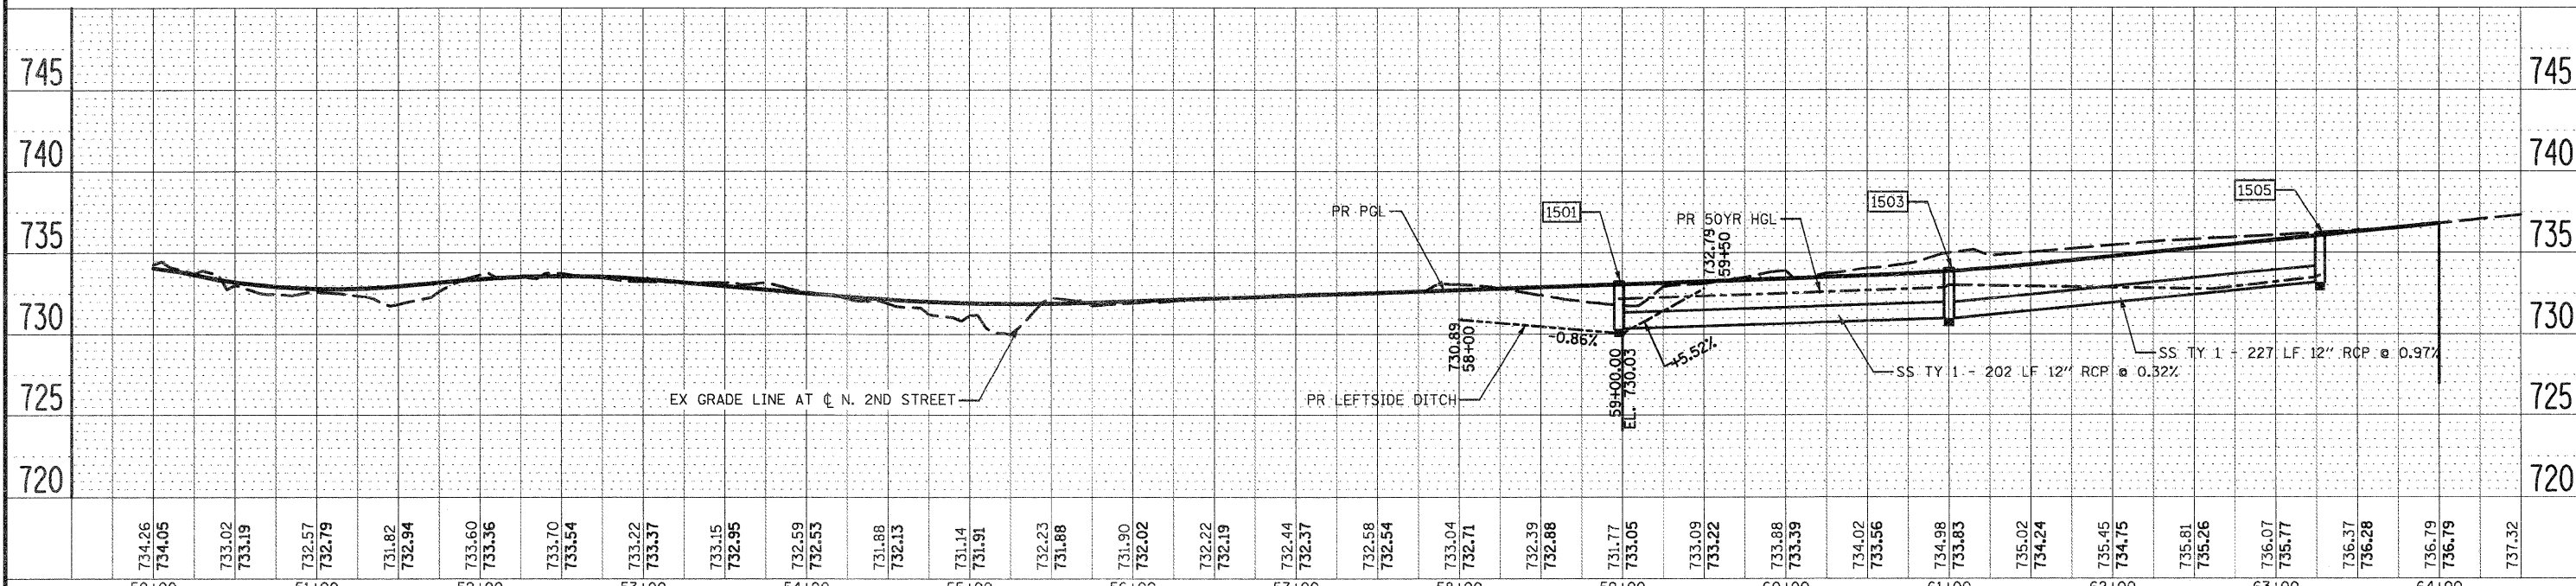

FILE NAME = D264987-shd-draun-06.dgn	USER NAME = 3282890971	DESIGNED - LOM	REVISED -	STATE OF ILLINOIS DEPARTMENT OF TRANSPORTATION	DRAINAGE AND UTILITY PLAN N. 2ND STREET	F.A.P. RTE. 303	SECTION 129K-1	COUNTY WINNEBAGO	TOTAL SHEETS 401	SHEET NO. 236		
	PLLOT SCALE = 100.0000' / IN.	DRAWN - MG	REVISED -			SCALE:	SHEET NO. OF SHEETS	STA. 50+00.00 TO STA. 64+00.00	CONTRACT NO. 64987			
	PLLOT DATE = 1/18/2011	CHECKED - PDK	REVISED -			FED. ROAD DIST. NO. 2 (ILLINOIS) FED. AID PROJECT						
		DATE - 01-19-2011	REVISED -									