


- REMOVAL LEGEND**
- PAVEMENT REM
 - PAVED SHLD REMOVAL
 - PAVED DITCH REMOVAL
 - REMOVAL LINEAR ITEMS (SEE CALLOUTS BELOW)
 - (A) GUARDRAIL REMOV
 - (B) CABLE ROAD GD REM
 - (C) WOV W FENCE REMOV
- NOTES:**
1. SEE DRAINAGE PLANS FOR DRAINAGE REMOVALS.
 2. SEE LIGHTING PLANS FOR LIGHTING REMOVALS.
 3. SEE PLAT OF HIGHWAYS FOR FULL EXTENT OF USAGE GENERAL PURPOSE LICENSE (GPL).
 4. SEE SCHEDULE OF QUANTITIES FOR SIGN REMOVAL PAY ITEMS AND QUANTITIES.

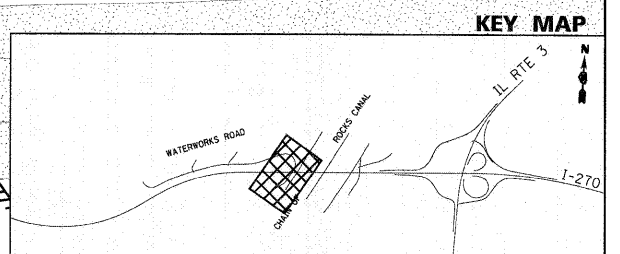

FILE NAME = 0876A91-Svt-Rem10.dgn	USER NAME = malopez	DESIGNED - SJM DRAWN - ML CHECKED - SJM DATE - 06-30-10	REVISED - 01-04-11 REVISED - REVISED - REVISED -	STATE OF ILLINOIS DEPARTMENT OF TRANSPORTATION	REMOVAL PLANS WATERWORKS ROAD	F.A.I. RTE. 270 SECTION 60-1B-1 COUNTY MADISON TOTAL SHEETS 712 SHEET NO. 47 CONTRACT NO. 76A91
				SCALE: 1" = 50'	SHEET NO. 10 OF 12 SHEETS	STA. 1433+00 TO STA. 1445+00
						ILLINOIS FED. AID PROJECT