



RIGHT SIDE LIGHTS		
POLE NO.	STATION	OFFSET
P71	11233+64.9	20.00'
P73	11234+96.8	20.00'
P75	11236+29.2	20.00'
P77	11237+59.2	20.00'

EX ROW
 W CHAIN OF ROCKS RD.

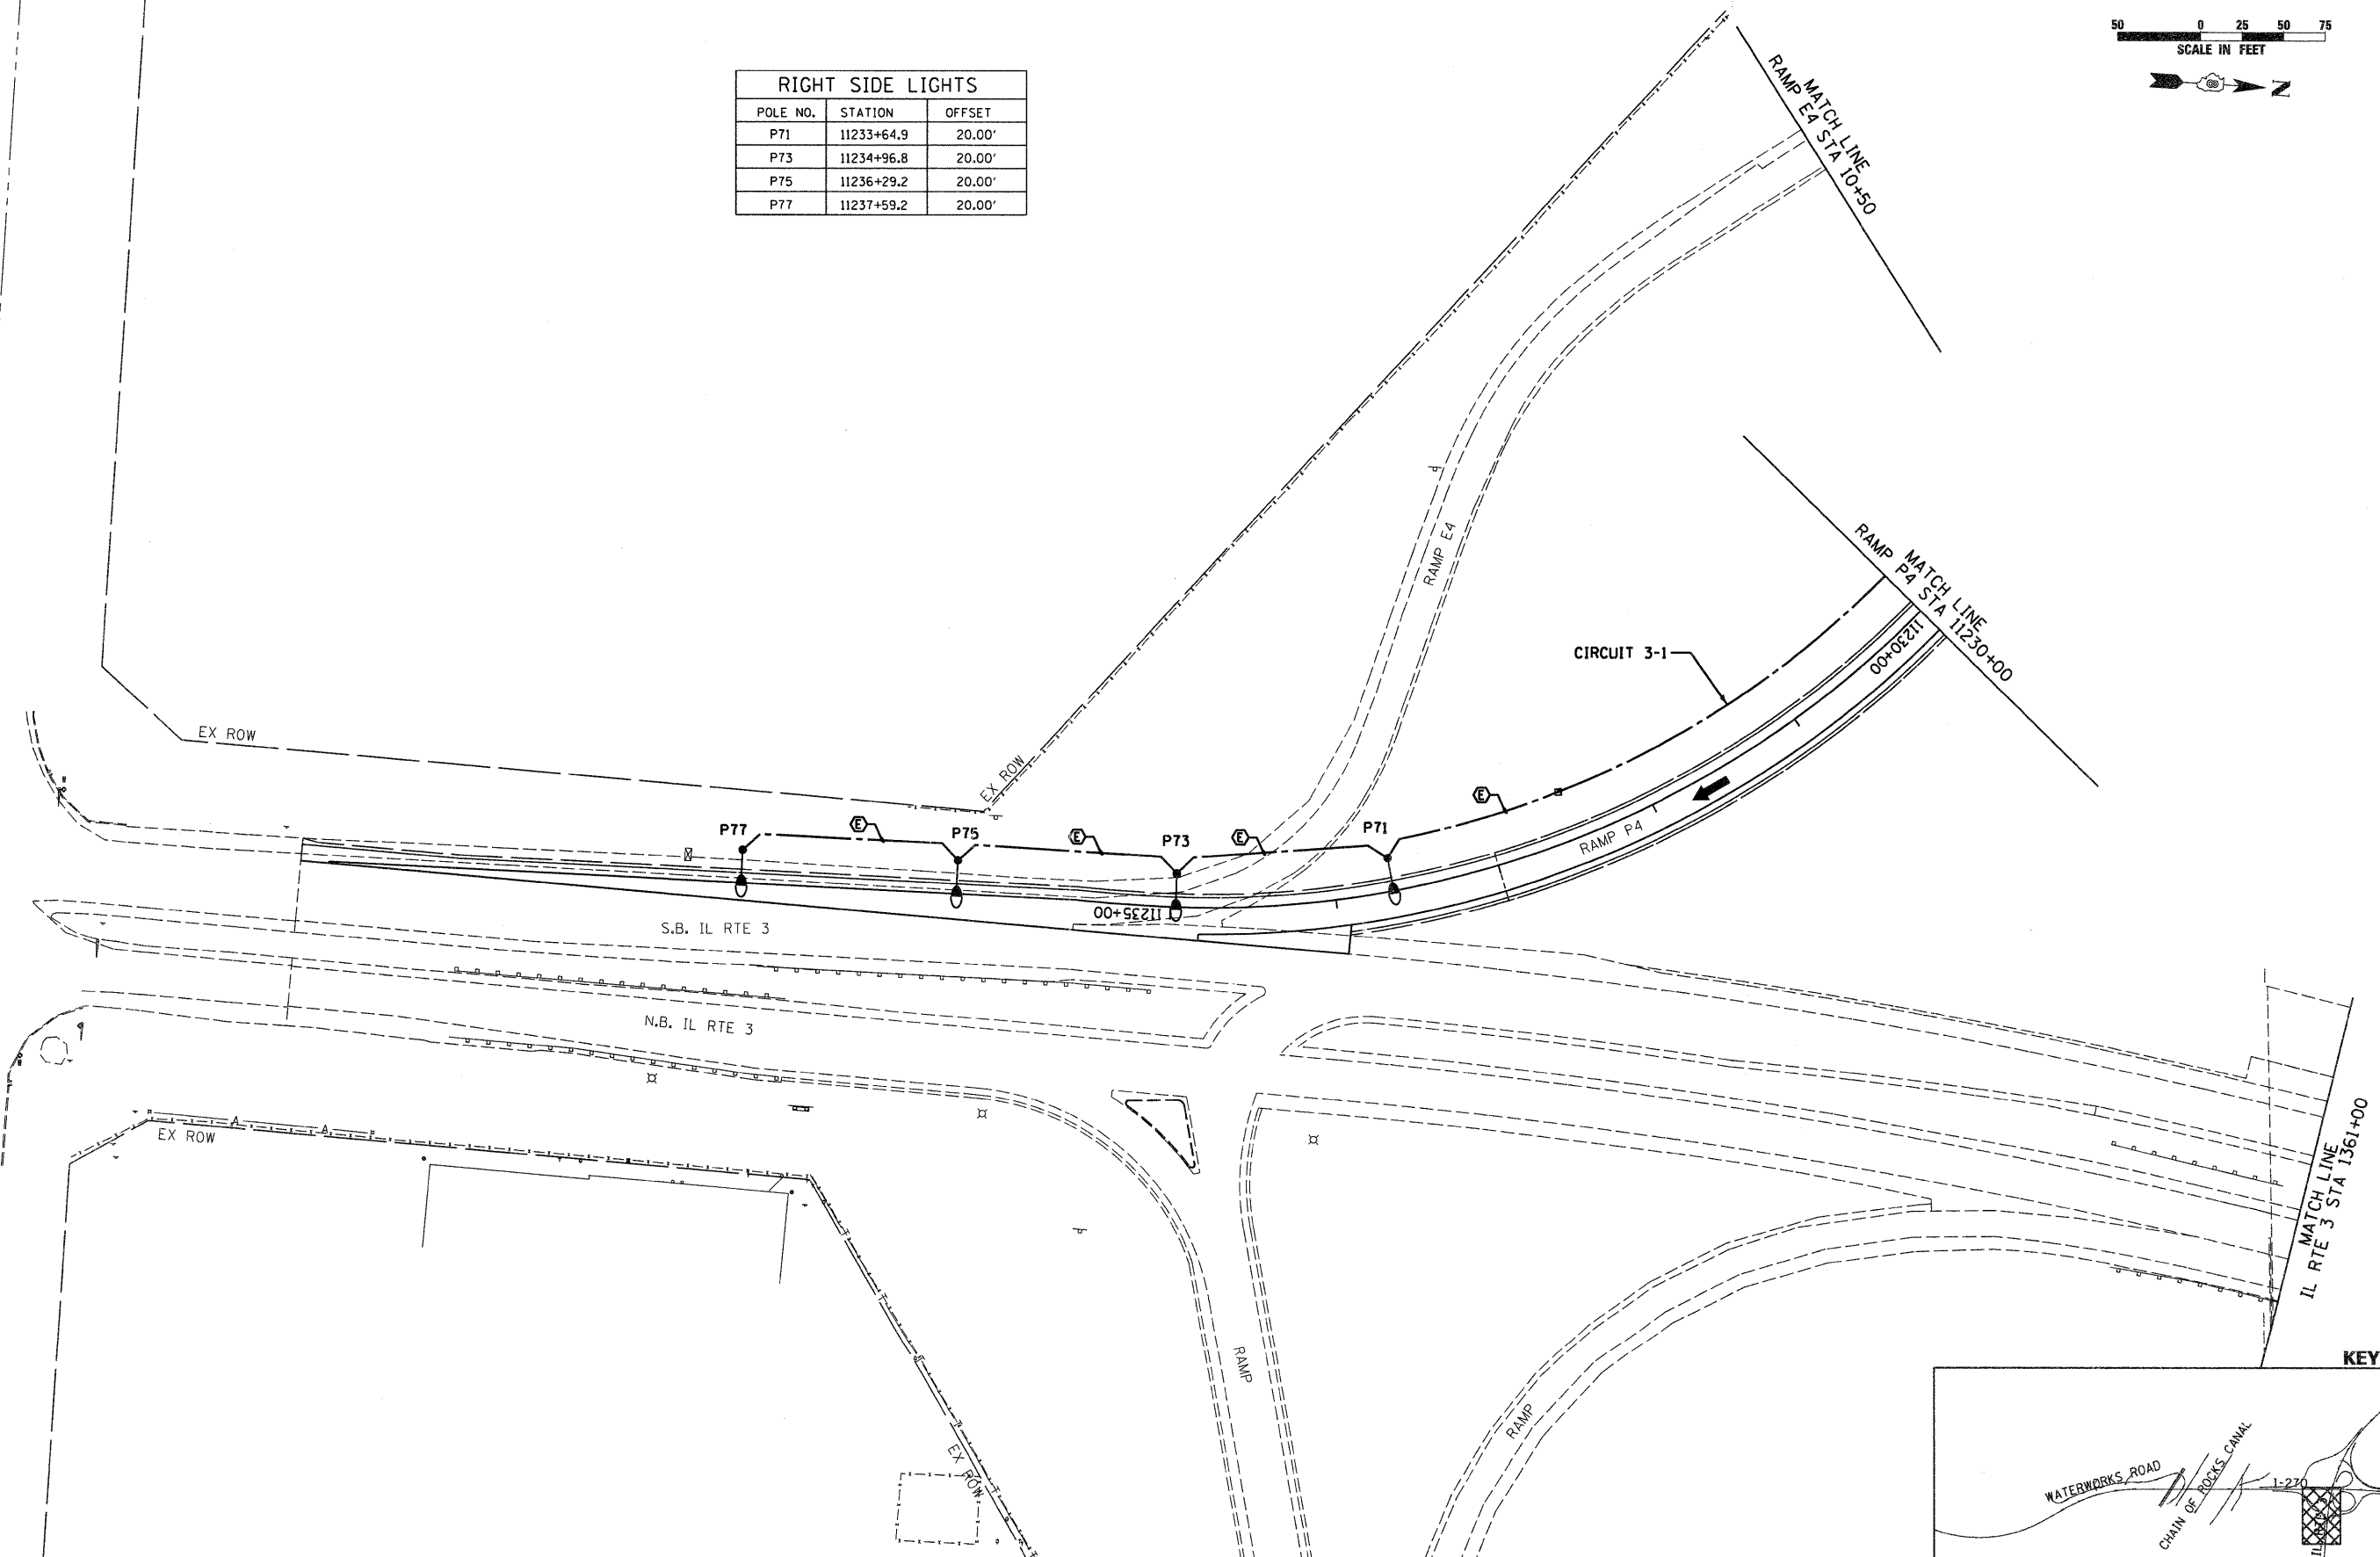

MATCH LINE
 IL RTE 3 STA 1361+00

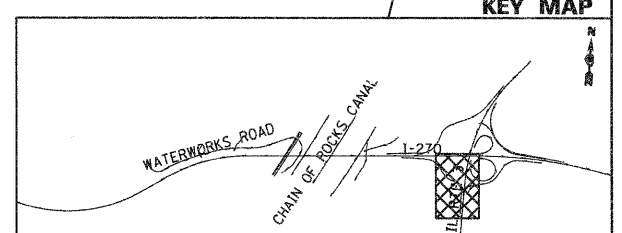

FILE NAME = *FILEL*	USER NAME = #USER#	DESIGNED FSM	REVISED -	STATE OF ILLINOIS DEPARTMENT OF TRANSPORTATION	HIGHWAY LIGHTING PLANS IL RTE 3			FAI	SECTION	COUNTY	TOTAL SHEETS	SHEET NO.
	PLOT SCALE = #SCALE#	DRAWN SCR	REVISED -		270	60-1B-1	MADISON	712	336			
	PLOT DATE = #DATE#	CHECKED AAB	REVISED -		SCALE: 1" = 50' SHEET NO. 8 OF 10 SHEETS STA. 1375+20 TO STA. 1361+00			CONTRACT NO. 76A91				
	DATE 3/18/11	REVISED -	ILLINOIS FED. AID PROJECT									

