


RIGHT SIDE LIGHTS		
POLE NO.	STATION	OFFSET
P70	21165+25.6	20.00'

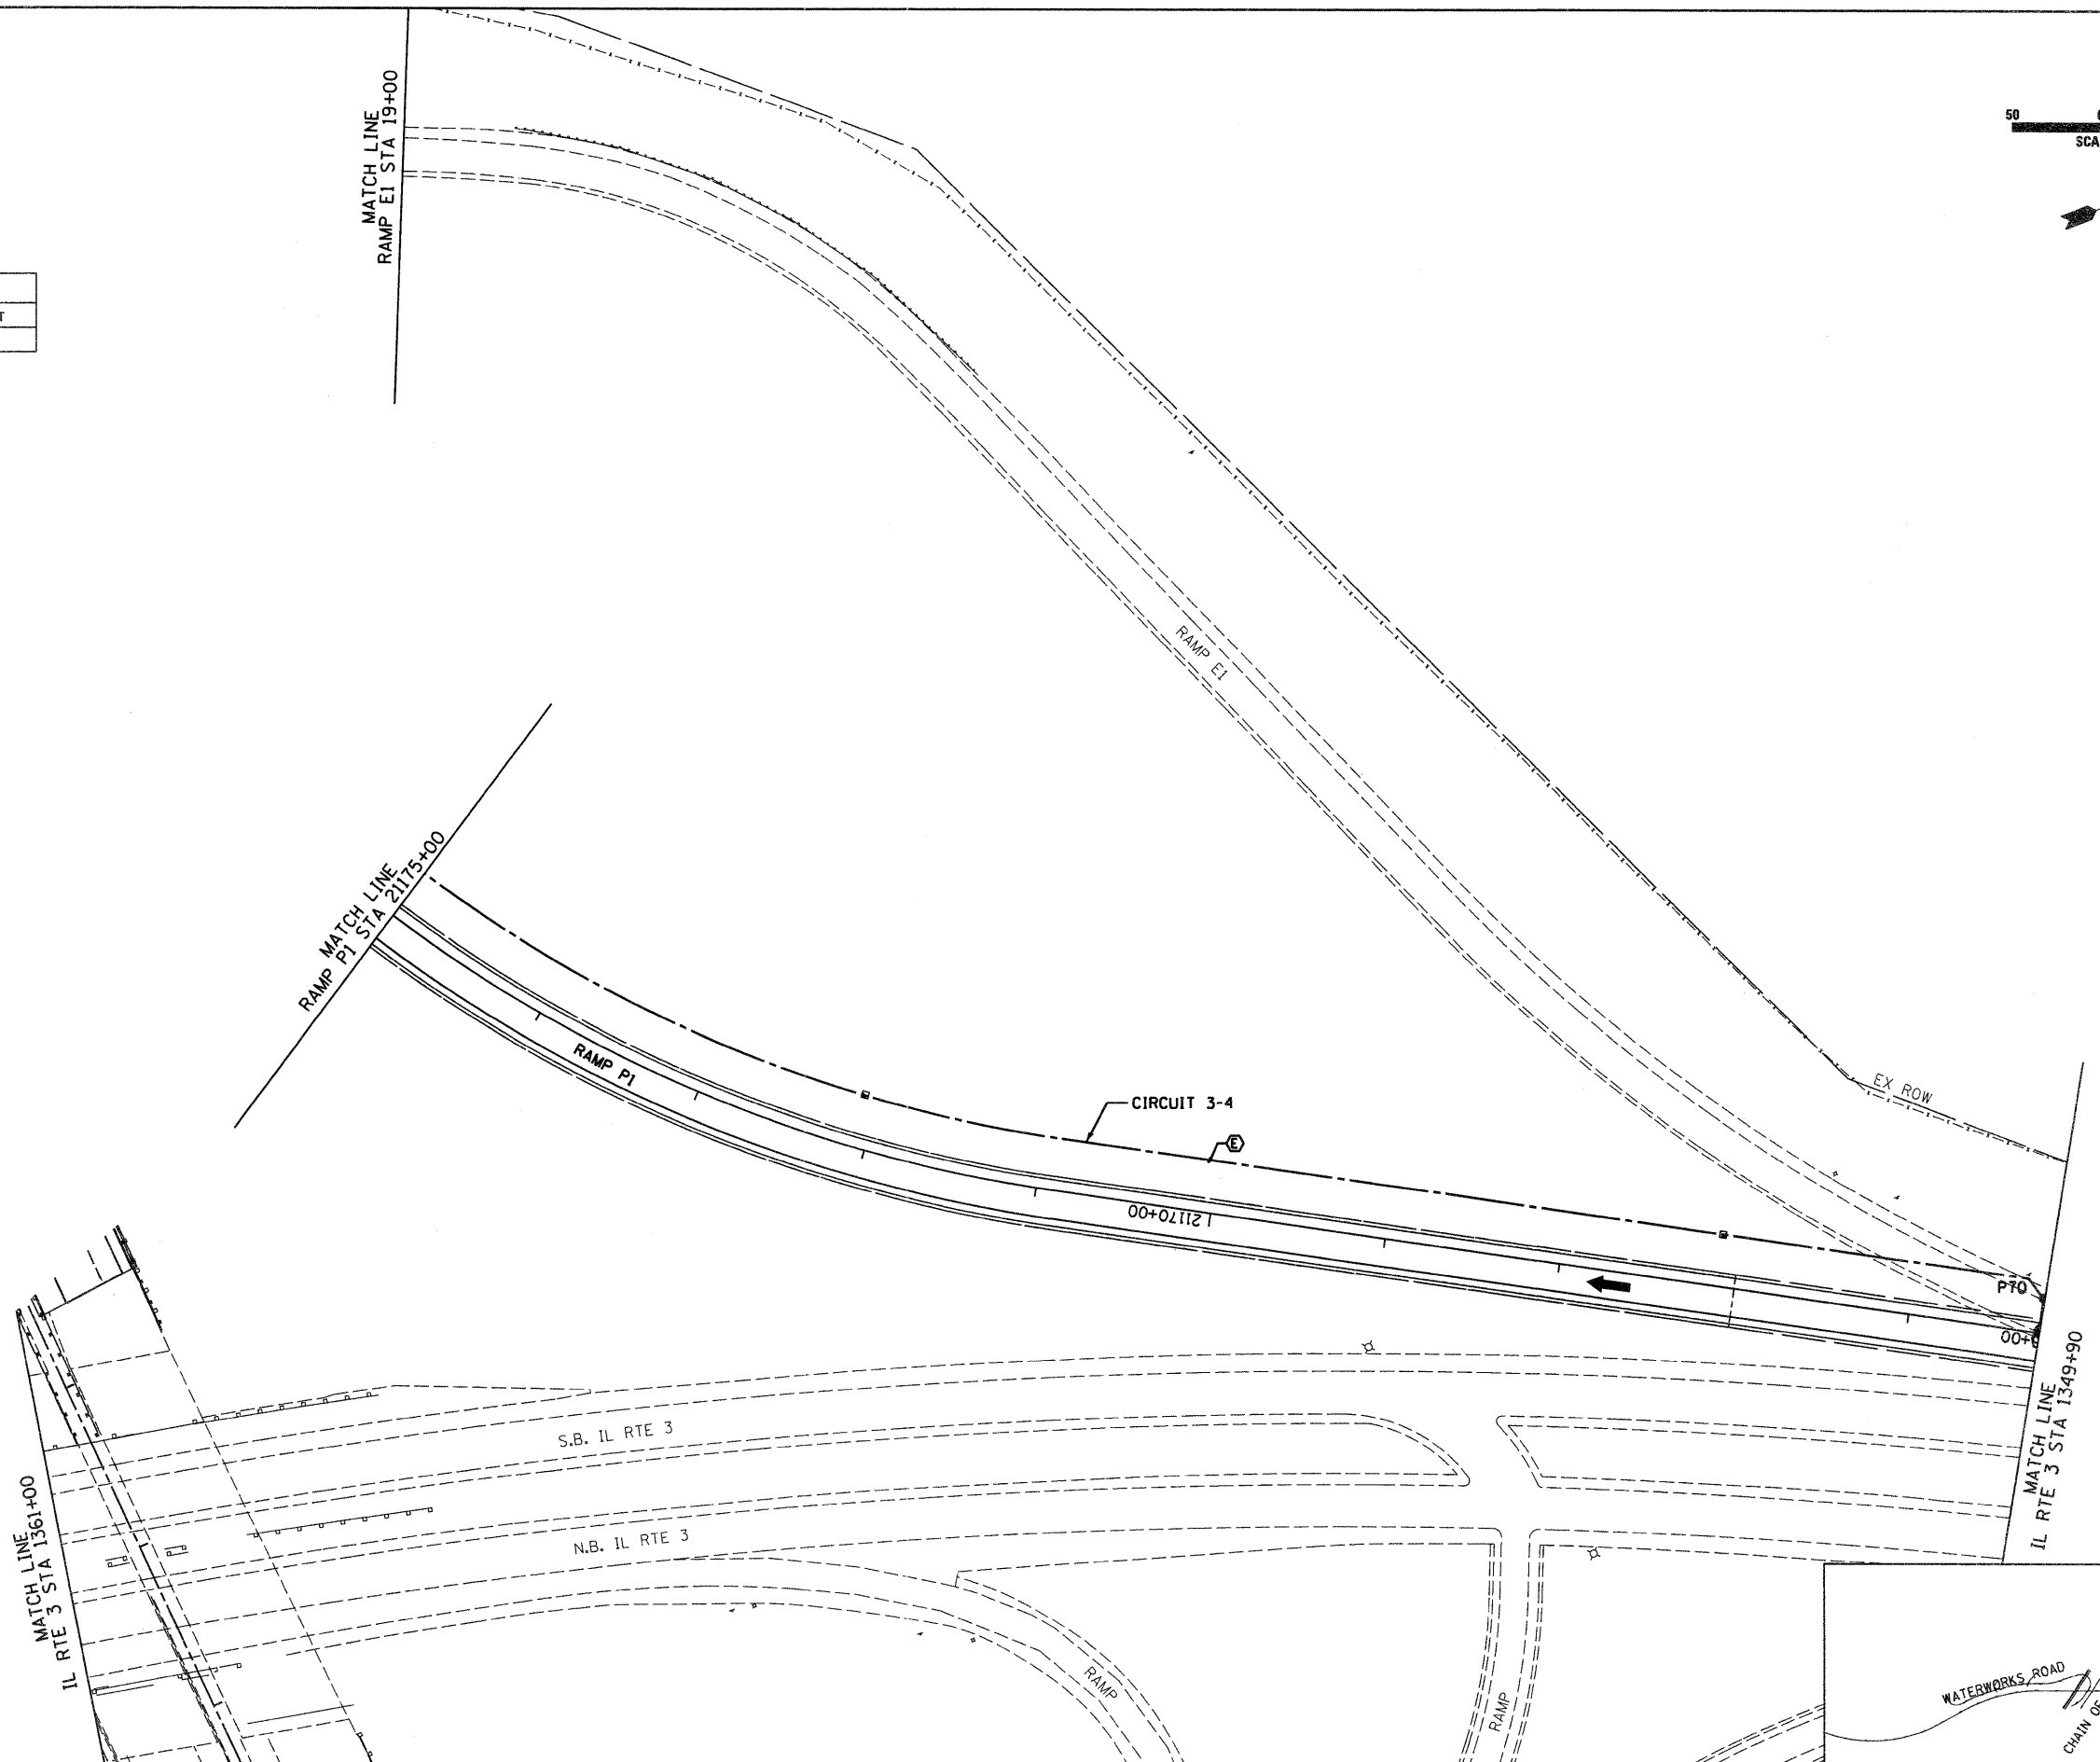


MATCH LINE
IL RTE 3 STA 1361+00

MATCH LINE
RAMP P1 STA 21175+00

MATCH LINE
RAMP E1 STA 19+00

MATCH LINE
IL RTE 3 STA 1349+90

KEY MAP

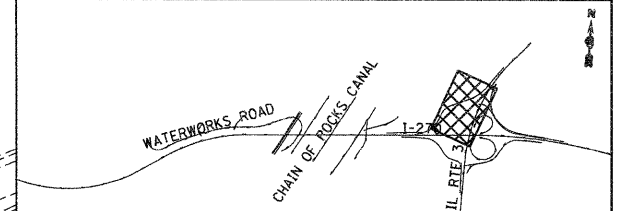

FILE NAME = \$FILEL\$		USER NAME = \$USER\$	DESIGNED FSM	REVISED -	STATE OF ILLINOIS DEPARTMENT OF TRANSPORTATION	HIGHWAY LIGHTING PLANS IL RTE 3		FAI	SECTION	COUNTY	TOTAL SHEETS	SHEET NO.
		PLOT SCALE = \$SCALE\$	DRAWN SCR	REVISED -				270	60-1B-1	MADISON	712	337
		PLOT DATE = \$DATE\$	CHECKED AAB	REVISED -				CONTRACT NO. 76A91		ILLINOIS FED. AID PROJECT		
			DATE 3/18/11	REVISED -		SCALE: 1" = 50'	SHEET NO. 9 OF 10 SHEETS	STA. 1361+00	TO STA. 1349+90			