 



NOTES:

1. SEE DRAWING ME-01 FOR ELECTRICAL SYMBOLS AND ABBREVIATIONS.
2. THE EXISTING ROADWAY LIGHTING SYSTEM, WHICH INCLUDES TEMPORARY LIGHTING, SHALL REMAIN IN OPERATION UNTIL THE PROPOSED ROADWAY LIGHTING SYSTEM HAS BEEN INSTALLED, ENERGIZED, TESTED AND ACCEPTED BY THE ENGINEER, UNLESS NOTED OTHERWISE.
3. COORDINATE ALL WORK WITH IDOT CONTRACT NOS. 76C49, 76C50, 76C51, 76C52, 76C53, 76C55, 76C75, AND 76C76.
4. TEMPORARY LIGHTING SHOWN ON THIS SHEET WAS INSTALLED IN CONTRACT 76C49.

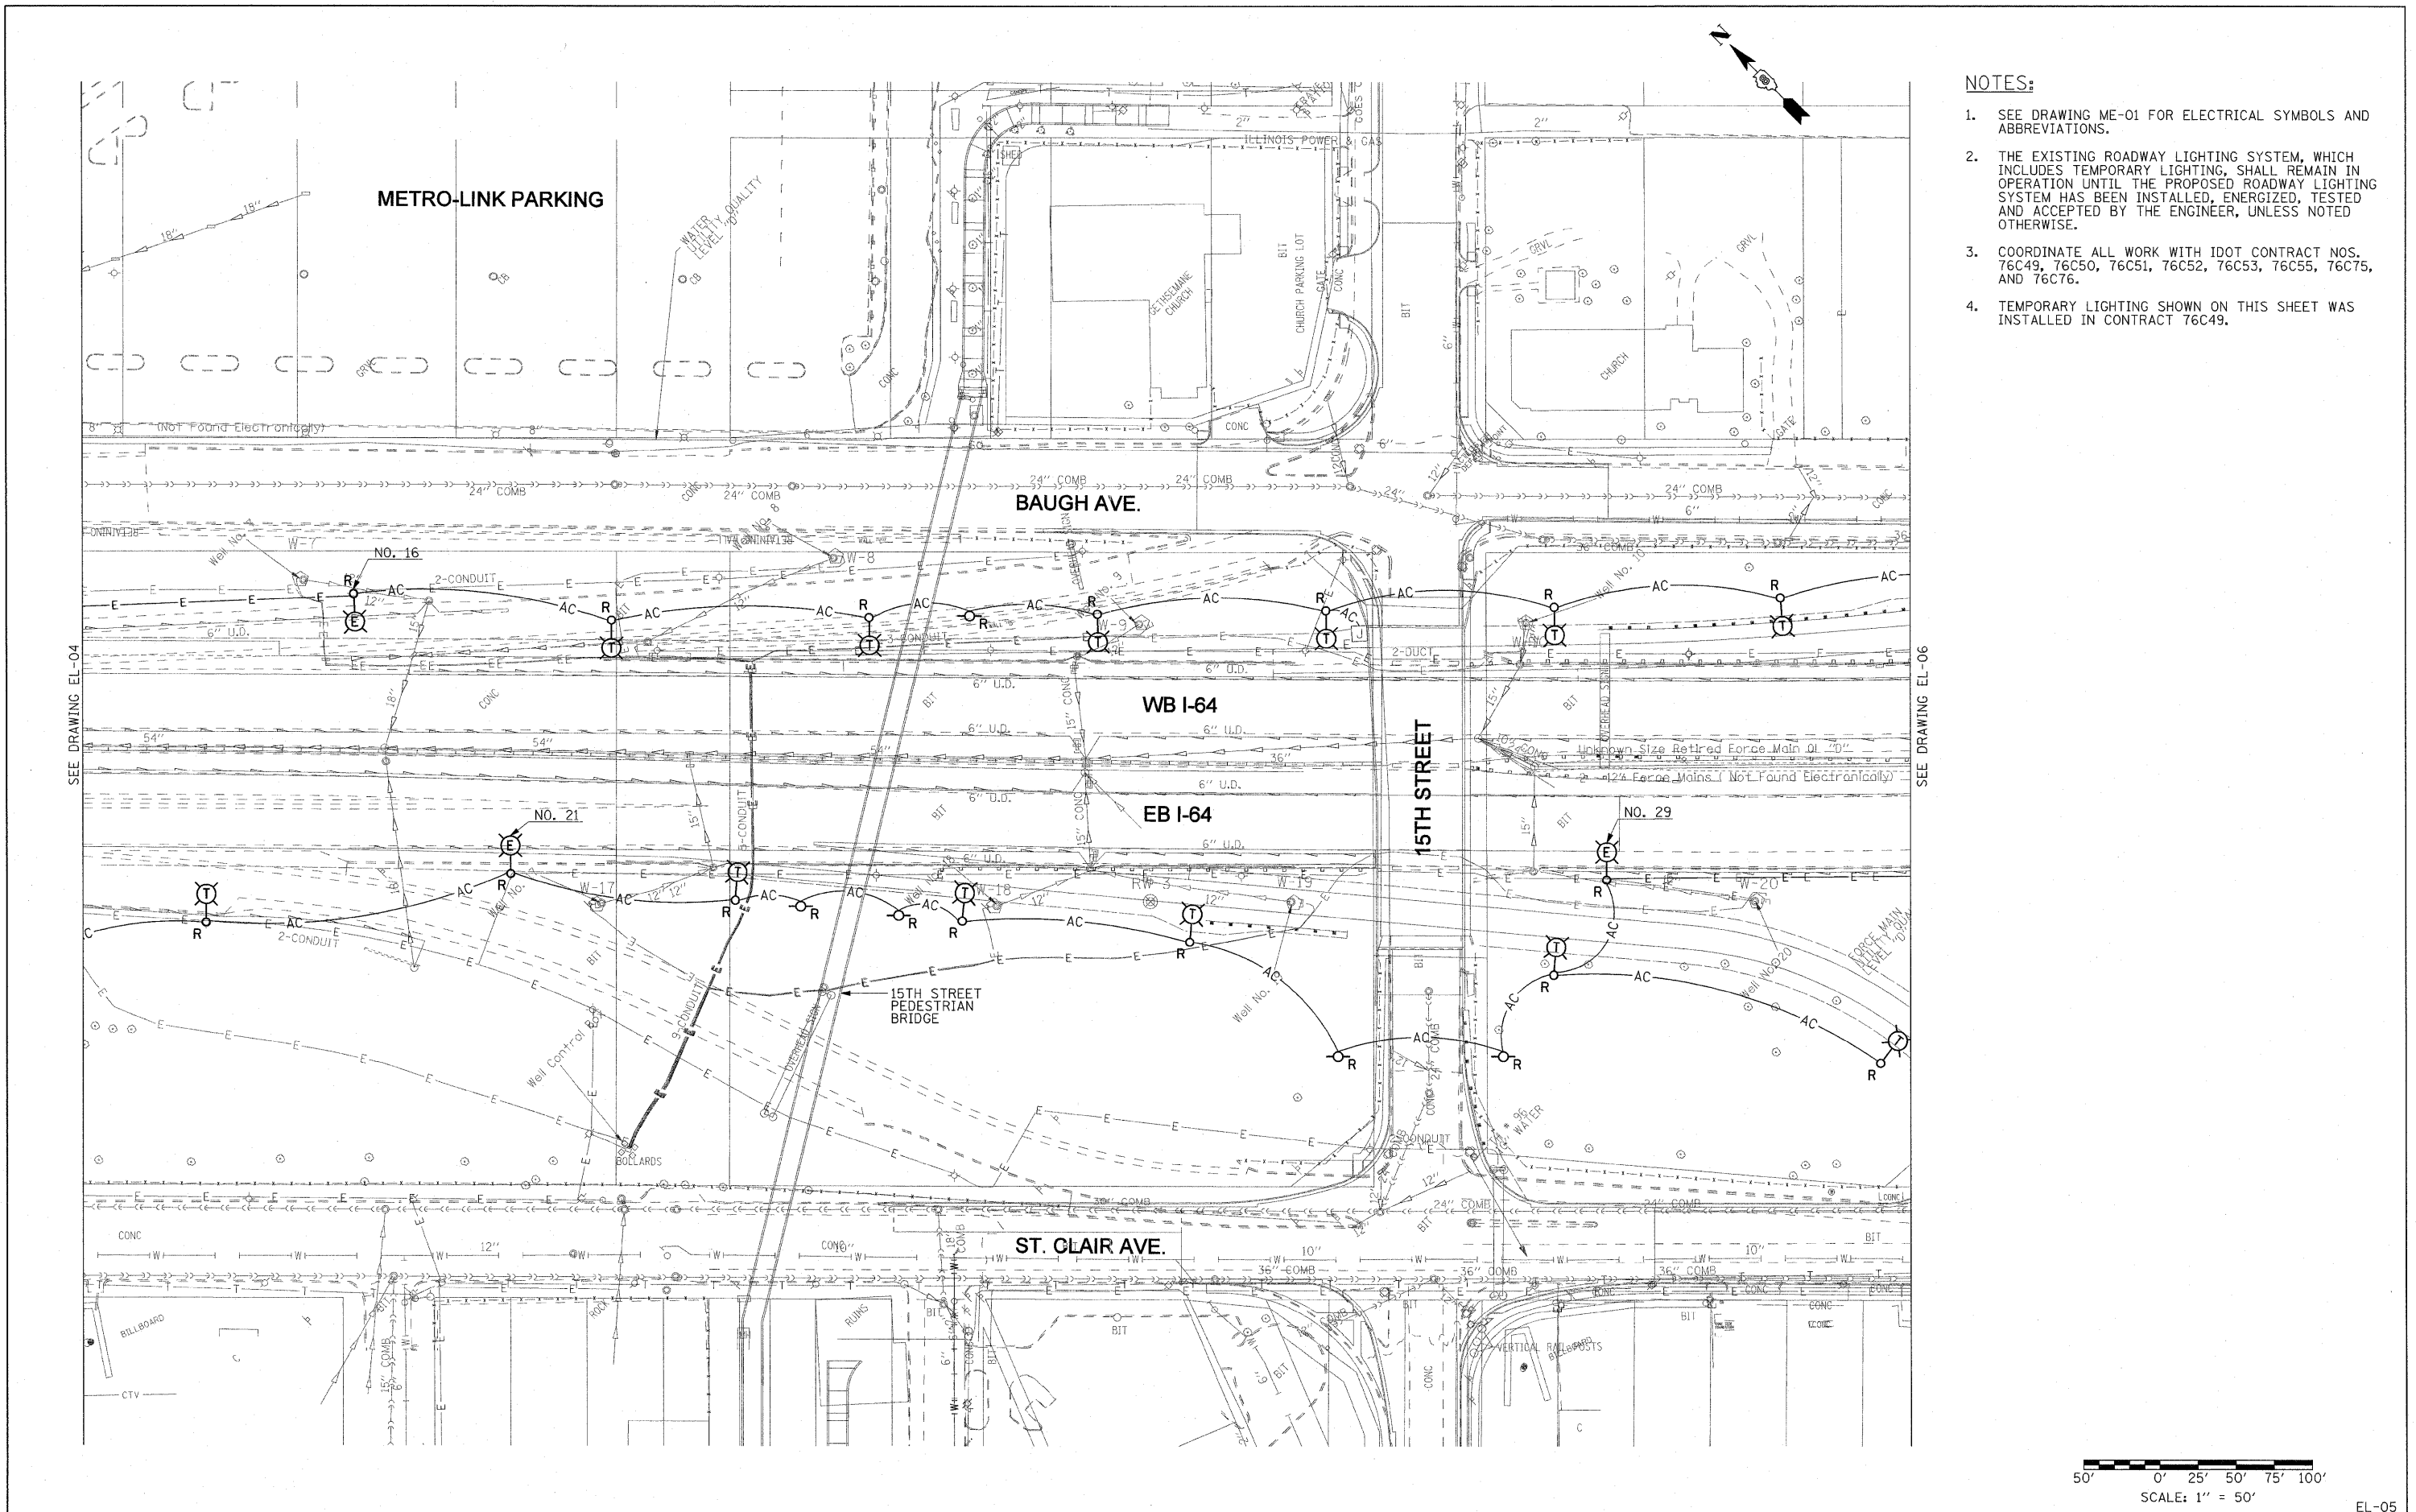

FILE NAME = #FILE#	USER NAME = lentsz	DESIGNED - WDS	REVISED -	STATE OF ILLINOIS DEPARTMENT OF TRANSPORTATION	LIGHTING PLANS EXISTING CONDITIONS AND DEMOLITION	F.A.I. RTE. 55/64	SECTION 82-1L	COUNTY ST. CLAIR	TOTAL SHEETS 60	SHEET NO. 41	
	PLOT SCALE = 50.0001' / IN.	CHECKED - JPC	REVISED -		SCALE: 1"=50'	SHEET NO. 4 OF 8 SHEETS	STA. 39+90.78 TO STA. 52+90.02	CONTRACT NO. 76C54			
	PLOT DATE = 1/3/2011	DATE - JANUARY 4, 2011	REVISED -		FED. ROAD DIST. NO. ILLINOIS FED. AID PROJECT						
EL-05											