


NOTES:

1. SEE DRAWING ME-01 FOR ELECTRICAL SYMBOLS AND ABBREVIATIONS.
2. SEE DRAWING ES-01 FOR HIGH MAST TOWER FOUNDATION SCHEDULE.
3. COORDINATE ALL WORK WITH IDOT CONTRACT NOS. 76C49, 76C50, 76C51, 76C52, 76C53, 76C55, 76C75, AND 76C76.
4. JUNCTION BOX AND CONDUIT MOUNTED ON BRIDGE STRUCTURE FOR THE POWER FEED TO THE PARAPET WALL MOUNTED CONVENTIONAL LIGHT POLES SHALL BE INSTALLED AS SHOWN ON DRAWING ME-04
5. JUNCTION BOX MOUNTED TO BRIDGE STRUCTURE FOR UNDERPASS LIGHTING POWER FEED SHALL BE INSTALLED AS SHOWN ON IDOT STANDARD LGT019. SEE DRAWING UL-03 FOR THE UNDERPASS LIGHTING PLANS.
6. PROVIDE NEW POWER FEED TO EXISTING SIGN LIGHTING.
7. 2" PVC RACEWAY EMBEDDED IN PARAPET WALL BY OTHERS.
8. INTERCEPT EXISTING CONDUIT STUB OUTS FROM PARAPET WALL AND PROVIDE CONDUIT AND JUNCTION BOX TO ROUTE THE LIGHTING CIRCUIT DOWN THE STRUCTURAL PIER INTO GRADE AS SHOWN.
9. THE LOCATIONS OF THE PROPOSED CABLES, CONDUITS AND SLEEVES SHOW ON THIS DRAWING ARE DIAGRAMMATIC ONLY. IT IS THE CONTRACTOR'S RESPONSIBILITY TO COORDINATE ALL WORK WITH OTHER CONCURRENT IDOT CONTRACTS SO THAT THE PROPOSED CABLES, CONDUITS AND SLEEVES SHOWN ON THIS DRAWING ARE INSTALLED IN A LOCATION THAT DOES NOT INTERFERE OR CONFLICT WITH EXISTING UTILITIES AND WORK DONE IN OTHER CONCURRENT IDOT CONTRACTS.
10. INSTALL PARALLEL CABLES IN A COMMON TRENCH.

MATCH LINE STA. 63+97.00
RAMP 70E 55N BASELINE
SEE DRAWING RL-03

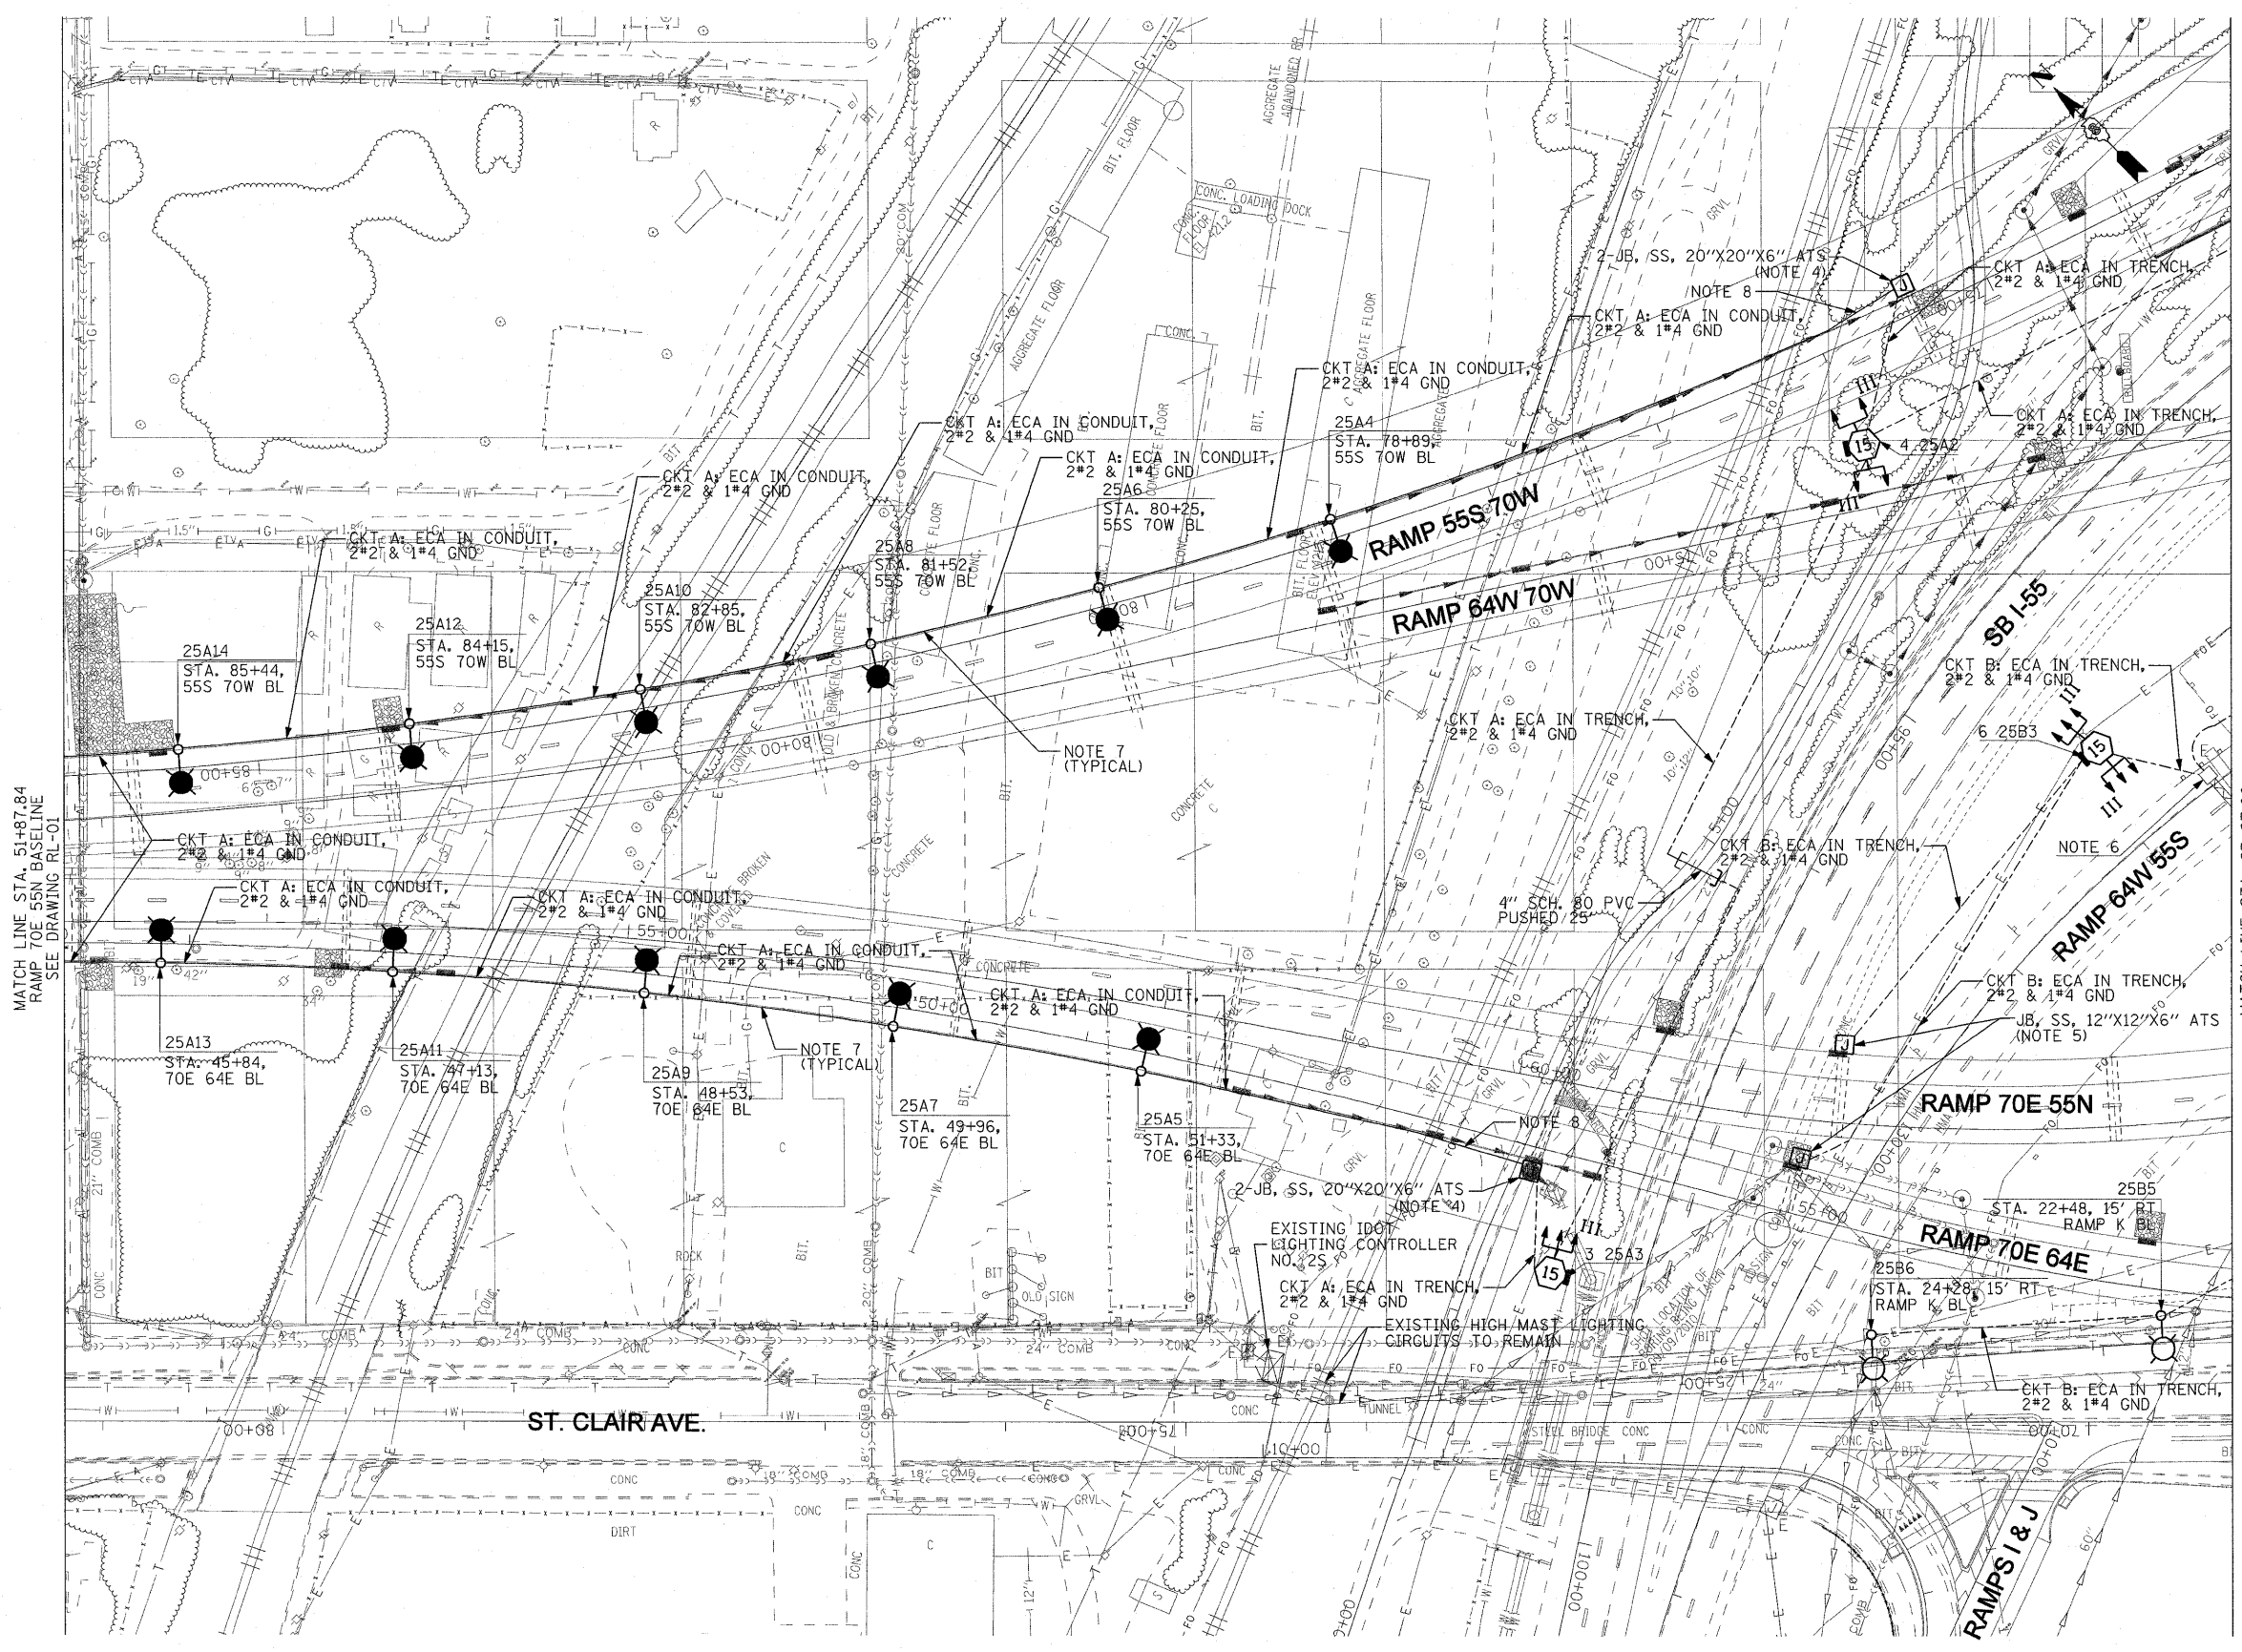

FILE NAME =
\$FILE#

USER NAME = jantzt
PLOT SCALE = 50.0001' / IN.
PLOT DATE = 12/28/2010

DESIGNED - WDS
DRAWN - TL
CHECKED - JPC
DATE - JANUARY 4, 2011

REVISED -
REVISED -
REVISED -
REVISED -

**STATE OF ILLINOIS
DEPARTMENT OF TRANSPORTATION**

**LIGHTING PLANS
PROPOSED WORK**

SCALE: 1"=50' SHEET NO. 2 OF 8 SHEETS STA. 51+87.84 TO STA. 65+97.00

F.A.I. RTE.	SECTION	COUNTY	TOTAL SHEETS	SHEET NO.
55/64	82-1L	ST. CLAIR	60	47
CONTRACT NO. 76C54				
FED. ROAD DIST. NO. ILLINOIS FED. AID PROJECT				