 



NOTES:

1. SEE DRAWING ME-01 FOR ELECTRICAL SYMBOLS AND ABBREVIATIONS.
2. SEE DRAWING ES-01 FOR HIGH MAST TOWER FOUNDATION SCHEDULE.
3. COORDINATE ALL WORK WITH IDOT CONTRACT NOS. 76C49, 76C50, 76C51, 76C52, 76C53, 76C55, 76C75, AND 76C76.
4. THE LOCATIONS OF THE PROPOSED CABLES, CONDUITS AND SLEEVES SHOWN ON THIS DRAWING ARE DIAGRAMMATIC ONLY. IT IS THE CONTRACTOR'S RESPONSIBILITY TO COORDINATE ALL WORK WITH OTHER CONCURRENT IDOT CONTRACTS SO THAT THE PROPOSED CABLES, CONDUITS AND SLEEVES SHOWN ON THIS DRAWING ARE INSTALLED IN A LOCATION THAT DOES NOT INTERFERE OR CONFLICT WITH EXISTING UTILITIES AND WORK DONE IN OTHER CONCURRENT IDOT CONTRACTS.
5. INSTALL PARALLEL CABLES IN A COMMON TRENCH.

MATCH LINE STA. 51+90.02
EB I-64 BASELINE
SEE DRAWING RL-05

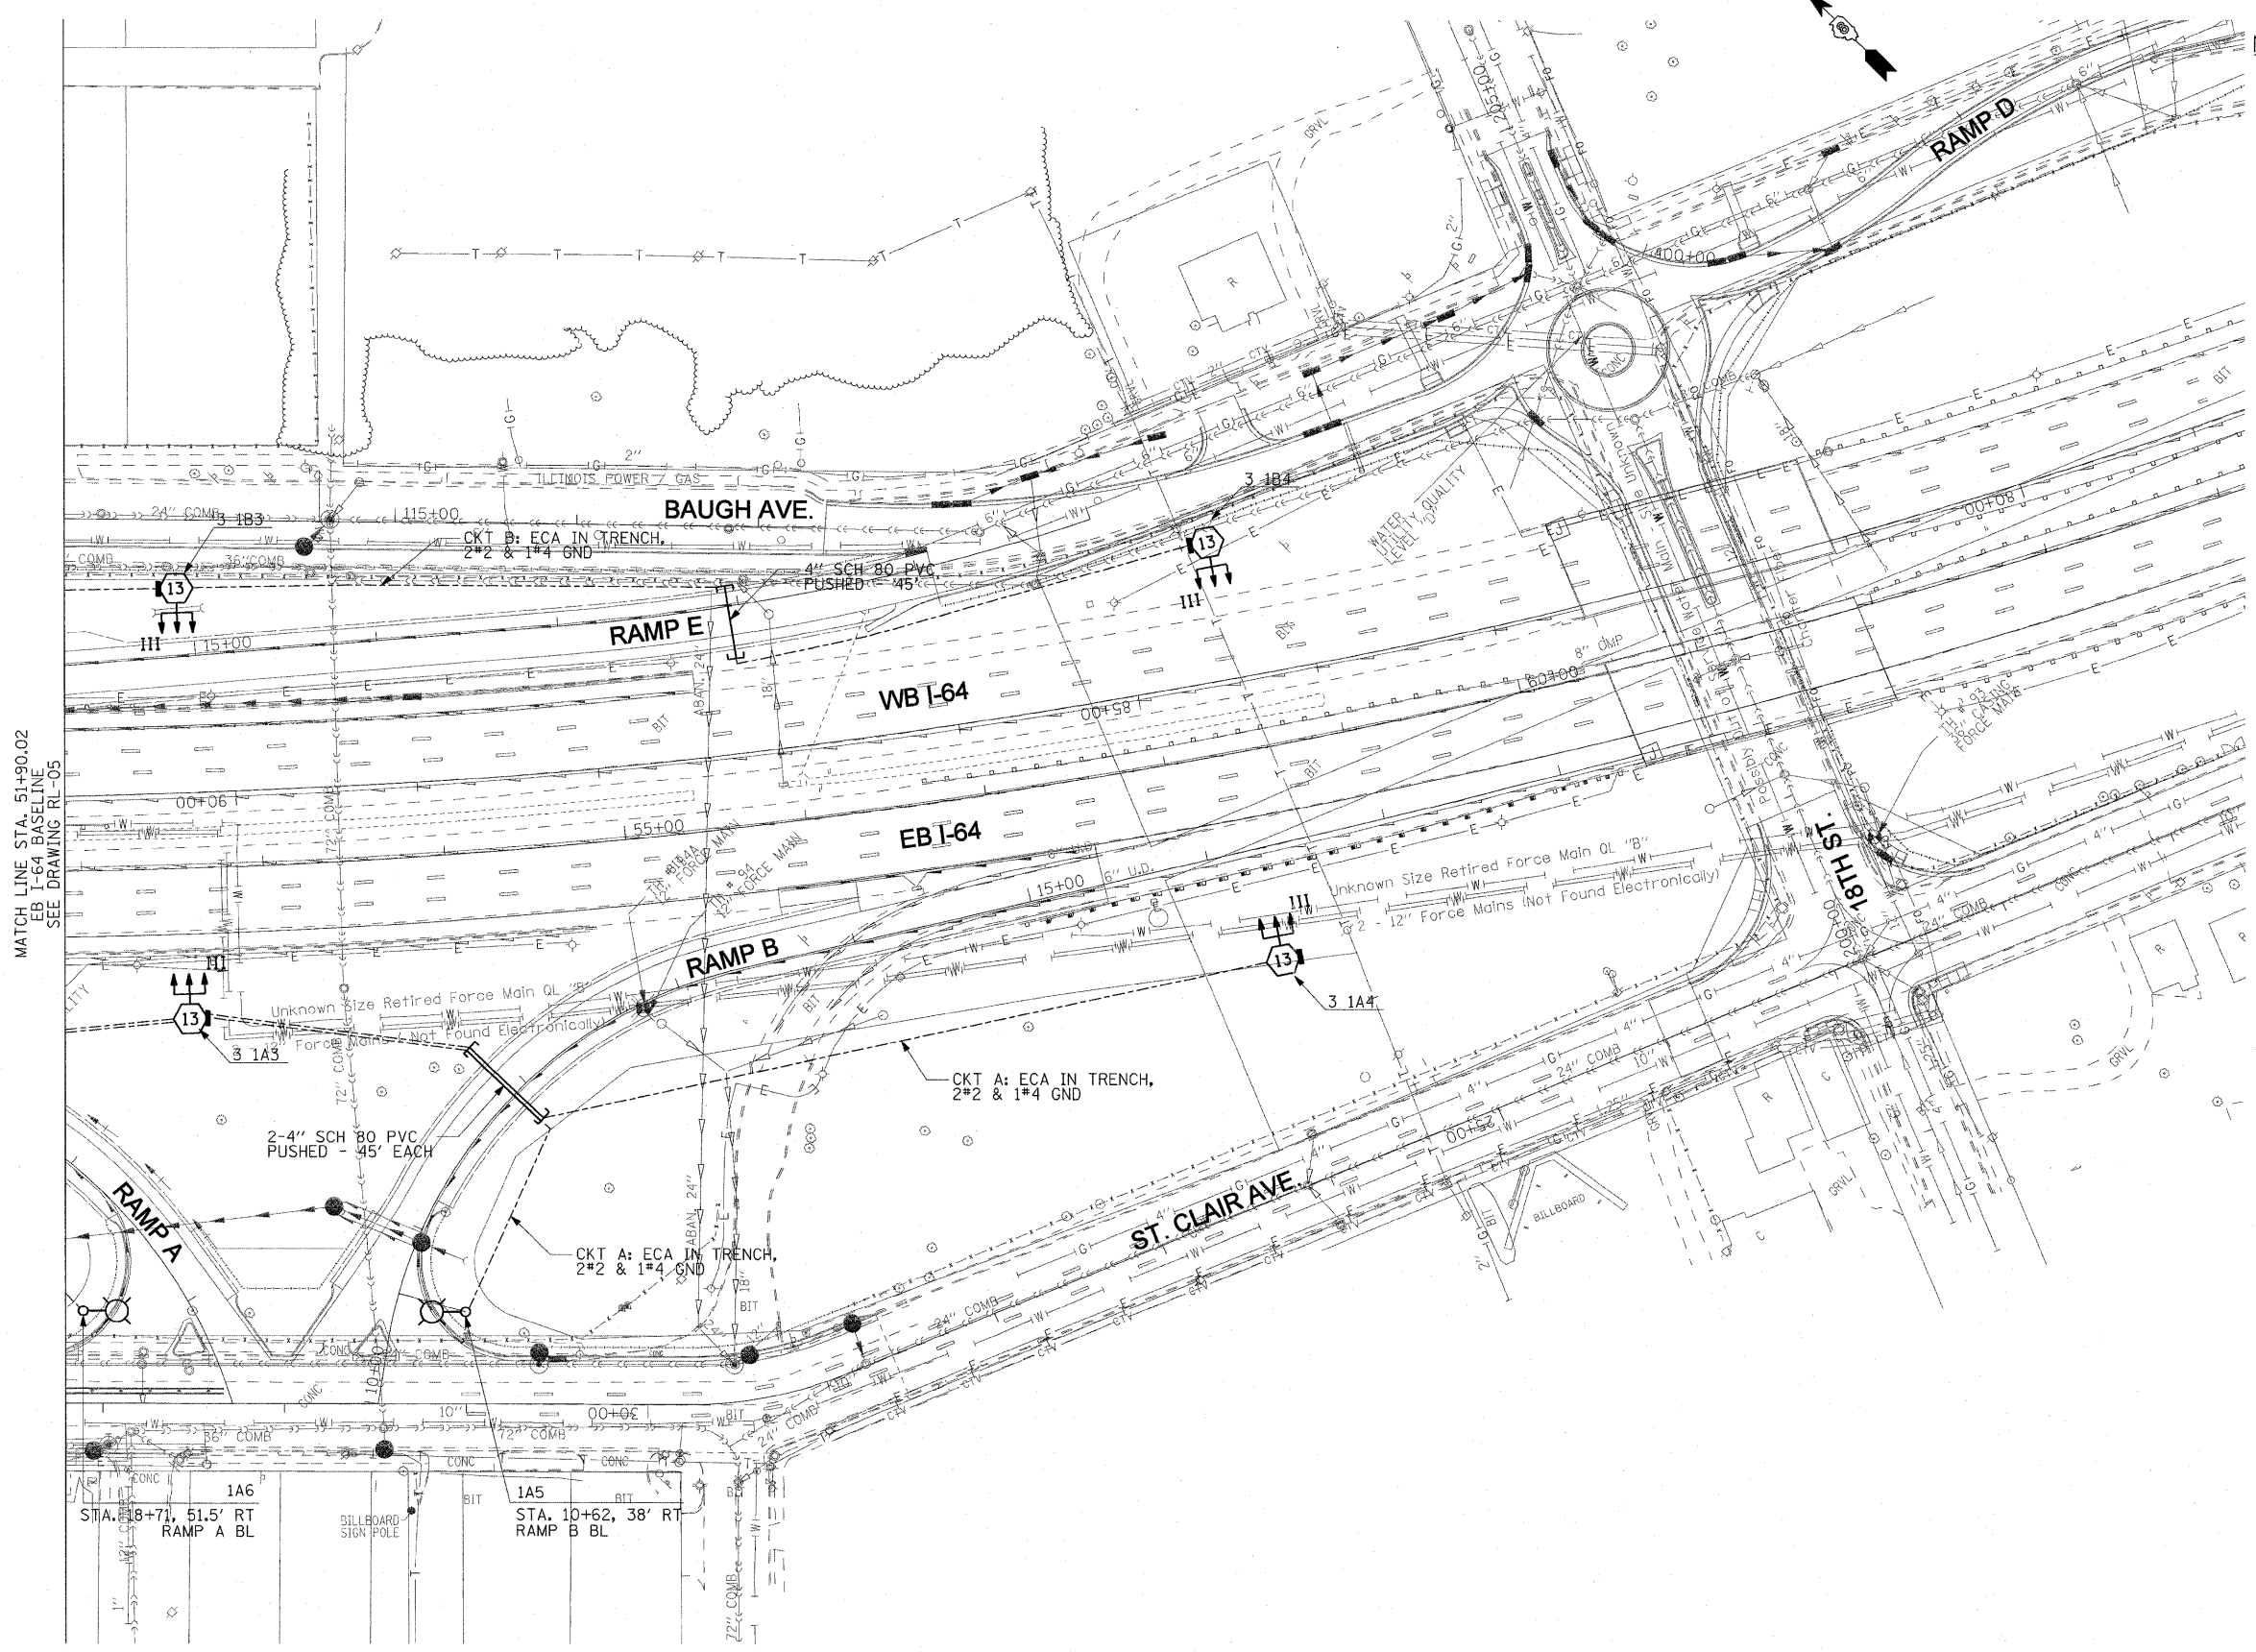

RL-06

FILE NAME = #FILE#	USER NAME = Jentzt	DESIGNED - WDS	REVISED -	STATE OF ILLINOIS DEPARTMENT OF TRANSPORTATION	LIGHTING PLANS PROPOSED WORK	F.A.I. RTE. 55/64	SECTION 82-1L	COUNTY ST. CLAIR	TOTAL SHEETS 60	SHEET NO. 51	
	PLOT SCALE = 50.0001' / IN.	DRAWN - TL	REVISED -			SCALE: 1"=50'	SHEET NO. 6 OF 8 SHEETS	STA. 52+90.02 TO STA.	CONTRACT NO. 76C54		
	PLOT DATE = 12/28/2010	CHECKED - JPC	REVISED -						FED. ROAD DIST. NO. ILLINOIS FED. AID PROJECT		
		DATE - JANUARY 4, 2011	REVISED -								