 



**NOTES:**

1. SEE DRAWING ME-01 FOR ELECTRICAL SYMBOLS AND ABBREVIATIONS.
2. SEE DRAWING ES-01 FOR HIGH MAST TOWER FOUNDATION SCHEDULE.
3. COORDINATE ALL WORK WITH IDOT CONTRACT NOS. 76C49, 76C50, 76C51, 76C52, 76C53, 76C55, 76C75, AND 76C76.
4. PROVIDE IDENTIFICATION DECALS FOR EXISTING LIGHTING UNITS ON RAMP O. DECAL INSTALLATION WILL BE PAID FOR UNDER THE "LIGHTING UNIT IDENTIFICATION DECAL" PAY ITEM.
5. PROVIDE NEW POWER FEED TO THE EXISTING RAMP O LIGHTING UNITS
6. THE LOCATIONS OF THE PROPOSED CABLES, CONDUITS AND SLEEVES SHOW ON THIS DRAWING ARE DIAGRAMMATIC ONLY. IT IS THE CONTRACTOR'S RESPONSIBILITY TO COORDINATE ALL WORK WITH OTHER CONCURRENT IDOT CONTRACTS SO THAT THE PROPOSED CABLES, CONDUITS AND SLEEVES SHOWN ON THIS DRAWING ARE INSTALLED IN A LOCATION THAT DOES NOT INTERFERE OR CONFLICT WITH EXISTING UTILITIES AND WORK DONE IN OTHER CONCURRENT IDOT CONTRACTS.
7. INSTALL PARALLEL CABLES IN A COMMON TRENCH

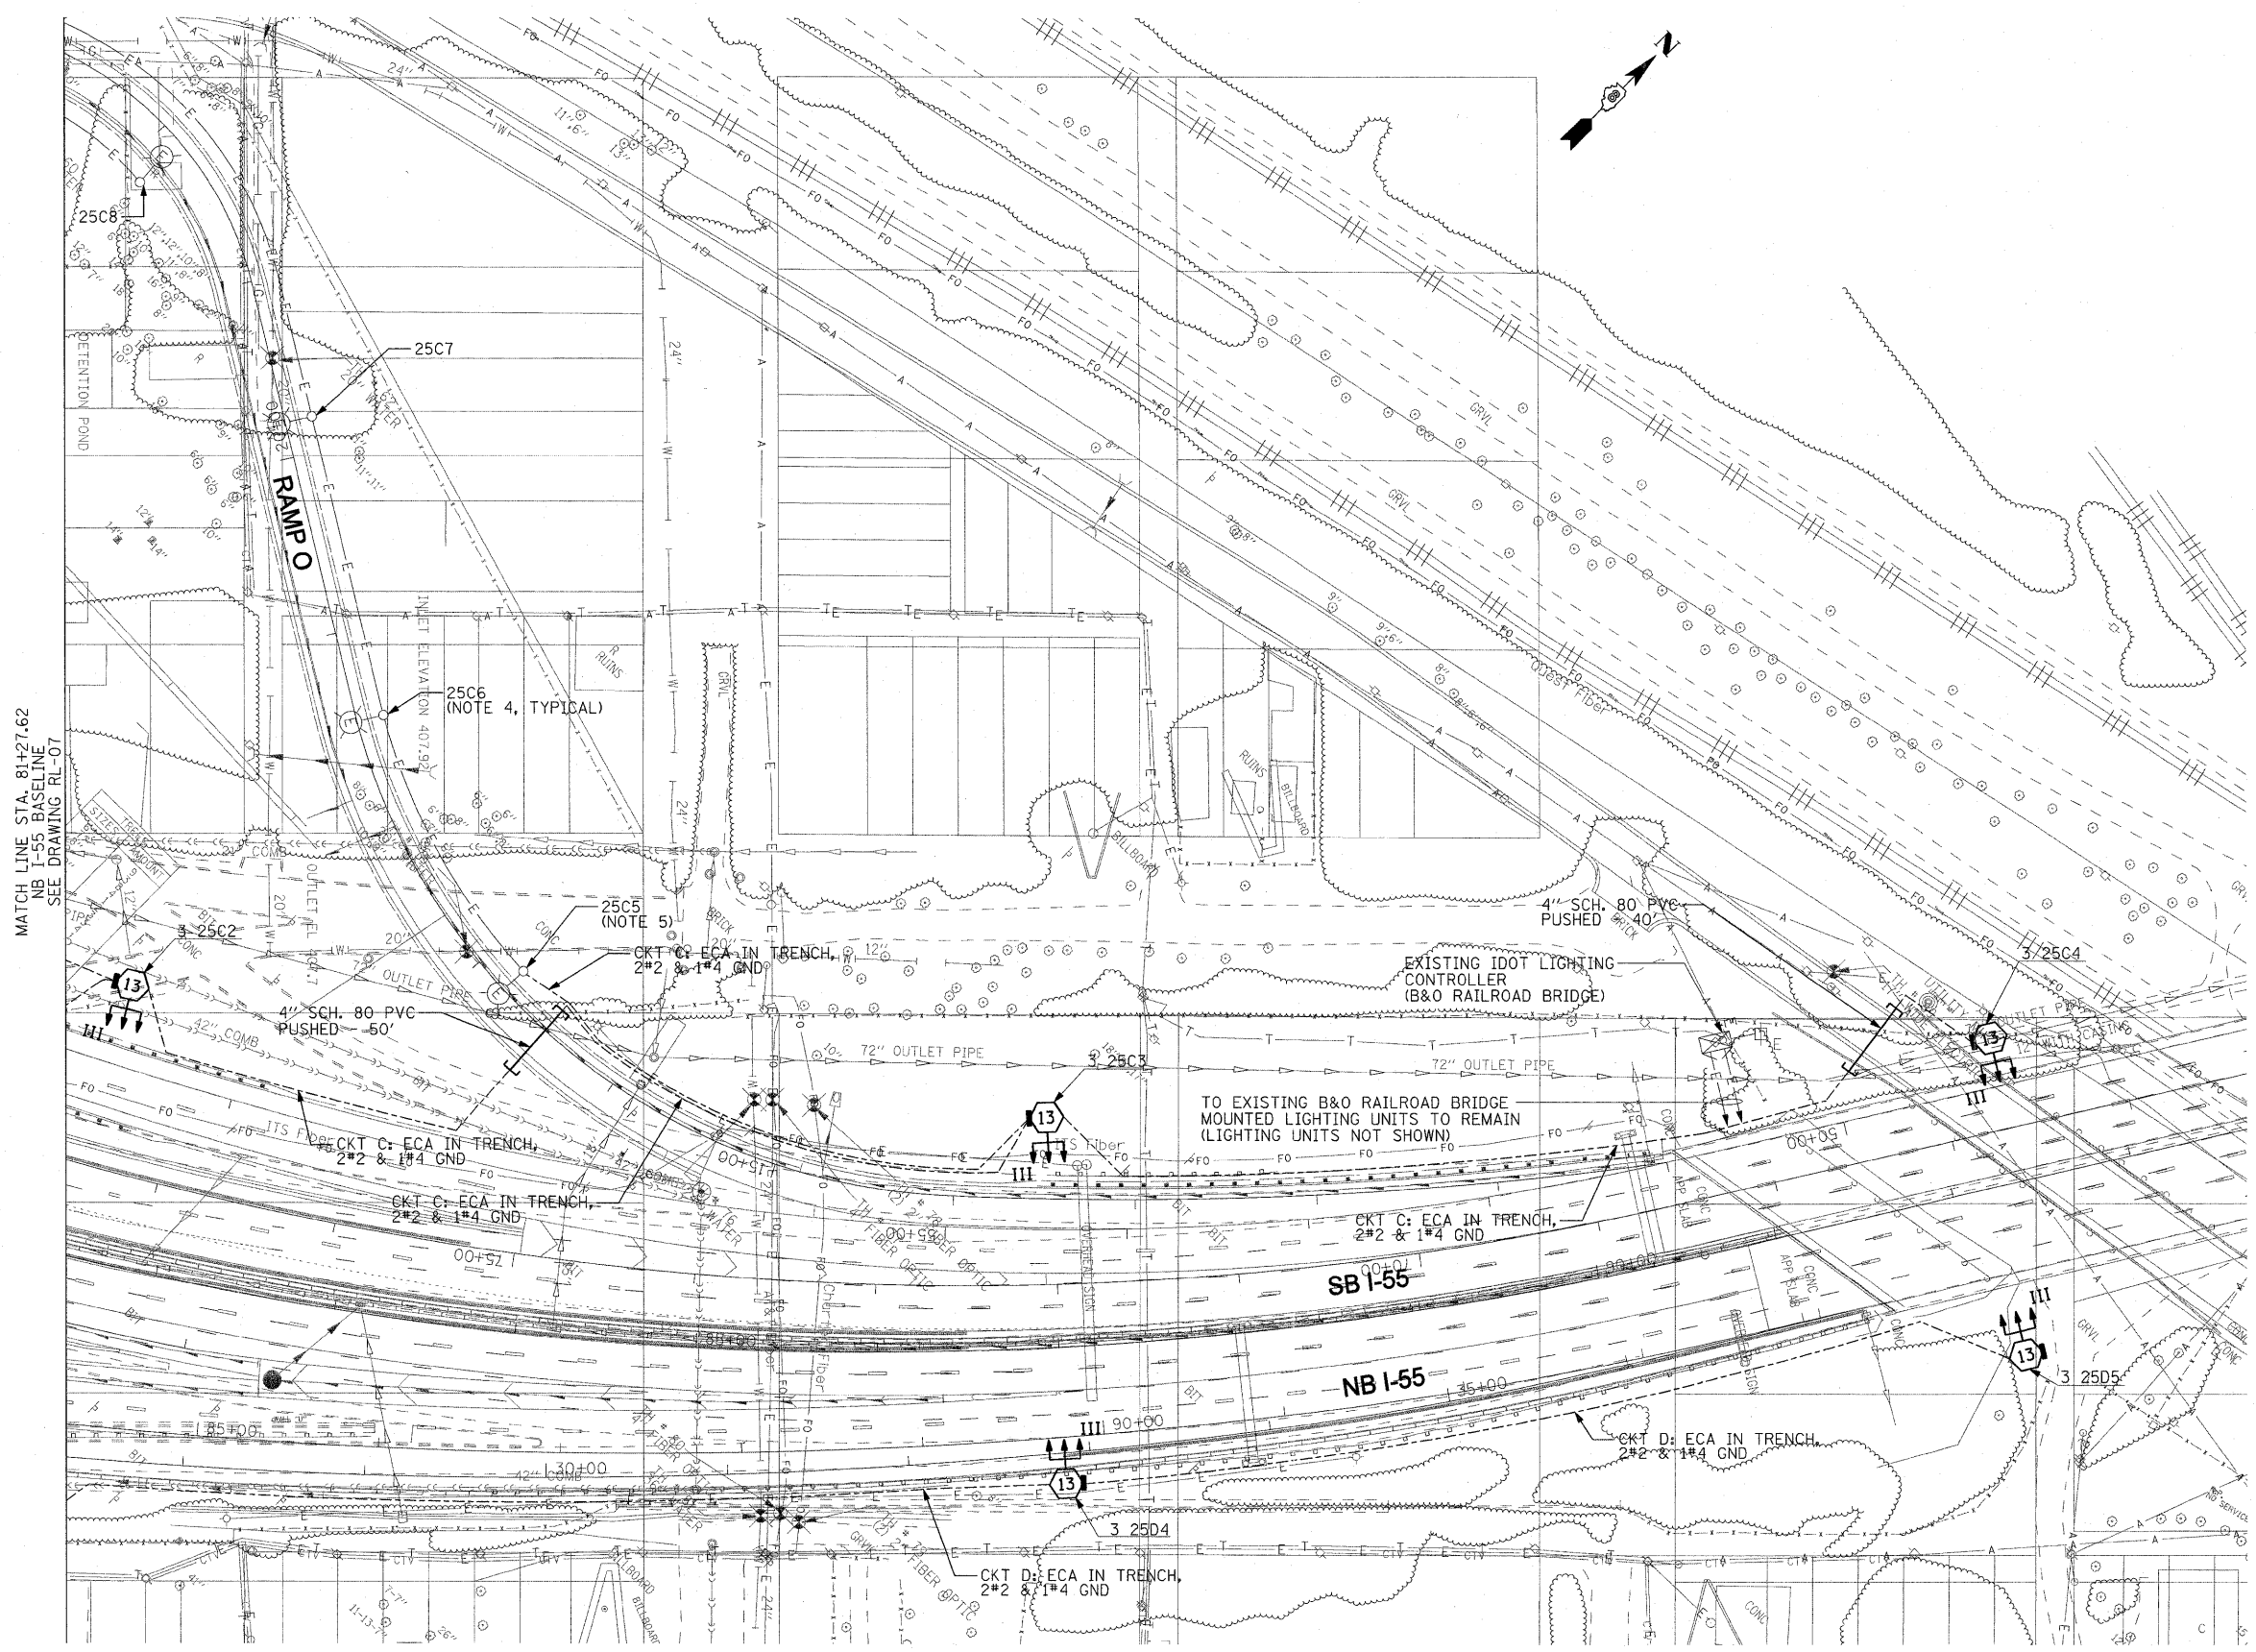

RL-08

|                       |                             |                        |           |   |   |                         |                         |   |                       |                    |  |
|-----------------------|-----------------------------|------------------------|-----------|---|---|-------------------------|-------------------------|---|-----------------------|--------------------|--|
| FILE NAME =<br>#FILE# | USER NAME = lantz           | DESIGNED - WDS         | REVISED - | <b>STATE OF ILLINOIS<br/>DEPARTMENT OF TRANSPORTATION</b> | <b>LIGHTING PLANS<br/>PROPOSED WORK</b> | F.A.I.<br>RTE.<br>55/64 | SECTION<br>82-1L        | COUNTY<br>ST. CLAIR                           | TOTAL<br>SHEETS<br>60 | SHEET<br>NO.<br>53 |  |
|                       | PLOT SCALE = 50.0000' / IN. | CHECKED - JPC          | REVISED - |   |   | SCALE: 1"=50'           | SHEET NO. 8 OF 8 SHEETS | STA. 84+27.62 TO STA.                         | CONTRACT NO. 76C54    |                    |  |
|                       | PLOT DATE = 12/28/2010      | DATE - JANUARY 4, 2011 | REVISED - |   |   |                         |                         | FED. ROAD DIST. NO. ILLINOIS FED. AID PROJECT |                       |                    |  |
| RL-08                 |                             |                        |           |   |   |                         |                         |   |                       |                    |  |