


EXISTING PLANS AND DEMOLITION
NOTE 8

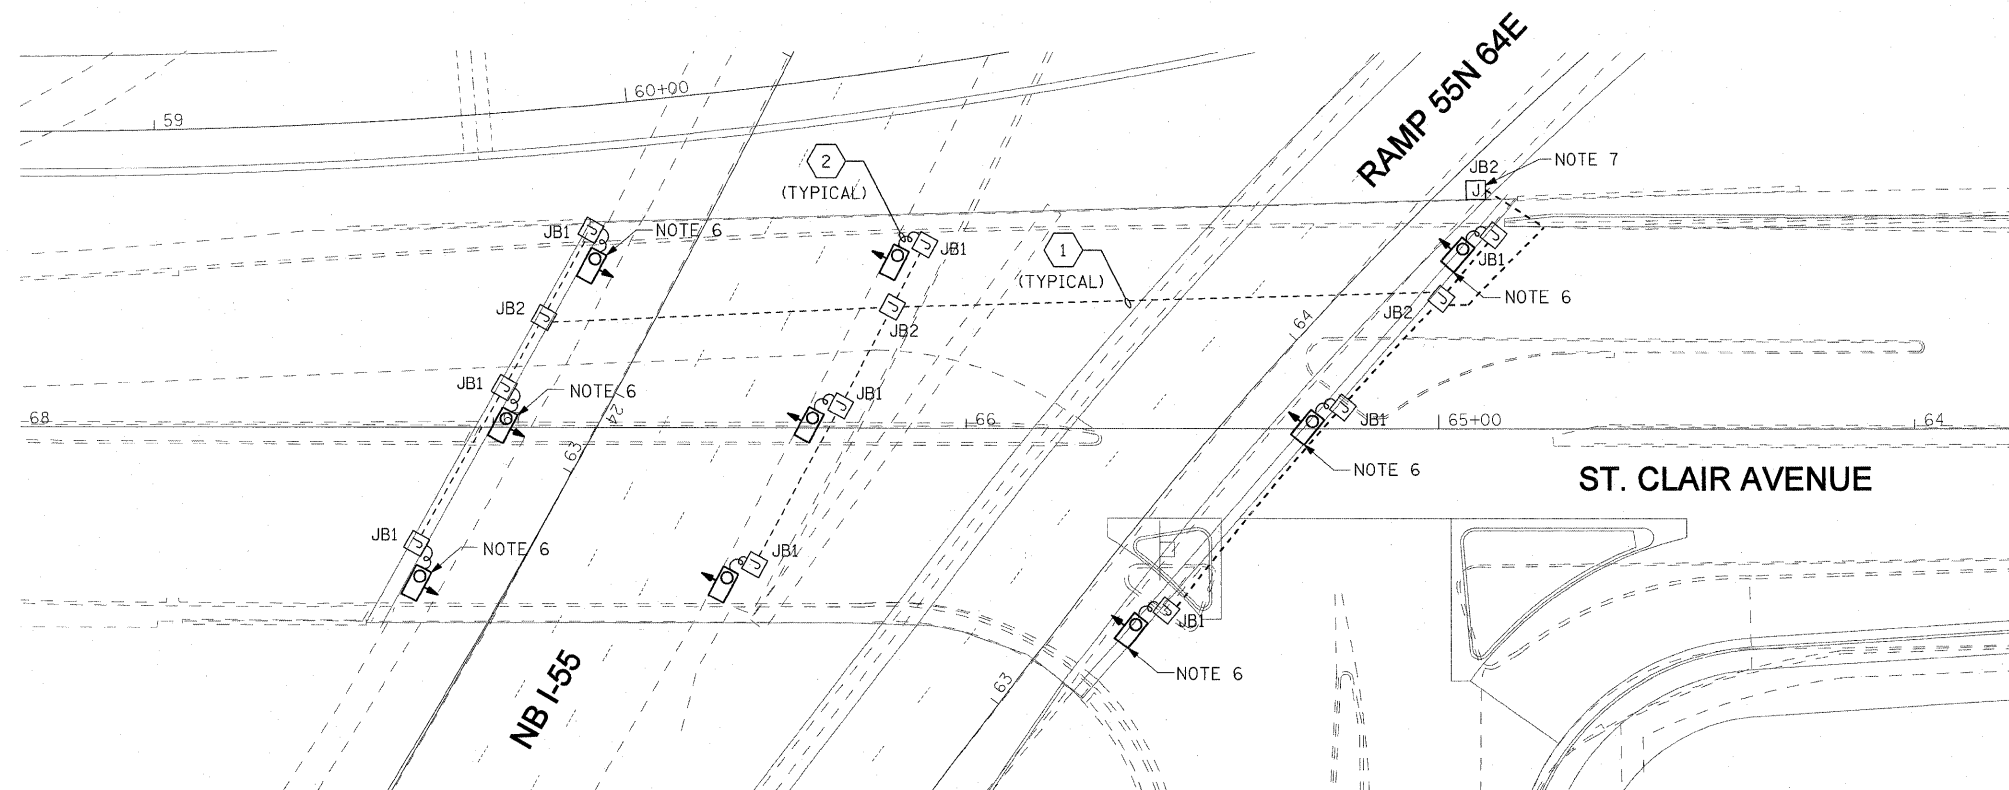


PROPOSED WORK
NOTE 9

NOTES:

1. SEE DRAWING ME-01 FOR ELECTRICAL SYMBOLS AND ABBREVIATIONS.
2. SEE IDOT STANDARD DETAIL LGT019 FOR UNDERPASS LIGHTING DETAILS.
3. COORDINATE ALL WORK WITH IDOT CONTRACT NOS. 76C49, 76C50, 76C51, 76C52, 76C53, 76C55, 76C75, AND 76C76.
4. ALL PROPOSED UNDERPASS LIGHTING UNITS SHOWN ON THIS DRAWING SHALL BE POWERED FROM IDOT CONTROLLER "1". SEE DRAWING SL-01 FOR SINGLE LINE DIAGRAM OF IDOT CONTROLLER "1".
5. ALL PROPOSED UNDERPASS LIGHTING UNITS SHOWN ON THIS DRAWING SHALL BE PENDANT MOUNTED OFFSET TWO (2) FEET FROM THE PROPOSED EDGE OF ROADWAY (EOR) UNLESS NOTED OTHERWISE.
6. PROPOSED UNDERPASS LIGHTING UNIT SHALL BE MOUNTED TO BRIDGE PIER.
7. SPLICE THE NEW UNDERPASS LIGHTING CIRCUIT CABLES TO THE ROADWAY LIGHTING CIRCUIT CABLES IN THE JUNCTION BOX. SEE DRAWING RL-03 FOR CONTINUATION OF THE ROADWAY LIGHTING CIRCUIT.
8. THE WORK TO REMOVE THE EXISTING CONDUIT, WIRE, JUNCTION BOXES, AND MOUNTING HARDWARE ASSOCIATED WITH THE REMOVAL OF THE EXISTING UNDERPASS LUMINAIRES SHALL BE INCLUDED IN THE "REMOVAL OF LUMINAIRE" PAY ITEM AND SHALL NOT BE PAID FOR SEPARATELY.
9. THE EXISTING AND PROPOSED UNDERPASS LIGHTING FOR ST. CLAIR AVE. SHALL BE REMOVED AND INSTALLED DURING CONTRACT NO. 76C51 STAGES 1 AND 2. UTILIZE CONTRACT NO. 76C51 LANE CLOSURES AND TRAFFIC CONTROL WHENEVER POSSIBLE.

JUNCTION BOX SCHEDULE		
NO.	SIZE	DESCRIPTION
JB1	6"x6"x4"	STAINLESS STEEL, ATTACHED TO STRUCTURE, UNDERPASS LIGHTING.
JB2	10"x8"x6"	STAINLESS STEEL, ATTACHED TO STRUCTURE, UNDERPASS LIGHTING.

CABLE /CONDUIT SCHEDULE	
NO.	DESCRIPTION
1	CKT. C: 2*10, 1*10 GND, IN 3/4" DIA. RGC ATTACHED TO STRUCTURE.
2	CKT. C: 2*10, 1*10 GND, IN 3/4" DIA. LIQUID TIGHT, NON METALLIC, FLEXIBLE CONDUIT.

 

UL-02

FILE NAME = \$FILEAS	USER NAME = jentzt	DESIGNED - WDS	REVISED -	STATE OF ILLINOIS DEPARTMENT OF TRANSPORTATION	UNDERPASS LIGHTING PLANS ST. CLAIR AVENUE			F.A.J. RTE. 55/64	SECTION 82-1L	COUNTY ST. CLAIR	TOTAL SHEETS 60	SHEET NO. 55
	PLOT SCALE = 20.0000' / IN.	DRAWN - TL	REVISED -		SCALE: NONE	SHEET NO. 2 OF 5 SHEETS	STA. N/A	TO STA. N/A	FED. ROAD DIST. NO.	ILLINOIS FED. AID PROJECT	CONTRACT NO. 76C54	
	PLOT DATE = 12/28/2010	CHECKED - JPC	REVISED -									
		DATE - JANUARY 4, 2011	REVISED -									