


STATE OF ILLINOIS
DEPARTMENT OF TRANSPORTATION
DIVISION OF HIGHWAYS
PLANS FOR PROPOSED
FEDERAL PROJECT
CITY OF DU QUOIN

SECTION	COUNTY	TOTAL SHEETS	SHEET NUMBER
05-0047-00-RP	PERRY	11	1
CITY OF DUQUOIN	PROJECT NO. HPP-1207(102)		
JOB NO. C-99-516-06	CONTRACT NO. 99273		

SECTION 05-0047-00-RP
PROJECT NO. HPP-1207(102)
JOB NO. C-99-516-06 CONTRACT NO. 99273

INDUSTRIAL PARK DRIVE - PHASE III

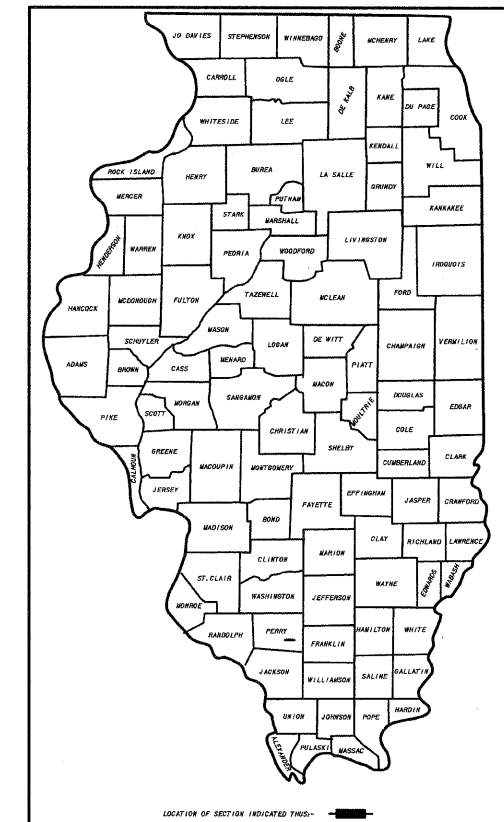


INDEX OF SHEETS

SHEET NO	DESCRIPTION
1	TITLE SHEET, INDEX OF SHEETS, LIST OF STANDARDS AND PROJECT LOCATION MAP
2	SUMMARY OF QUANTITIES, TYPICAL SECTIONS, PAVEMENT LAYOUT DETAIL FROM STA. 13+63.48 TO STA. 15+33.83, EXPANSION JOINT DETAIL- STA.7+98.9, PAVEMENT JOINT DETAIL AND STRUCTURAL DESIGN DATA
3-5	PLAN AND PROFILES
6-10	CROSS-SECTIONS
11	STORM WATER POLLUTION PREVENTION PLAN

LIST OF STANDARDS

STD.NO.	DESCRIPTION
280001-5	TEMPORARY EROSION CONTROL SYSTEMS
420001-07	PAVEMENT JOINTS
420101-04	24' (7.2m) JOINTED PCC PAVEMENT
542301-03	PRECAST REINFORCED CONCRETE FLARED END SECTION
701901-01	TRAFFIC CONTROL DEVICES
720001-01	SIGN PANEL MOUNTING DETAILS
720006-02	SIGN PANEL ERECTION DETAILS
720011-01	METAL POSTS FOR SIGNS, MARKERS & DELINEATORS
729001-01	APPLICATIONS OF TYPES A & B METAL POSTS (FOR SIGNS & MARKERS)
B.L.R. 21-8	TYPICAL APPLICATION OF TRAFFIC CONTROL DEVICES FOR CONSTRUCTION ON RURAL LOCAL HIGHWAYS

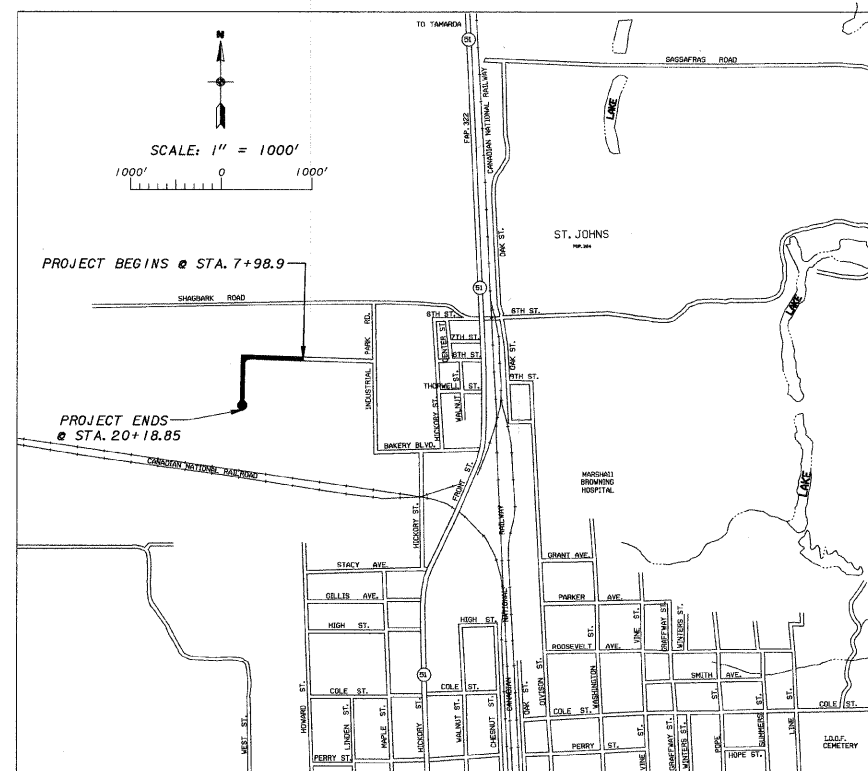

PROJECT LOCATION
NET LENGTH OF PROJECT - 1219.95 FT - 0.231 MI.

UTILITIES ON PROJECT

CITY OF DUQUOIN - WATER & SEWER
AMEREN ILLINOIS - MARION, IL. - ELECTRIC & GAS
FRONTIER - MARION, IL. - TELEPHONE
COMCAST - DUQUOIN, IL. - CABLE TV

SCALES
PLAN 1 INCH = 20 FEET
PROFILE HORIZ. 1 INCH = 20 FEET
PROFILE VERT. 1 INCH = 5 FEET
CROSS SECTIONS 1 INCH = 5 FEET HORIZ.
CROSS SECTIONS 1 INCH = 5 FEET VERT.

DESIGN SPEED 30MPH
CLASSIFICATION LOCAL ROAD (TRUCK ROUTE)
ADT 2031 <50
ADT 2011 <50
J.U.L.I.E 1-800-892-0123

APPROVED 4/7/11 2011
John Rednour
JOHN REDNOUR, MAYOR - CITY OF DUQUOIN

APPROVED 4/11/2011 2011
Dennis Hillebrenner
DENNIS HILLEBRENNER - DISTRICT 9 ENGINEER OF LOCAL ROADS & STREETS

RELEASING FOR BID 4/12 2011
BASED ON LIMITED REVIEW *Mary C. Lame*
MARY C. LAME, P.E. - DEPUTY DIRECTOR OF HIGHWAYS
REGION FIVE ENGINEER



Ted R. Beggs
TED R. BEGGS, P.E.
REG. NO. 082-083738
DATE 4/12/11
EXPIRES 11-30-11

STATE OF ILLINOIS
DEPARTMENT OF TRANSPORTATION

SCALE AS SHOWN	J. T. BLANKINSHIP, INC. CONSULTING ENGINEERS & LAND SURVEYORS ILLINOIS PROFESSIONAL DESIGN FIRM NO.1394 P.O. BOX 40 401 S. 17TH STREET MURPHYSBORO, ILLINOIS 62966 PHONE 618-687-1771	FILE NO. E-8809
DATE MARCH 2011		DESIGN FILE E8809-01.dgn
DRAWN BY ASW/SDR		SHEET NO. 1 OF 11