



FILE PATH = p:\388035\pmt\escomon\me\local\AECOM\Documents\01\_Americas\Transportation\6269938\_Circle\Phase\_1\000\_CAD\01E\_Electrical\Sheets\60W28\_sht-Light-02

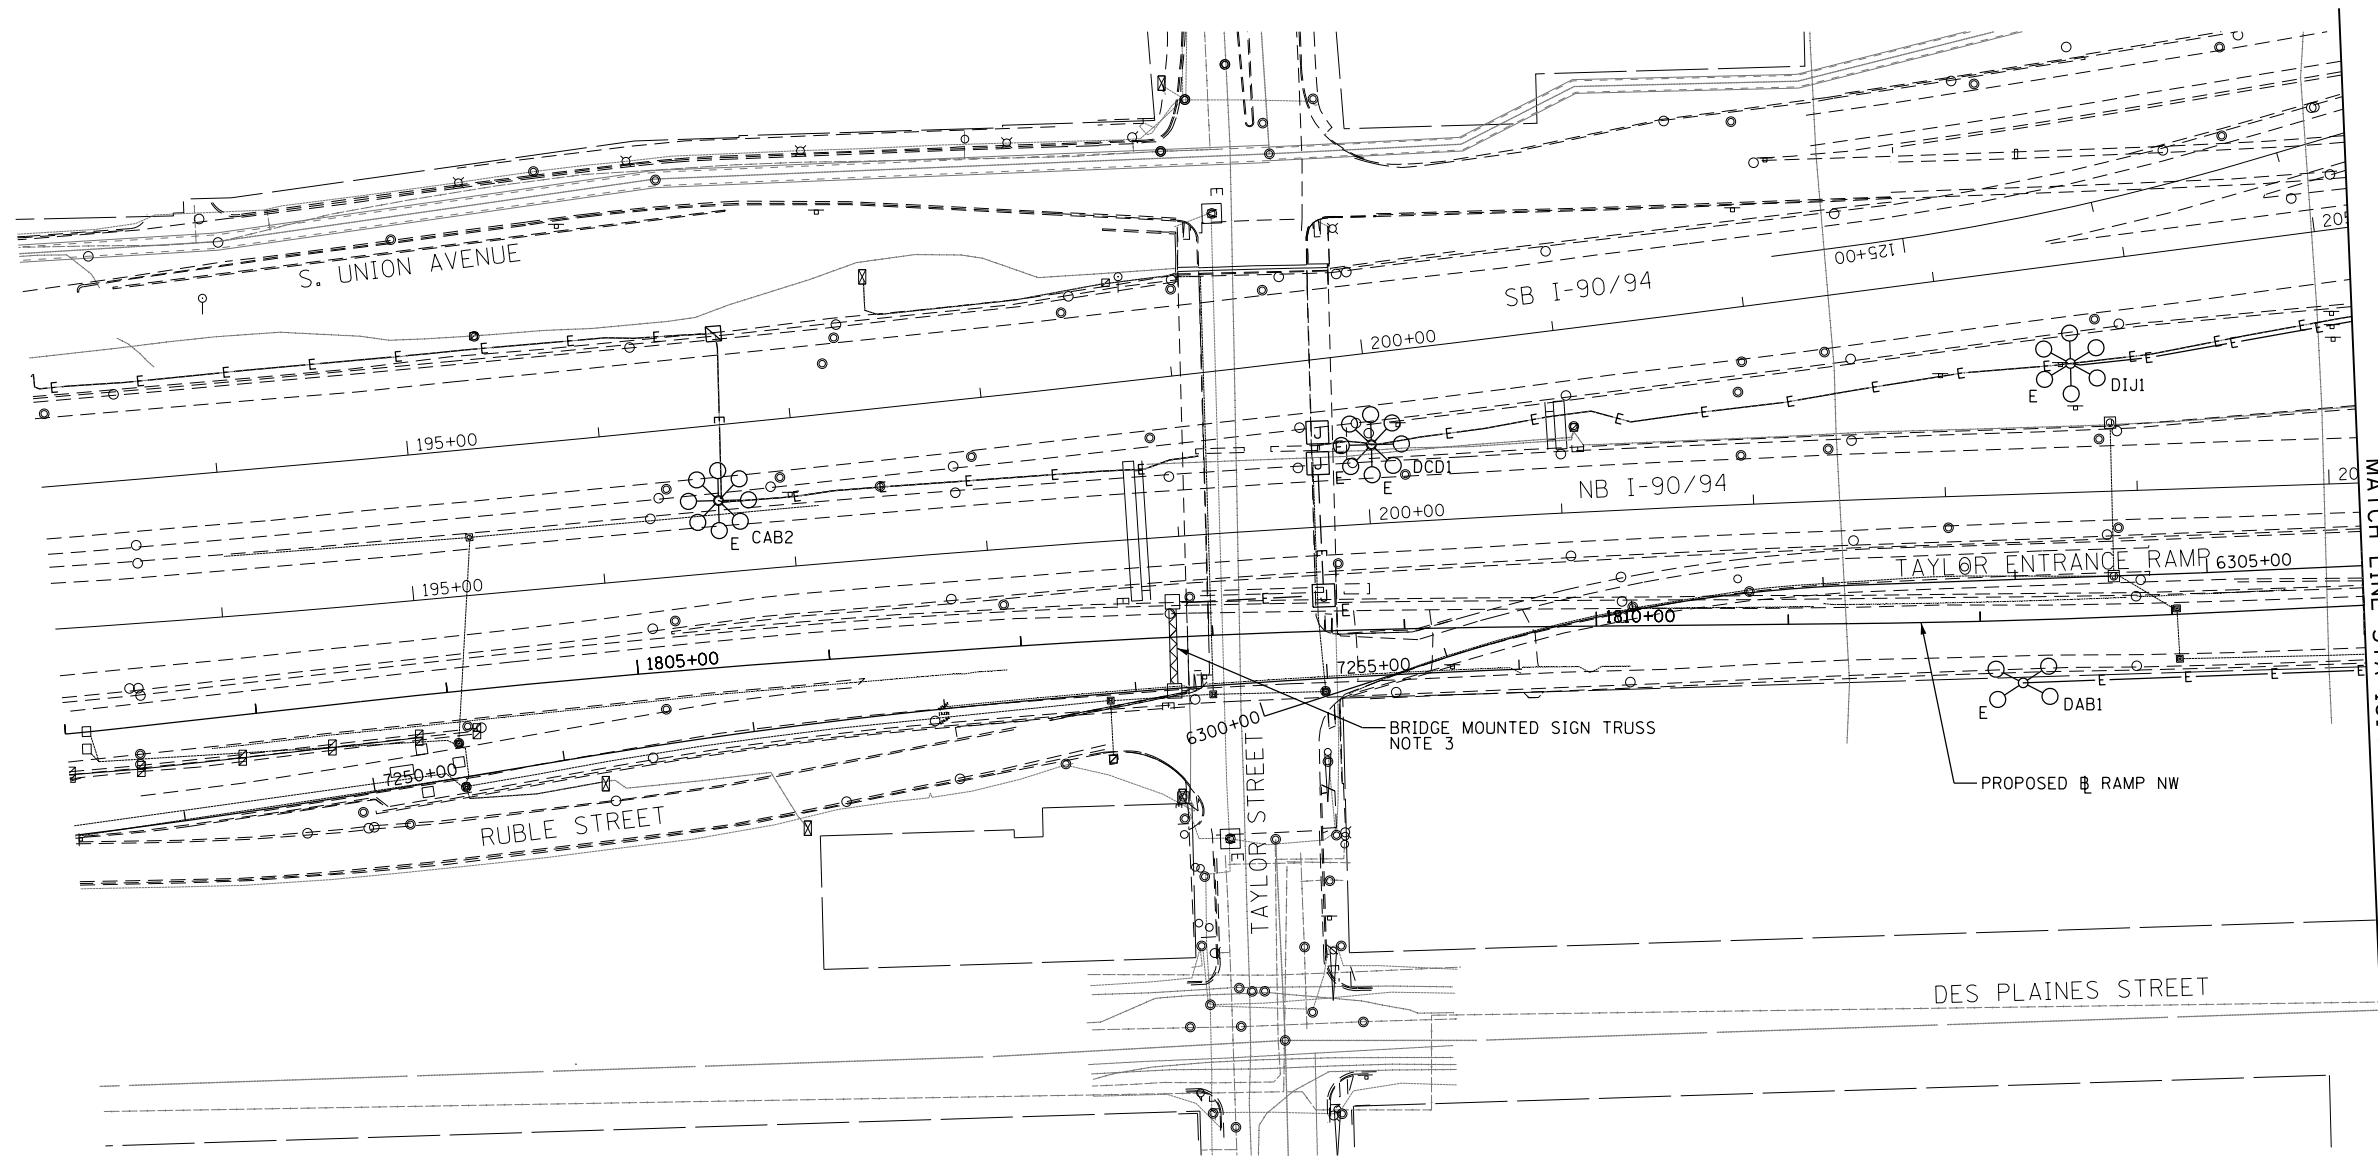

**NOTES:**

1. SEE DRAWING E-01 FOR IDOT ELECTRICAL SYMBOLS.
2. LOCATIONS OF EXISTING ELECTRICAL EQUIPMENT SHOWN ON THIS DRAWING ARE APPROXIMATIONS AND MUST BE VERIFIED IN THE FIELD BY THE CONTRACTOR.
3. DISCONNECT THE EXISTING SIGN LIGHTING ELECTRICAL FEED AND REMOVE CABLES BACK TO THE NEAREST SPLICE POINT. SIGN LUMINAIRES AND ALL ELECTRICAL EQUIPMENT MOUNTED TO SIGN STRUCTURE WILL BE REMOVED AS PART OF THE STRUCTURE. COORDINATE THIS WORK WITH THE SIGN STRUCTURE REMOVAL.

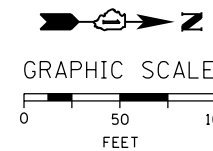

E-02



D160W28-sht-Light-02  
 USER NAME = myersc  
 PLOT SCALE = 50.0000' / in.  
 PLOT DATE = 4/24/2014

DESIGNED - WDS  
 DRAWN - CAM  
 CHECKED - WDS  
 DATE - 04/28/14

REVISED -  
 REVISED -  
 REVISED -  
 REVISED -

**STATE OF ILLINOIS  
 DEPARTMENT OF TRANSPORTATION**

**RAMP NORTHWEST  
 EXISTING/TEMPORARY LIGHTING PLAN**

SCALE: 1"=50' SHEET 2 OF 17 SHEETS STA. 1802+00 TO STA. 1814+00

F.A.I. RTE.	SECTION	COUNTY	TOTAL SHEETS	SHEET NO.
90/94/290	2013-010R	COOK	747	292
CONTRACT NO. 60W28				
ILLINOIS FED. AID PROJECT				