



PLAN	DATE
BY	
NO.	
DATE	
BY	
NO.	
DATE	
BY	
NO.	
DATE	

PROFILE	DATE
BY	
NO.	
DATE	
BY	
NO.	
DATE	
BY	
NO.	
DATE	

McDonough Associates Inc.
 Engineers / Architects
 130 East Randolph Street, Chicago, Illinois 60601

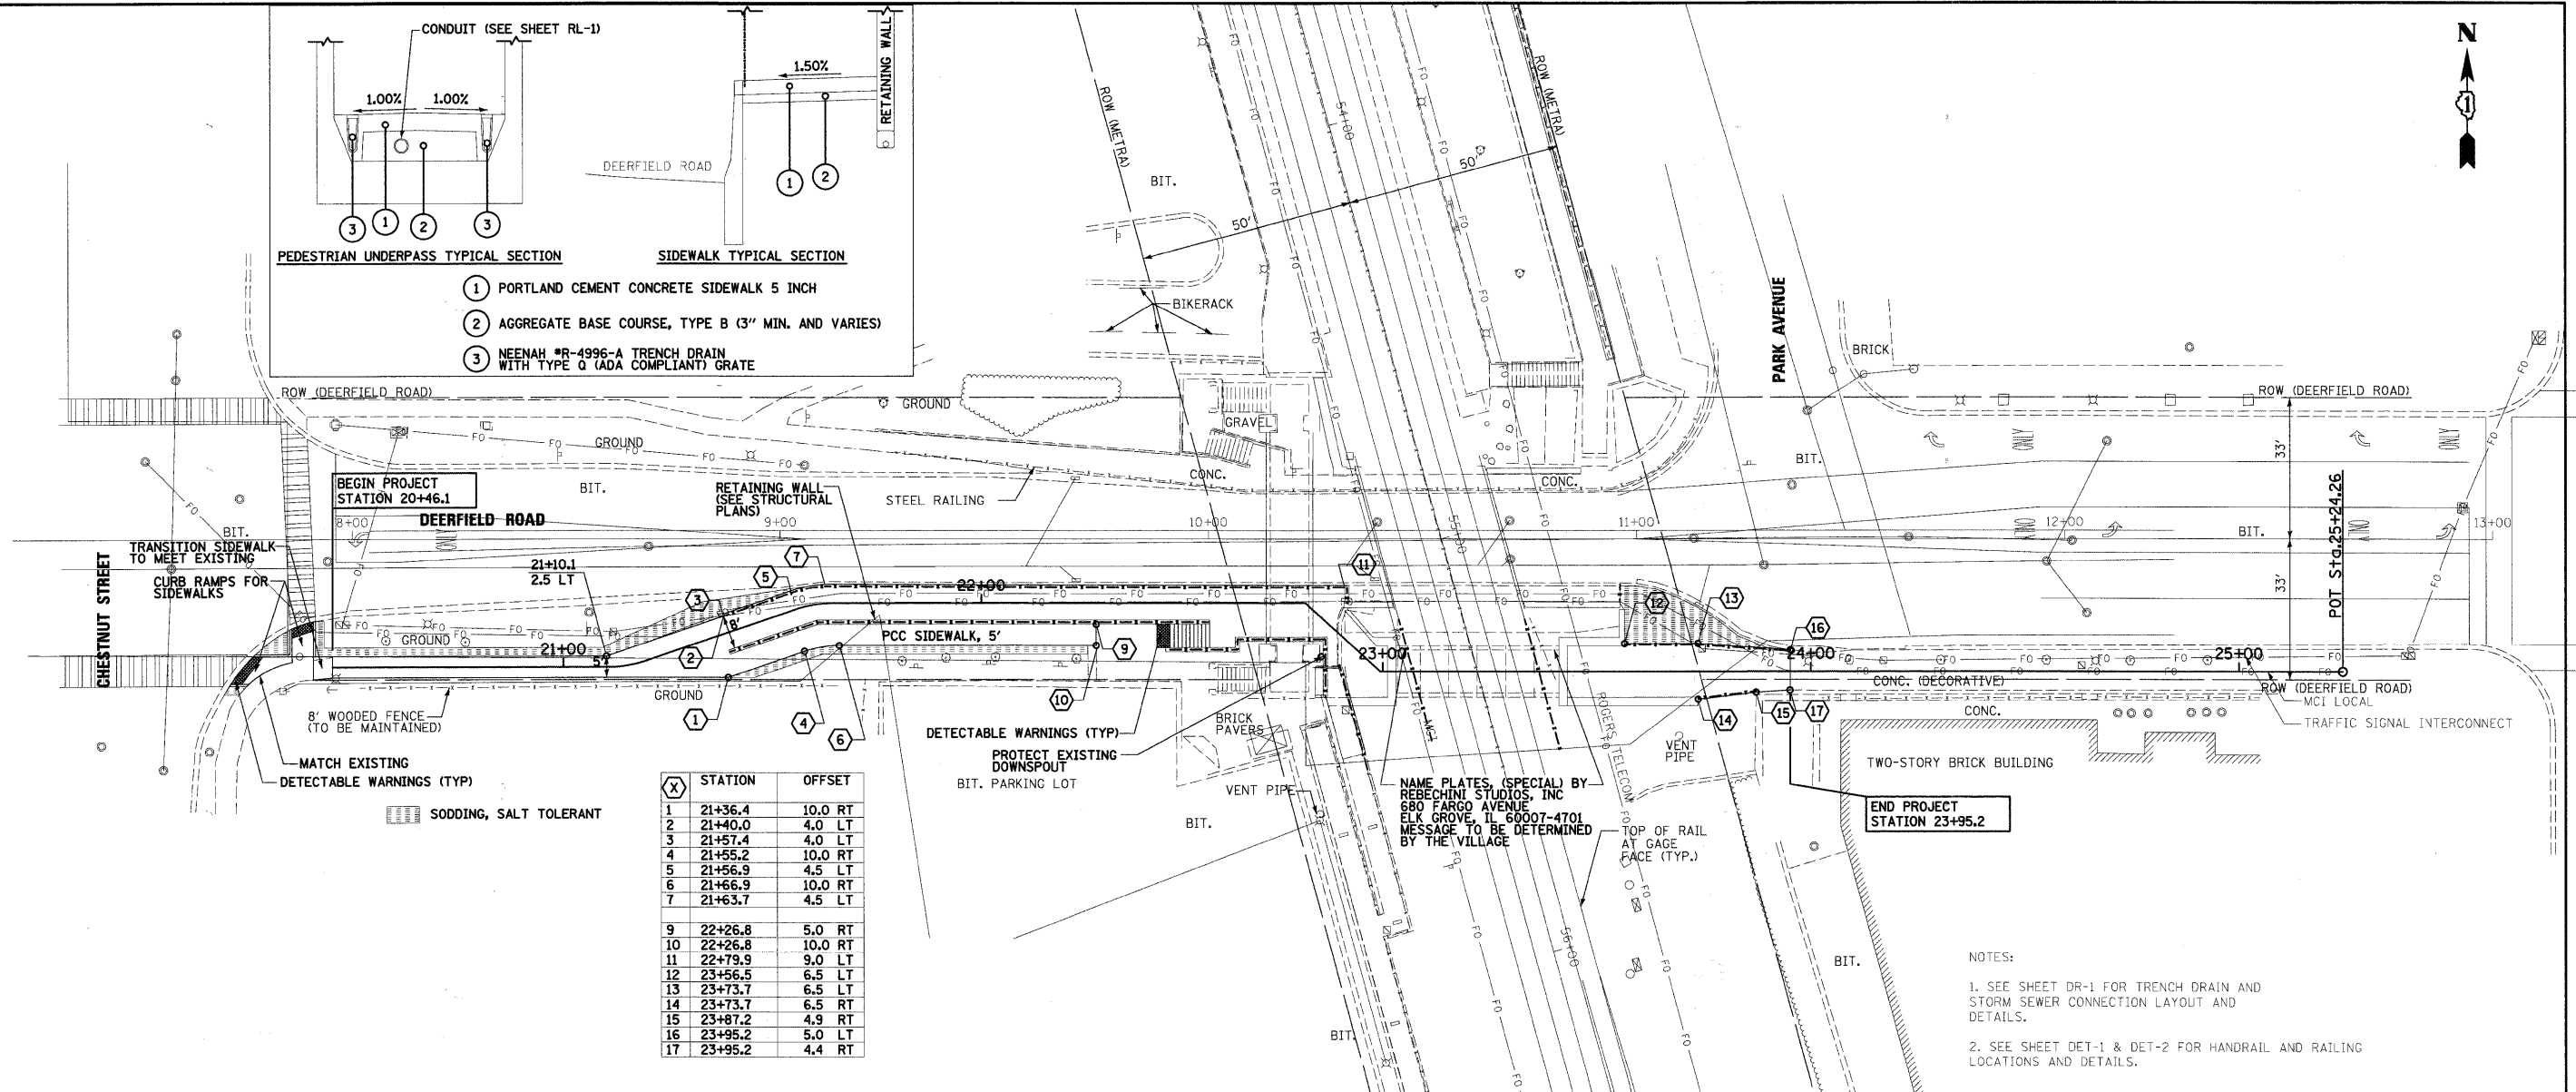

NOTES:
 1. SEE SHEET DR-1 FOR TRENCH DRAIN AND STORM SEWER CONNECTION LAYOUT AND DETAILS.
 2. SEE SHEET DET-1 & DET-2 FOR HANDRAIL AND RAILING LOCATIONS AND DETAILS.

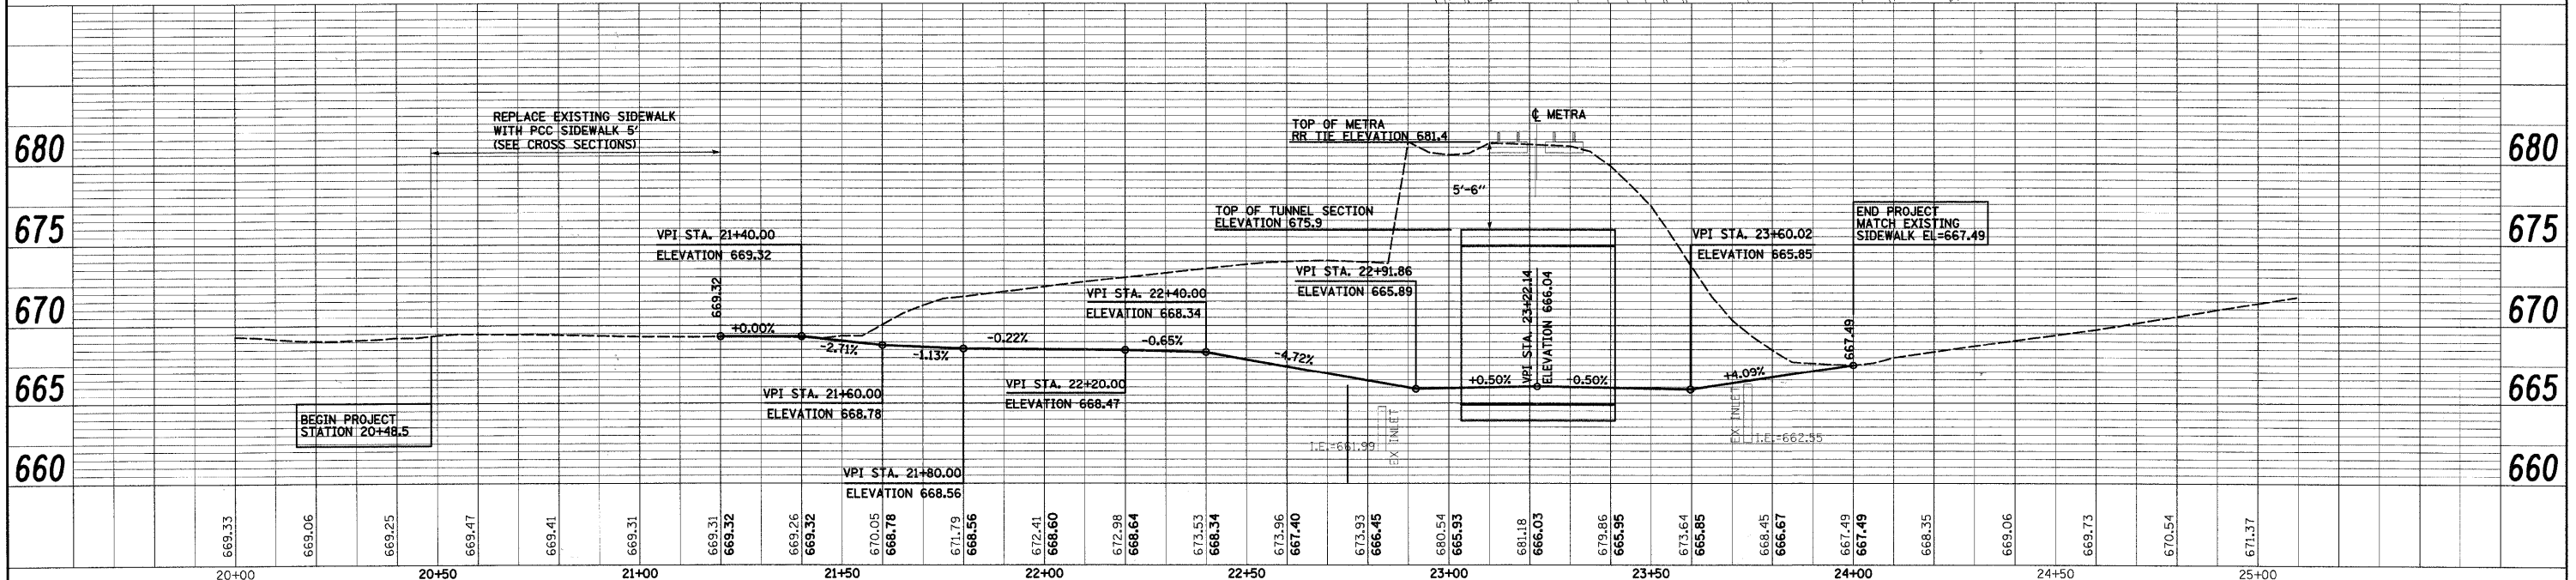

FILE NAME = 01-shr-plan@1dgn.dgn	USER NAME = JMdellet	DESIGNED - JWM	REVISED -	STATE OF ILLINOIS DEPARTMENT OF TRANSPORTATION	PROPOSED PLAN AND PROFILE SCALE: 1"=20' SHEET NO. OF SHEETS STA. TO STA.	F.A.U. RTE. 1257	SECTION 08-00083-00-BT	COUNTY LAKE	TOTAL SHEETS 51	SHEET NO. 8	
	PLOT SCALE = 1:248	CHECKED - JLB	REVISED -			FED. ROAD DIST. NO. 1	ILLINOIS FED. AID PROJECT	CONTRACT NO. 63450			
	PLOT DATE = 4/13/2010	DATE - 04/09/10	REVISED -								