 



SEE SHT. 5A/7  
MATCHLINE STA. 123+00

MATCHLINE STA. 138+00

SEE SHT. 4A/7  
MATCHLINE STA. 107+00

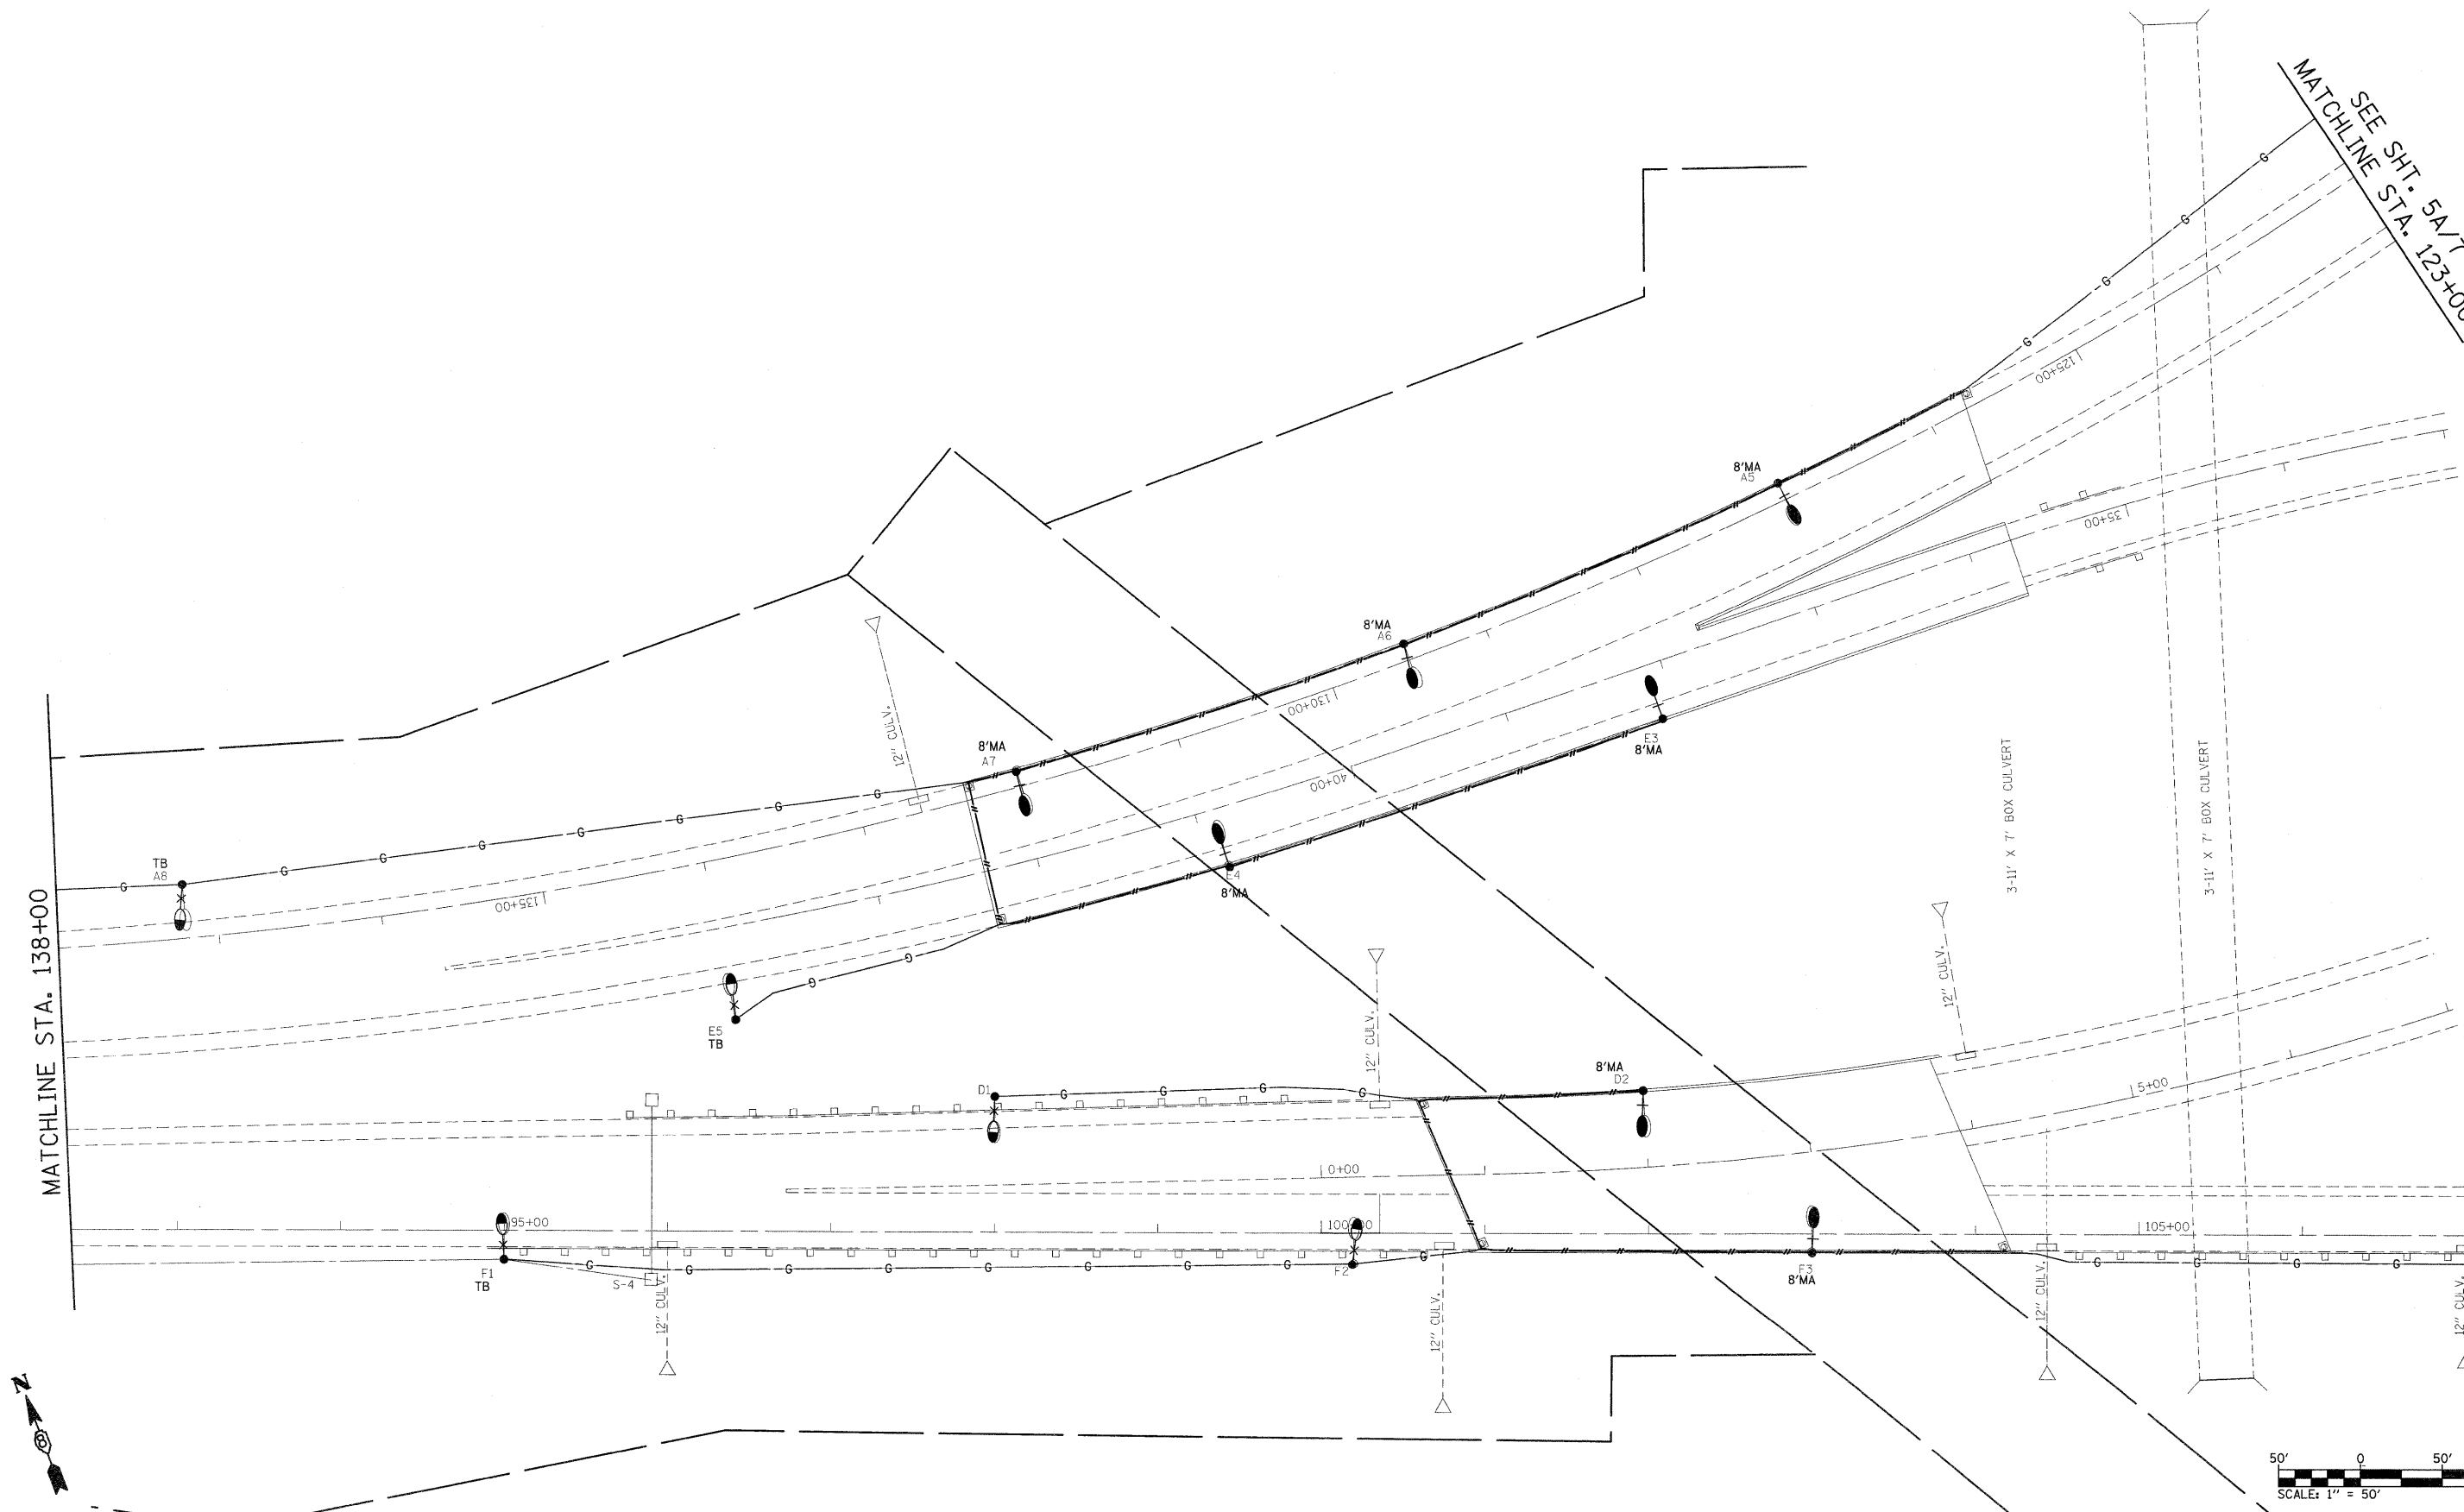

FILE NAME =  
c:\pwork\pavidot\prestonma\dms65337\8875c09-shlt-light.dgn

USER NAME = prestonma  
PLOT SCALE = 50.0000' / IN.  
PLOT DATE = 6/8/2010

DESIGNED -  
DRAWN -  
CHECKED -  
DATE -

REVISED -  
REVISED -  
REVISED -  
REVISED -

**STATE OF ILLINOIS  
DEPARTMENT OF TRANSPORTATION**

**CONTROLLERS #1 & #3 SHT. 2 OF 7  
LIGHTING PLAN**

SCALE: \_\_\_\_\_ SHEET NO. \_\_\_\_\_ OF \_\_\_\_\_ SHEETS STA. \_\_\_\_\_ TO STA. \_\_\_\_\_

F.A.J. RTE.	SECTION	COUNTY	TOTAL SHEETS	SHEET NO.
255	DIST. 8 LIGHT POLE 2009-1		146	43
FED. ROAD DIST. NO. ILLINOIS FED. AID PROJECT			CONTRACT NO. 16C09	

MADISON, MONROE & ST. CLAIR