



MATCHLINE  
STA. 107+00  
SEE SHT. 2/7

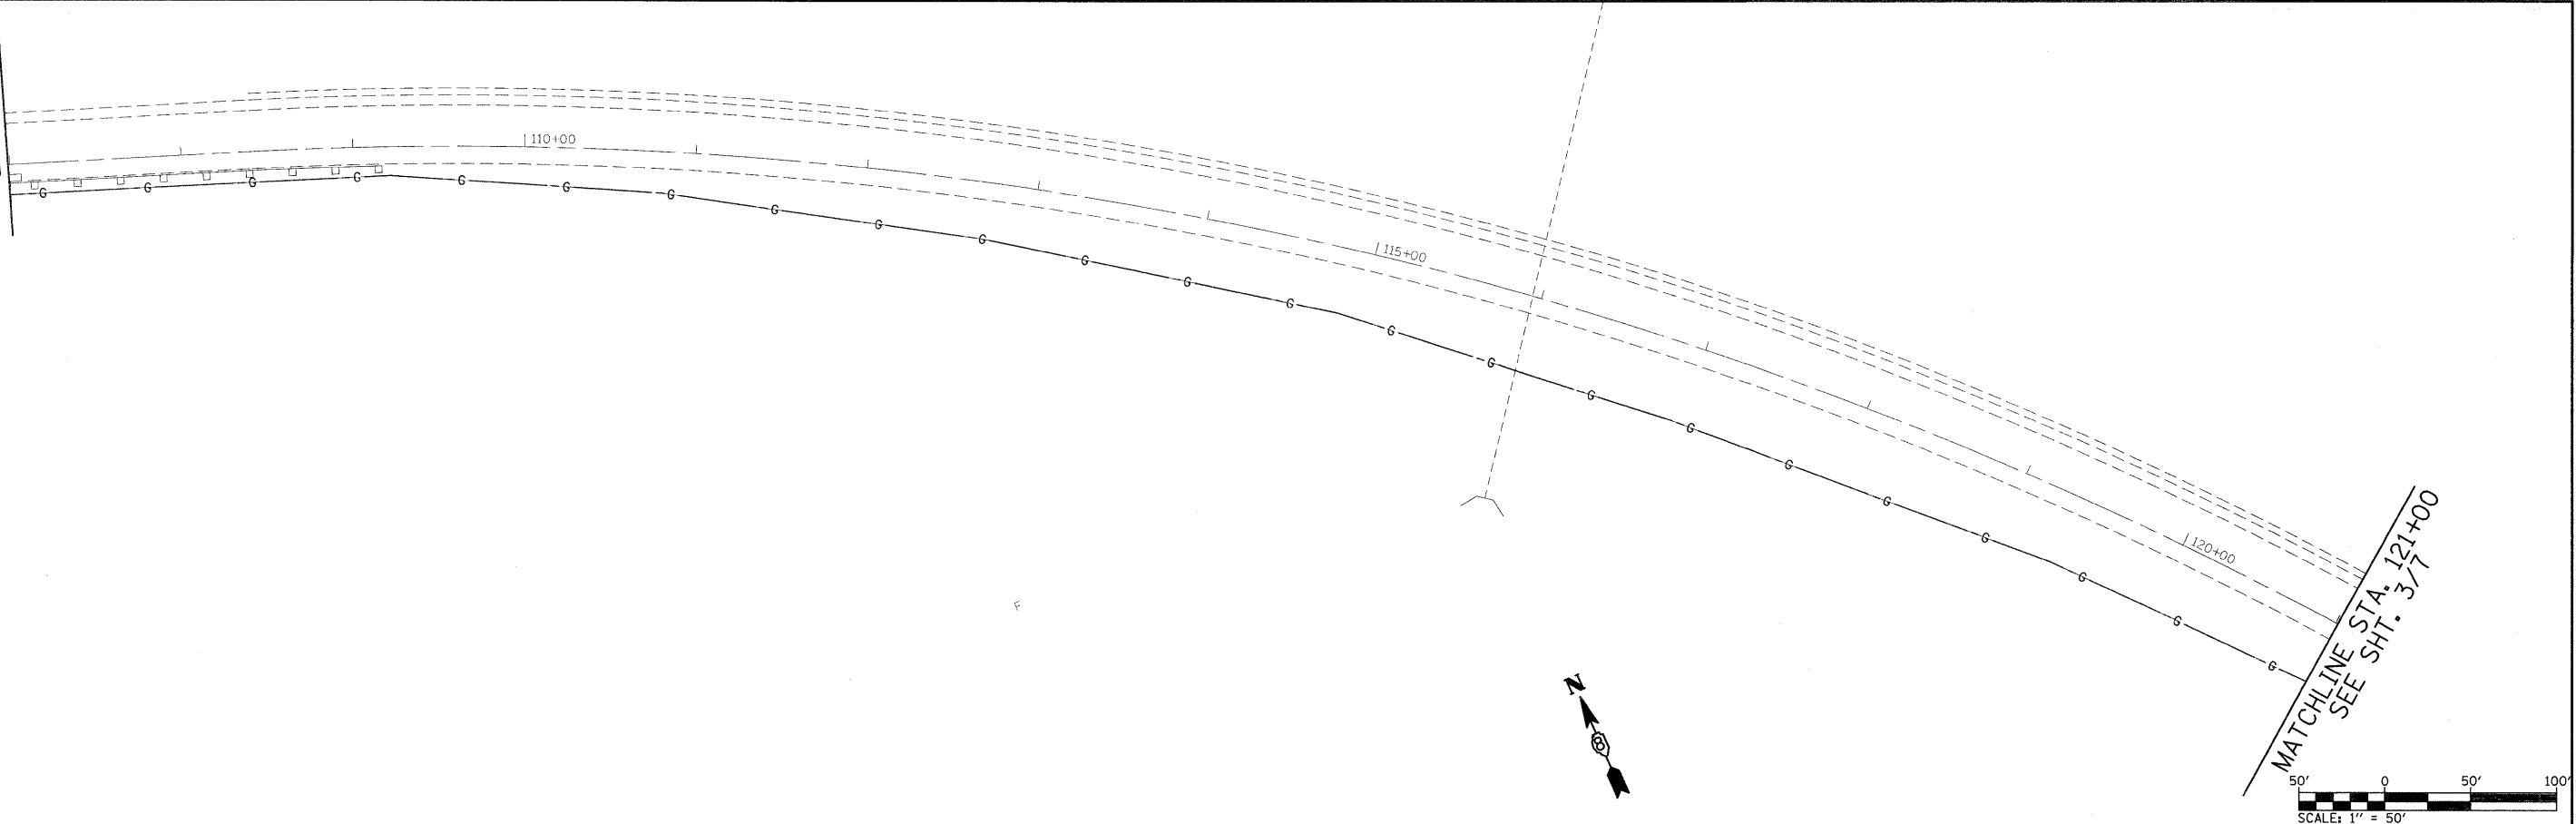

MATCHLINE STA. 121+00  
SEE SHT. 3/7

SCALE: 1" = 50'

SEE SHT. 3/7  
MATCHLINE A

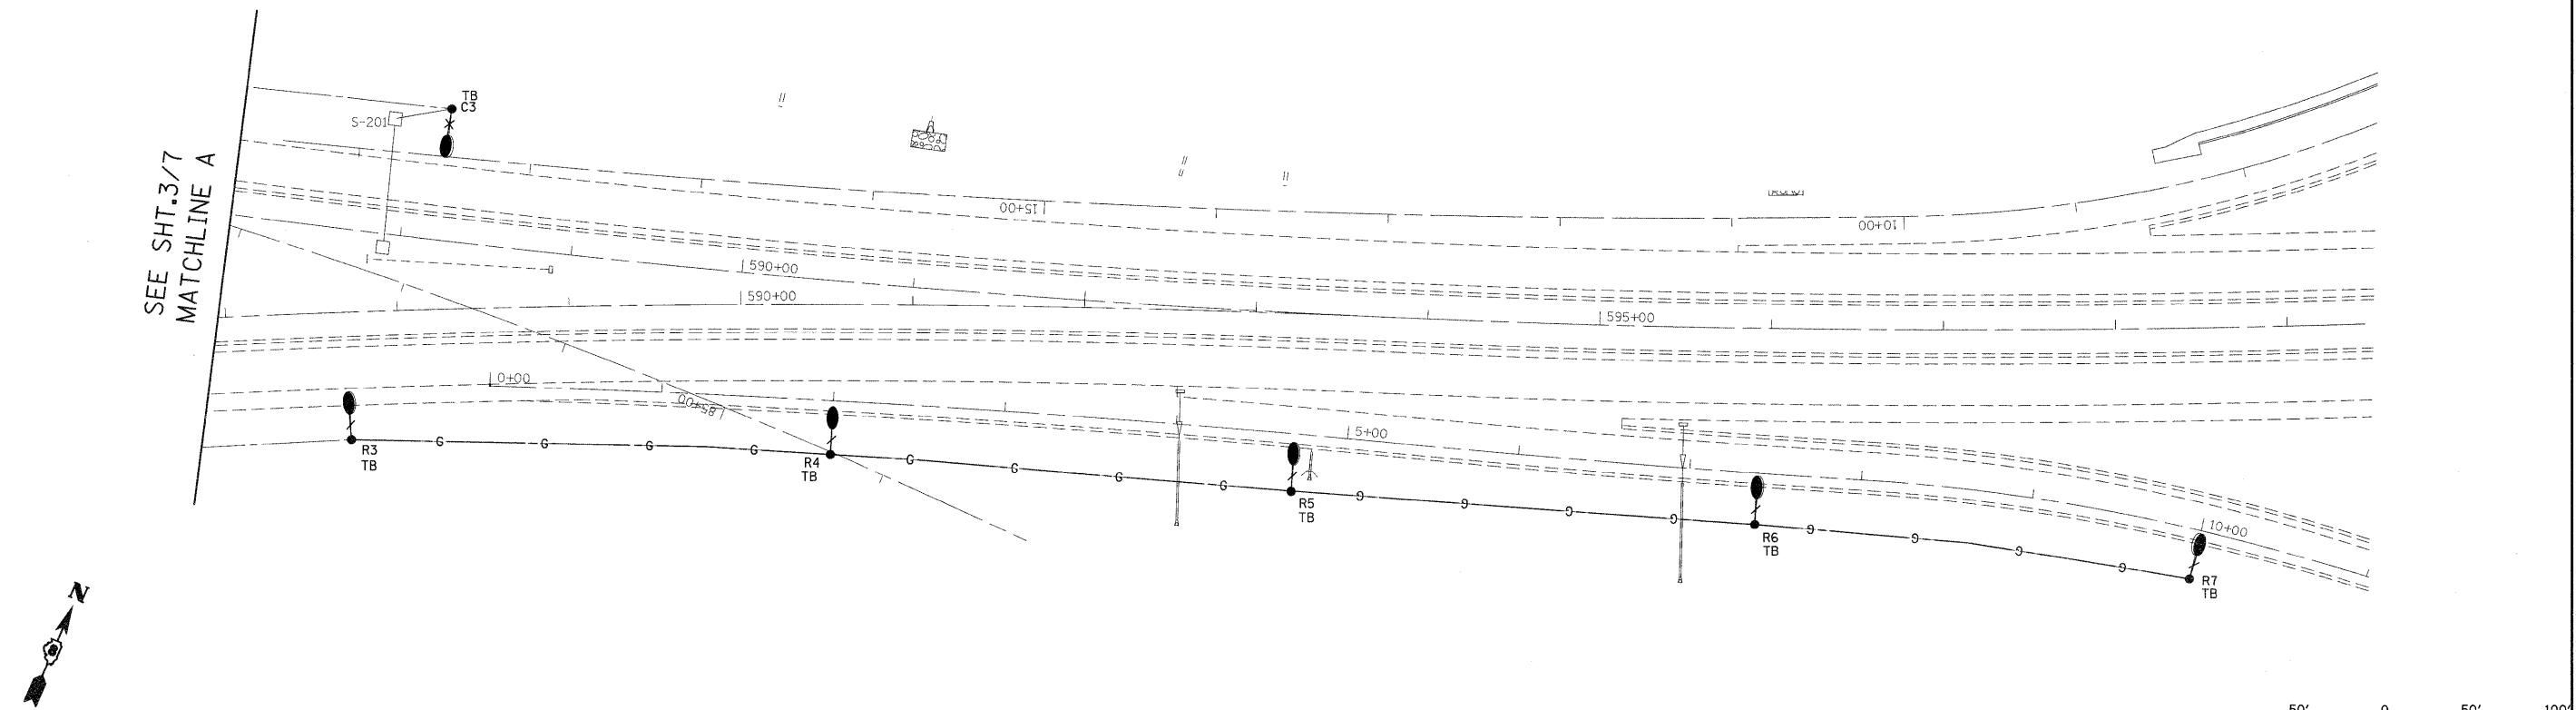

SCALE: 1" = 50'

FILE NAME =  
c:\pwork\pwork\prestonme\dms65337\0876c09-shr-light.dgn

USER NAME = prestonme  
PLOT SCALE = 50.0000 ' / IN.  
PLOT DATE = 6/25/2010

DESIGNED -  
DRAWN -  
CHECKED -  
DATE -

REVISED -  
REVISED -  
REVISED -  
REVISED -

STATE OF ILLINOIS  
DEPARTMENT OF TRANSPORTATION

CONTROLLERS #1 & #3 SHTS. 4A & 4B OF 7  
LIGHTING PLAN

SCALE: SHEET NO. OF SHEETS STA. TO STA.

F.A.I. RTE.	SECTION	COUNTY	TOTAL SHEETS	SHEET NO.
255	DIST. 8 LIGHT POLE 2009-1		146	45
CONTRACT NO. 76C09				

FED. ROAD DIST. NO. ILLINOIS FED. AID PROJECT