
 




MATCHLINE STA. 517+00

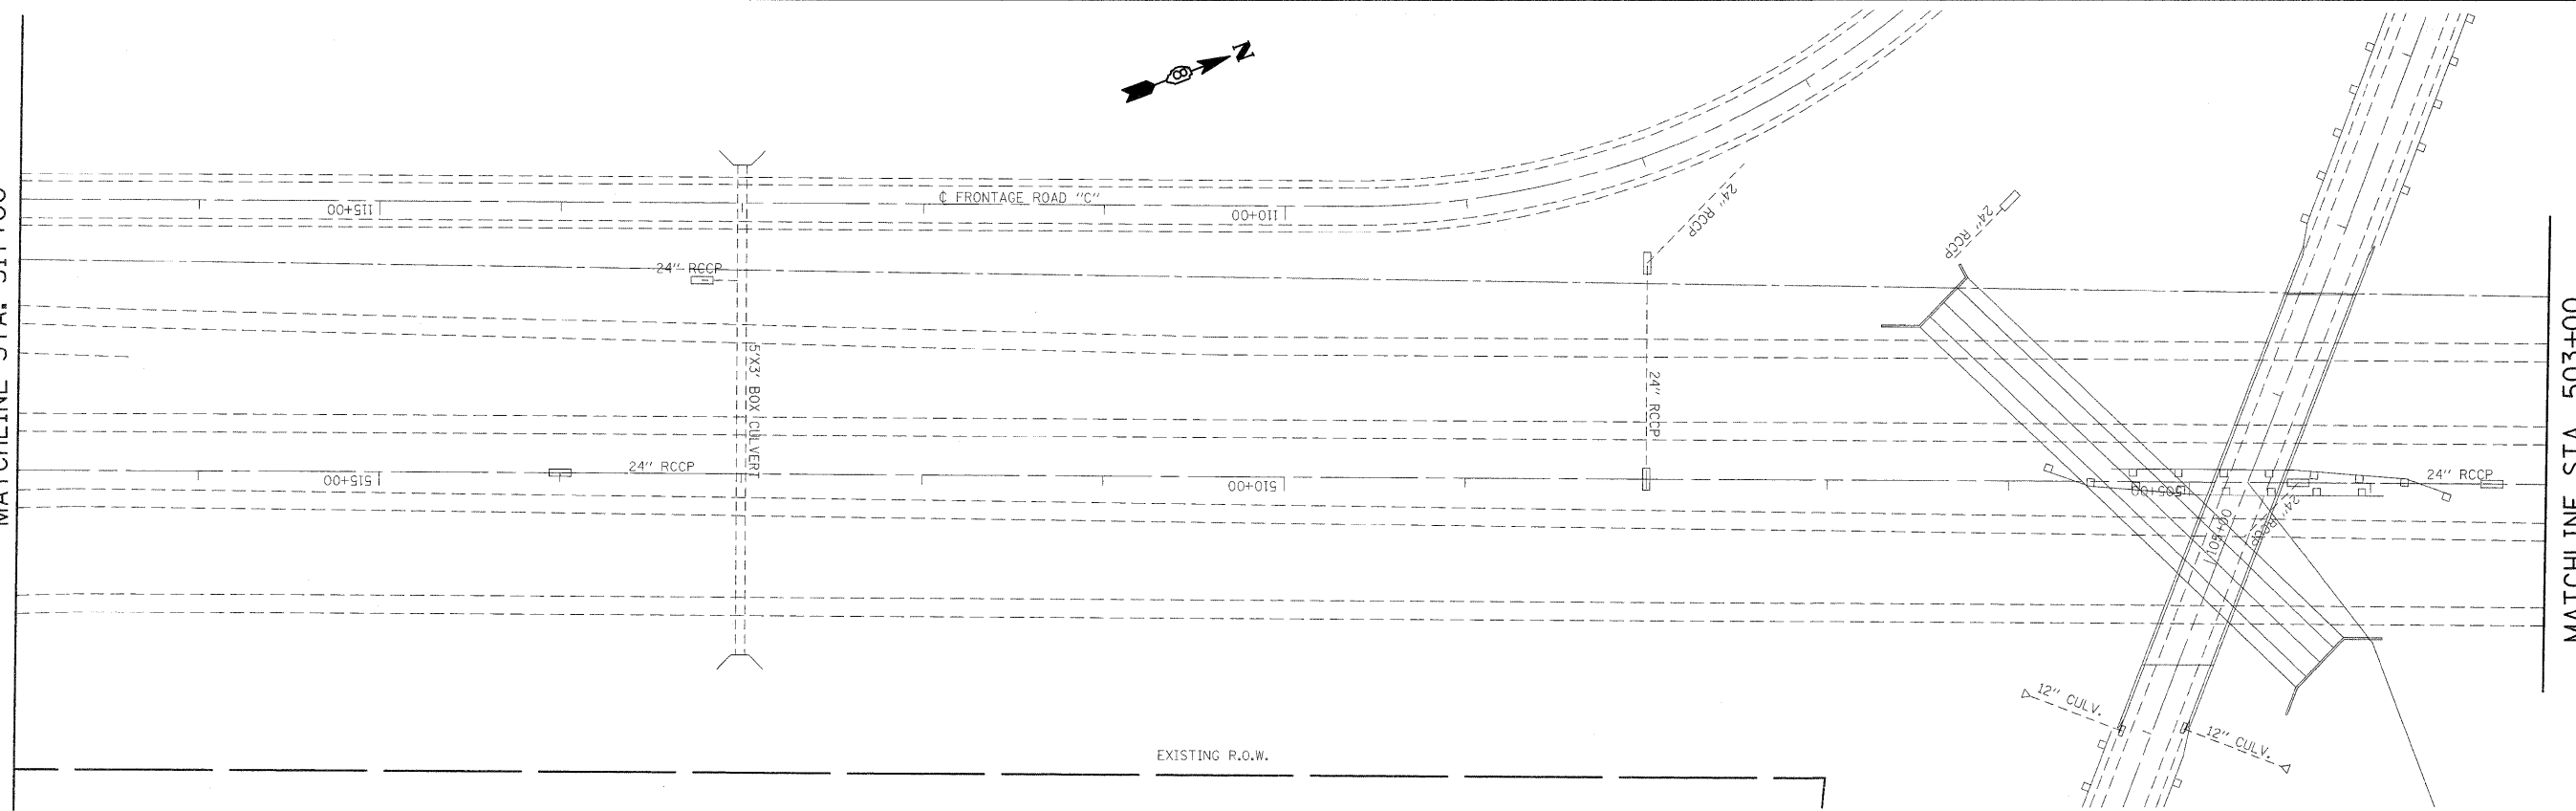

MATCHLINE STA. 503+00



 MATCHLINE STA. 503+00

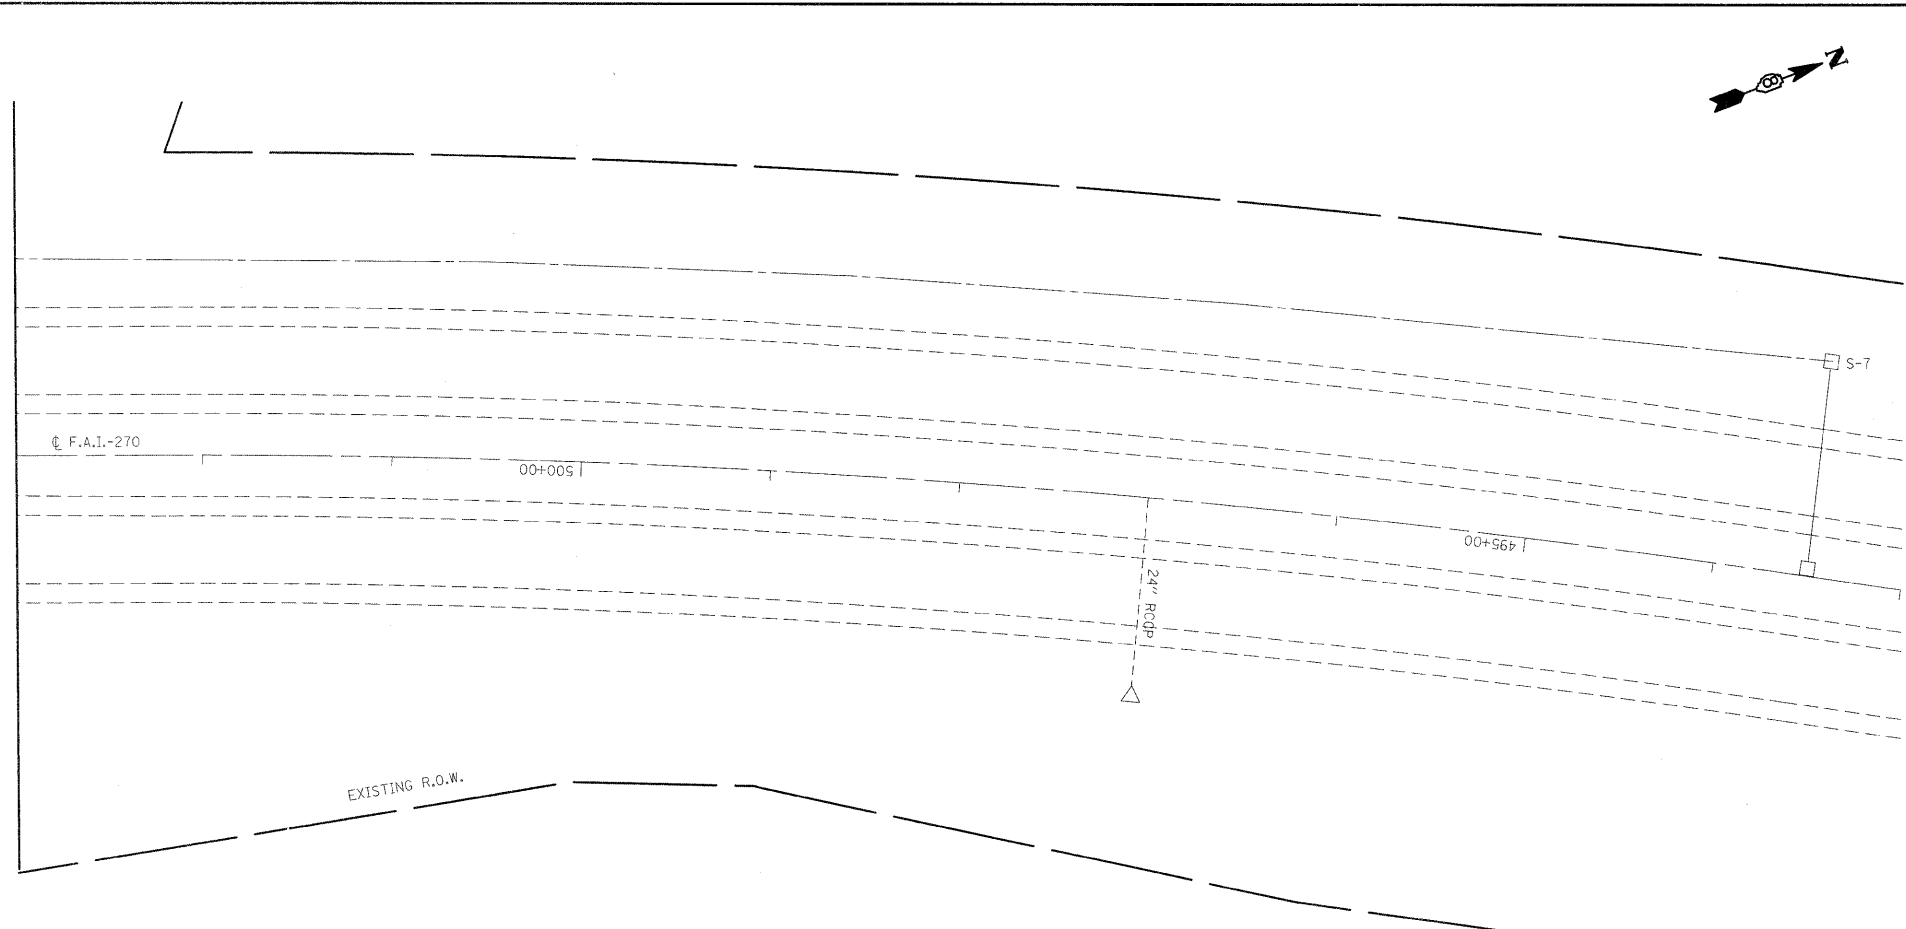

FILE NAME =	USER NAME = prestonme	DESIGNED - ---	REVISED - ---
c:\pw_work\pwidot\prestonme\dms65337\dms75c89-shr-light.dgn		DRAWN - ---	REVISED - ---
PLOT SCALE = 50.0000' / IN.		CHECKED - ---	REVISED - ---
PLOT DATE = 6/8/2010		DATE - ---	REVISED - ---

**STATE OF ILLINOIS  
DEPARTMENT OF TRANSPORTATION**

**CONTROLLERS #1 & #3 SHTS. 7A & 7B OF 7  
LIGHTING PLAN**

F.A.I. RTE.	SECTION	COUNTY	TOTAL SHEETS	SHEET NO.
255	DIST. 8 LIGHT POLE 2009-1		146	48
FED. ROAD DIST. NO. _____		ILLINOIS FED. AID PROJECT		
		CONTRACT NO. 76C09		

SCALE: \_\_\_\_\_ SHEET NO. \_\_\_ OF \_\_\_ SHEETS STA. \_\_\_\_\_ TO STA. \_\_\_\_\_