


**SCANNED  
HISTORIC PLANS**

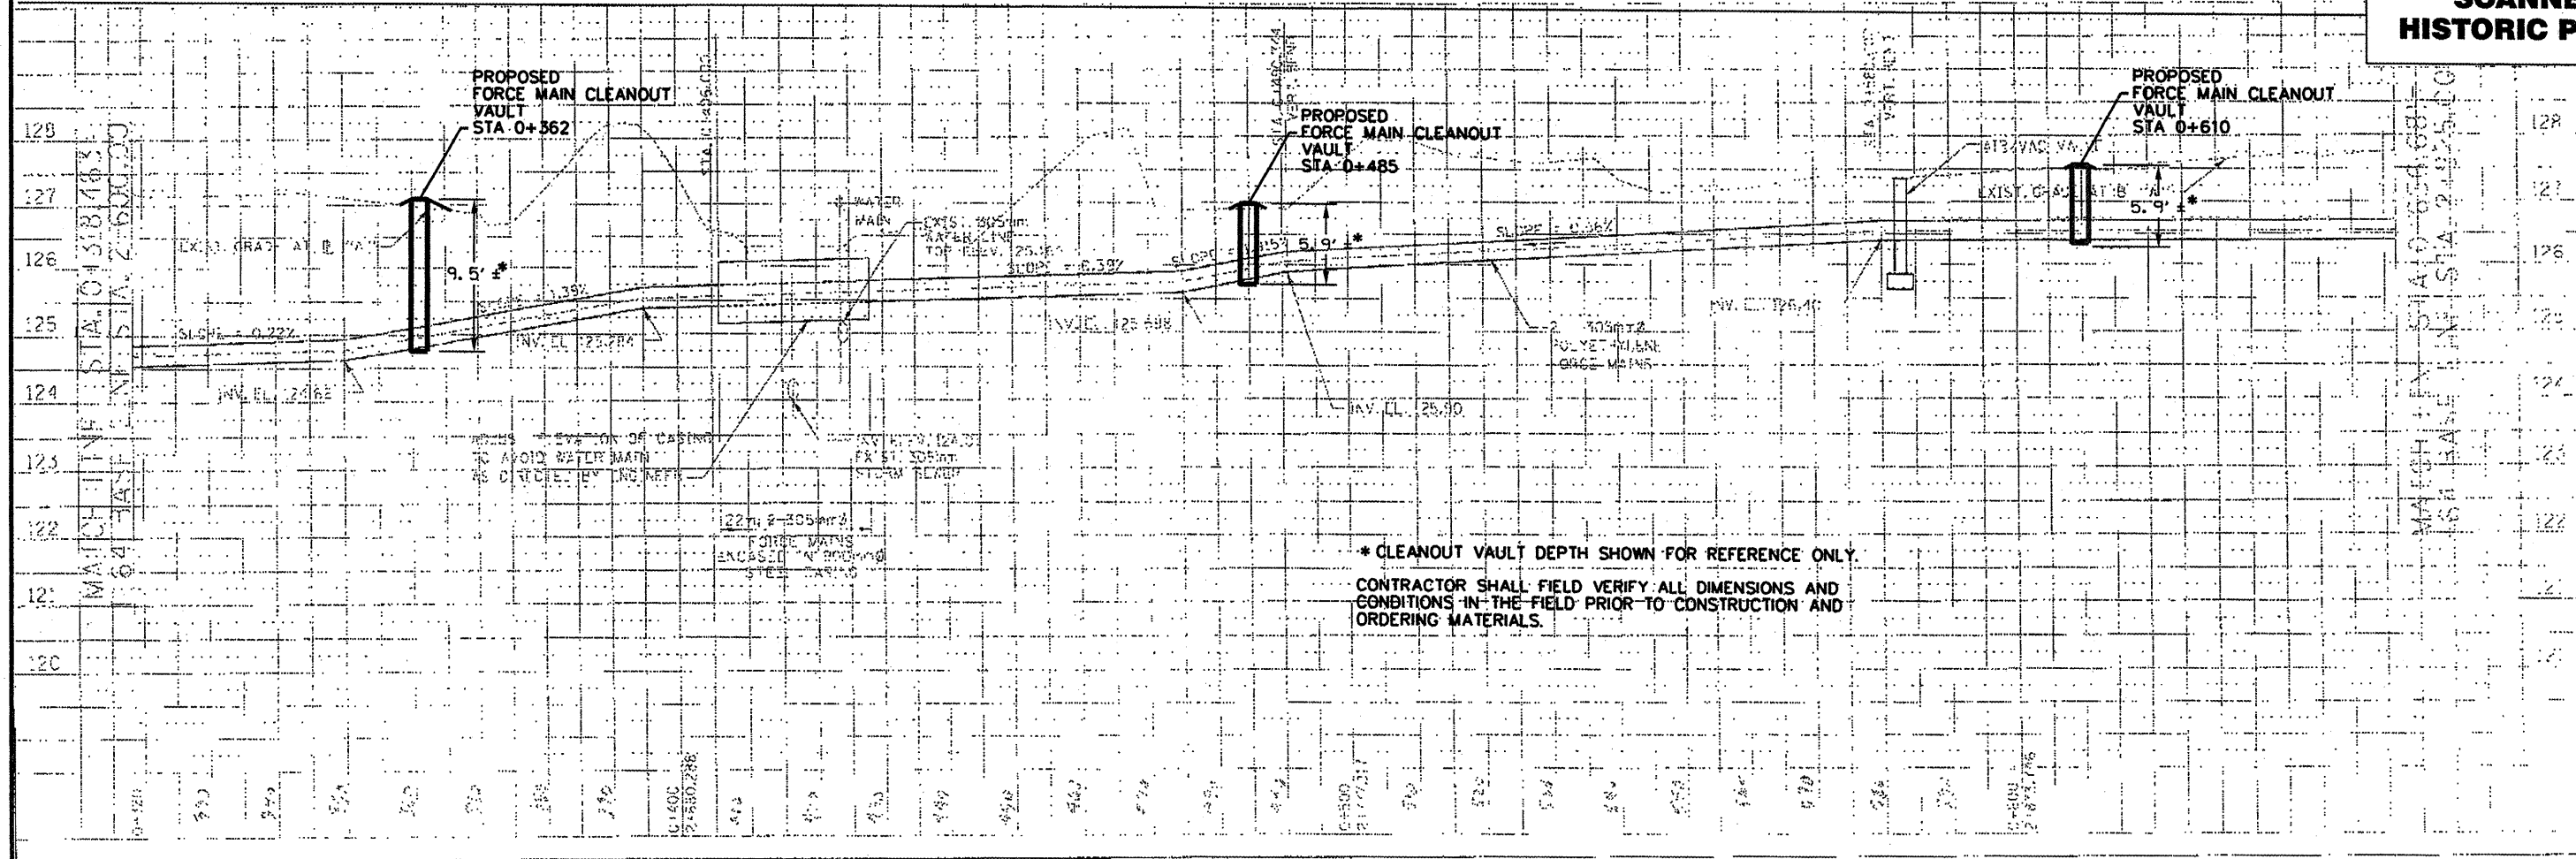

\* CLEANOUT VAULT DEPTH SHOWN FOR REFERENCE ONLY.  
CONTRACTOR SHALL FIELD VERIFY ALL DIMENSIONS AND  
CONDITIONS IN THE FIELD PRIOR TO CONSTRUCTION AND  
ORDERING MATERIALS.

FILE NAME	USER NAME	DESIGNED	REVISED	STATE OF ILLINOIS DEPARTMENT OF TRANSPORTATION	PLAN AND PROFILE CLEANOUT INSTALLATION 25TH STREET	F.A.P. RTE.	SECTION	COUNTY	TOTAL SHEETS	SHEET NO.
#FILE#	#USER#	DRAWN	REVISED			VARIOUS/DIST 8 DEEP WELLS 2010-2	ST. CLAIR	20	6	
PLOT SCALE	#SCALE#	CHECKED	REVISED			SCALE: 500 H / 50 V SHEET NO. 6 OF ... SHEETS		CONTRACT NO. T6062		
PLOT DATE	#DATE#	DATE	REVISED			STA. 0+38.463 TO STA. 0+656.681		ILLINOIS FED. AID PROJECT		