
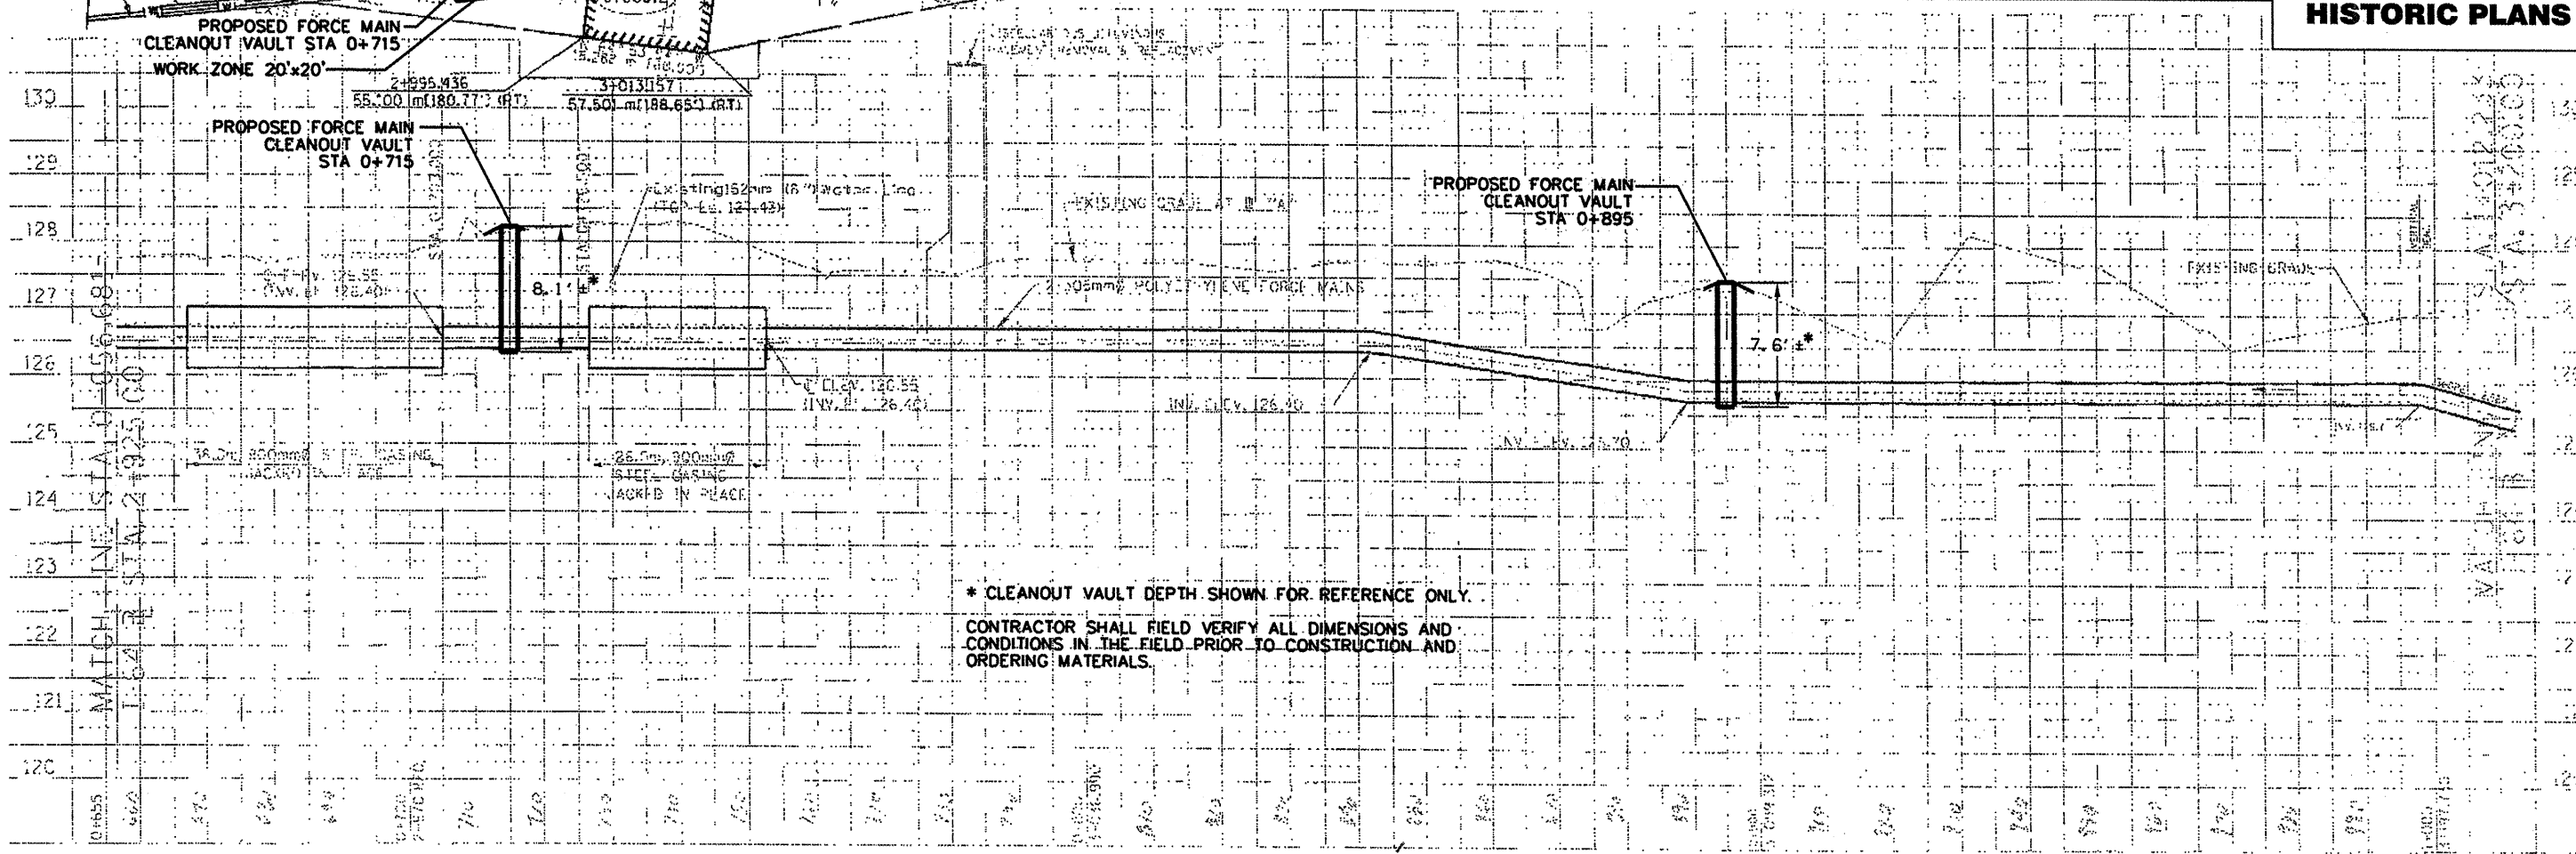


**SCANNED
HISTORIC PLANS**

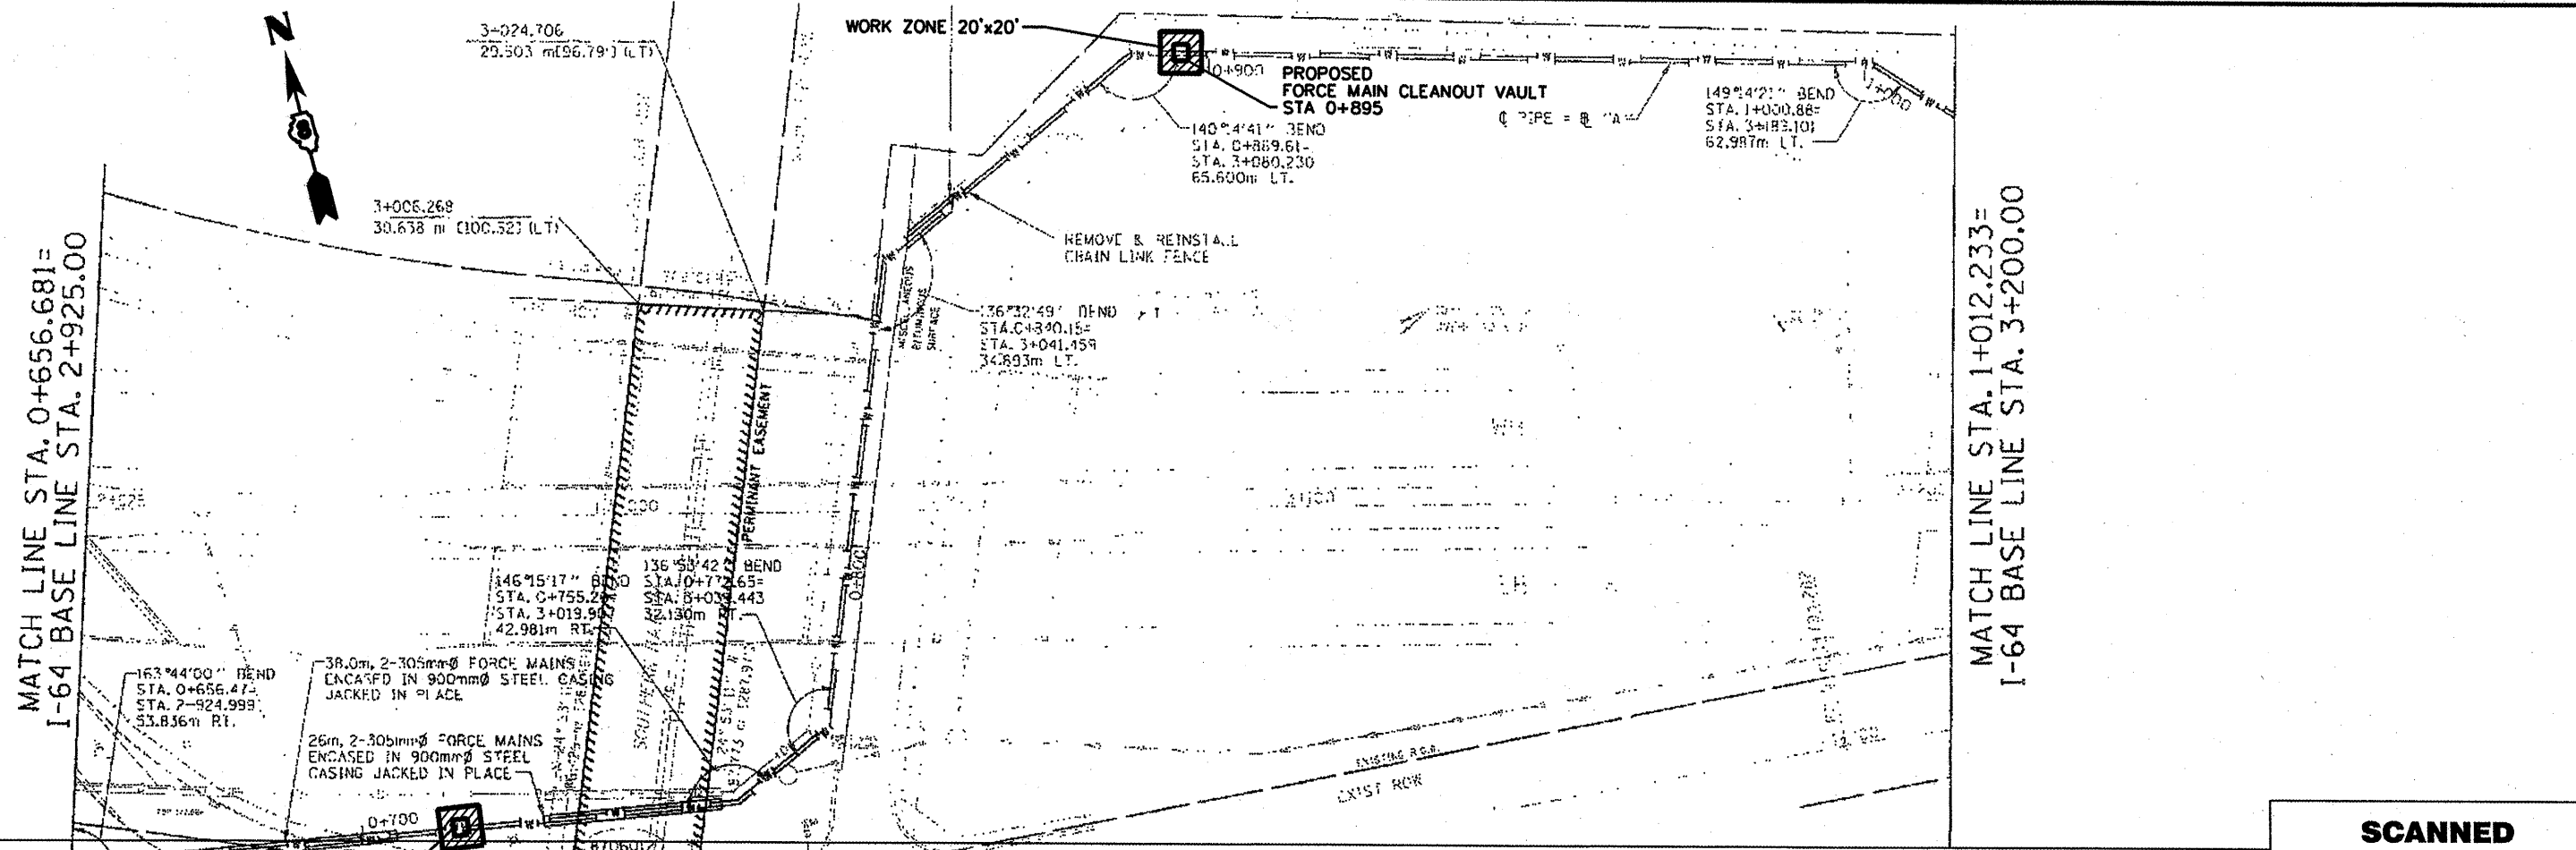

* CLEANOUT VAULT DEPTH SHOWN FOR REFERENCE ONLY.
CONTRACTOR SHALL FIELD VERIFY ALL DIMENSIONS AND
CONDITIONS IN THE FIELD PRIOR TO CONSTRUCTION AND
ORDERING MATERIALS.

FILE NAME #FILE#	USER NAME #USER#	DESIGNED EJC	REVISED	STATE OF ILLINOIS DEPARTMENT OF TRANSPORTATION	PLAN AND PROFILE CLEANOUT INSTALLATION 25TH STREET	F.A.P. RTE.	SECTION	COUNTY	TOTAL SHEETS	SHEET NO.
	PLOT SCALE #SCALE#	DRAWN JLA	REVISED			VARIOUS/DIST B DEEP WELLS 2010-2	ST. CLAR	20	7	
	CHECKED EJA	REVISOR	REVISED			CONTRACT NO. 76062				
	DATE 05/06/10	REVISED	REVISED			ILLINOIS FED. AID PROJECT				

SCALE: 500 H / 50 V SHEET NO. 7 OF .. SHEETS STA. 0+656.681 TO STA. 1+012.233