 



NOTE:
UNDERPASS LIGHTING FOR BOTH TEMPORARY AND PROPOSED
USE IS STAGE INDEPENDENT.

 
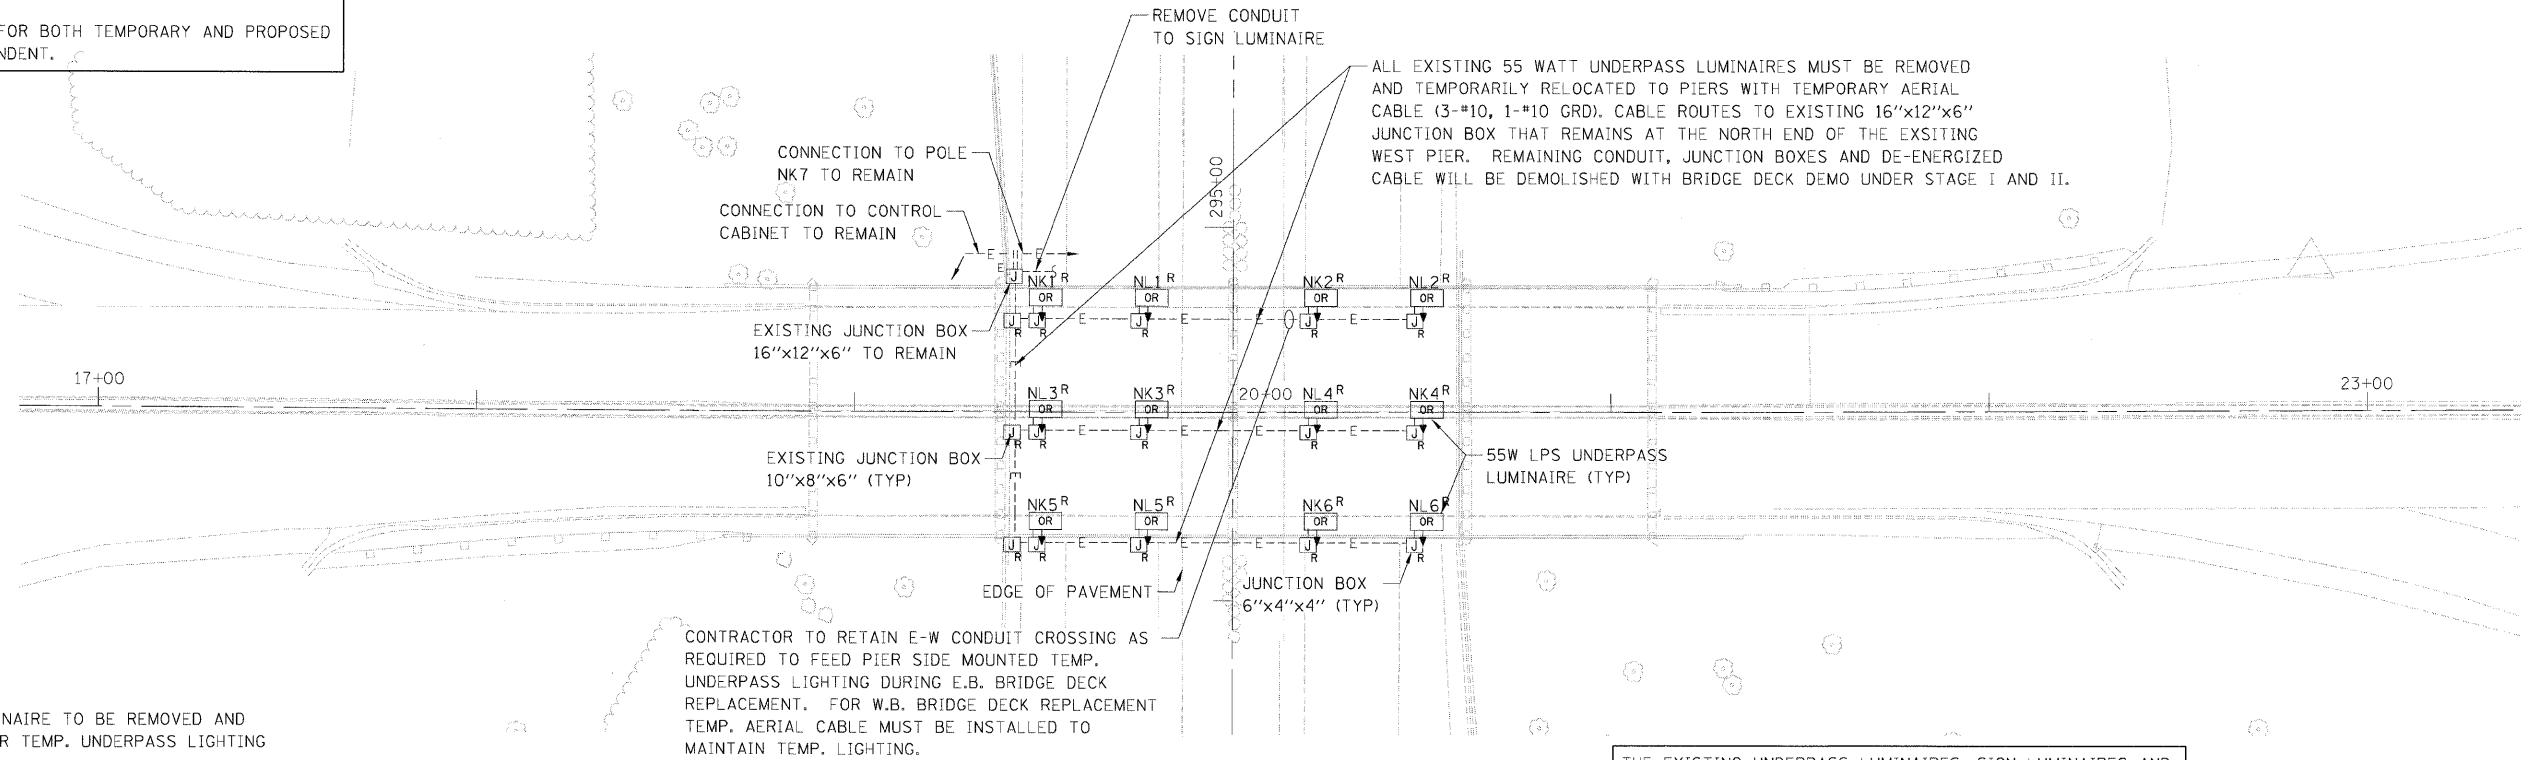


LEGEND
 [OR] EXISTING LUMINAIRE TO BE REMOVED AND RELOCATED FOR TEMP. UNDERPASS LIGHTING
 [J]_R EXISTING JUNCTION BOX TO BE REMOVED UNLESS NOTED OTHERWISE
 ---E--- EXISTING CONDUIT/CABLE TO BE REMOVED

CONTRACTOR TO RETAIN E-W CONDUIT CROSSING AS REQUIRED TO FEED PIER SIDE MOUNTED TEMP. UNDERPASS LIGHTING DURING E.B. BRIDGE DECK REPLACEMENT. FOR W.B. BRIDGE DECK REPLACEMENT TEMP. AERIAL CABLE MUST BE INSTALLED TO MAINTAIN TEMP. LIGHTING.

UNDERPASS LIGHTING REMOVAL

THE EXISTING UNDERPASS LUMINAIRES, SIGN LUMINAIRES AND LIGHT POLES THAT ARE REMOVED SHALL BE SALVAGED TO IDOT AND DELIVERED TO A DESIGNATION DETERMINED BY THE ENGINEER.

 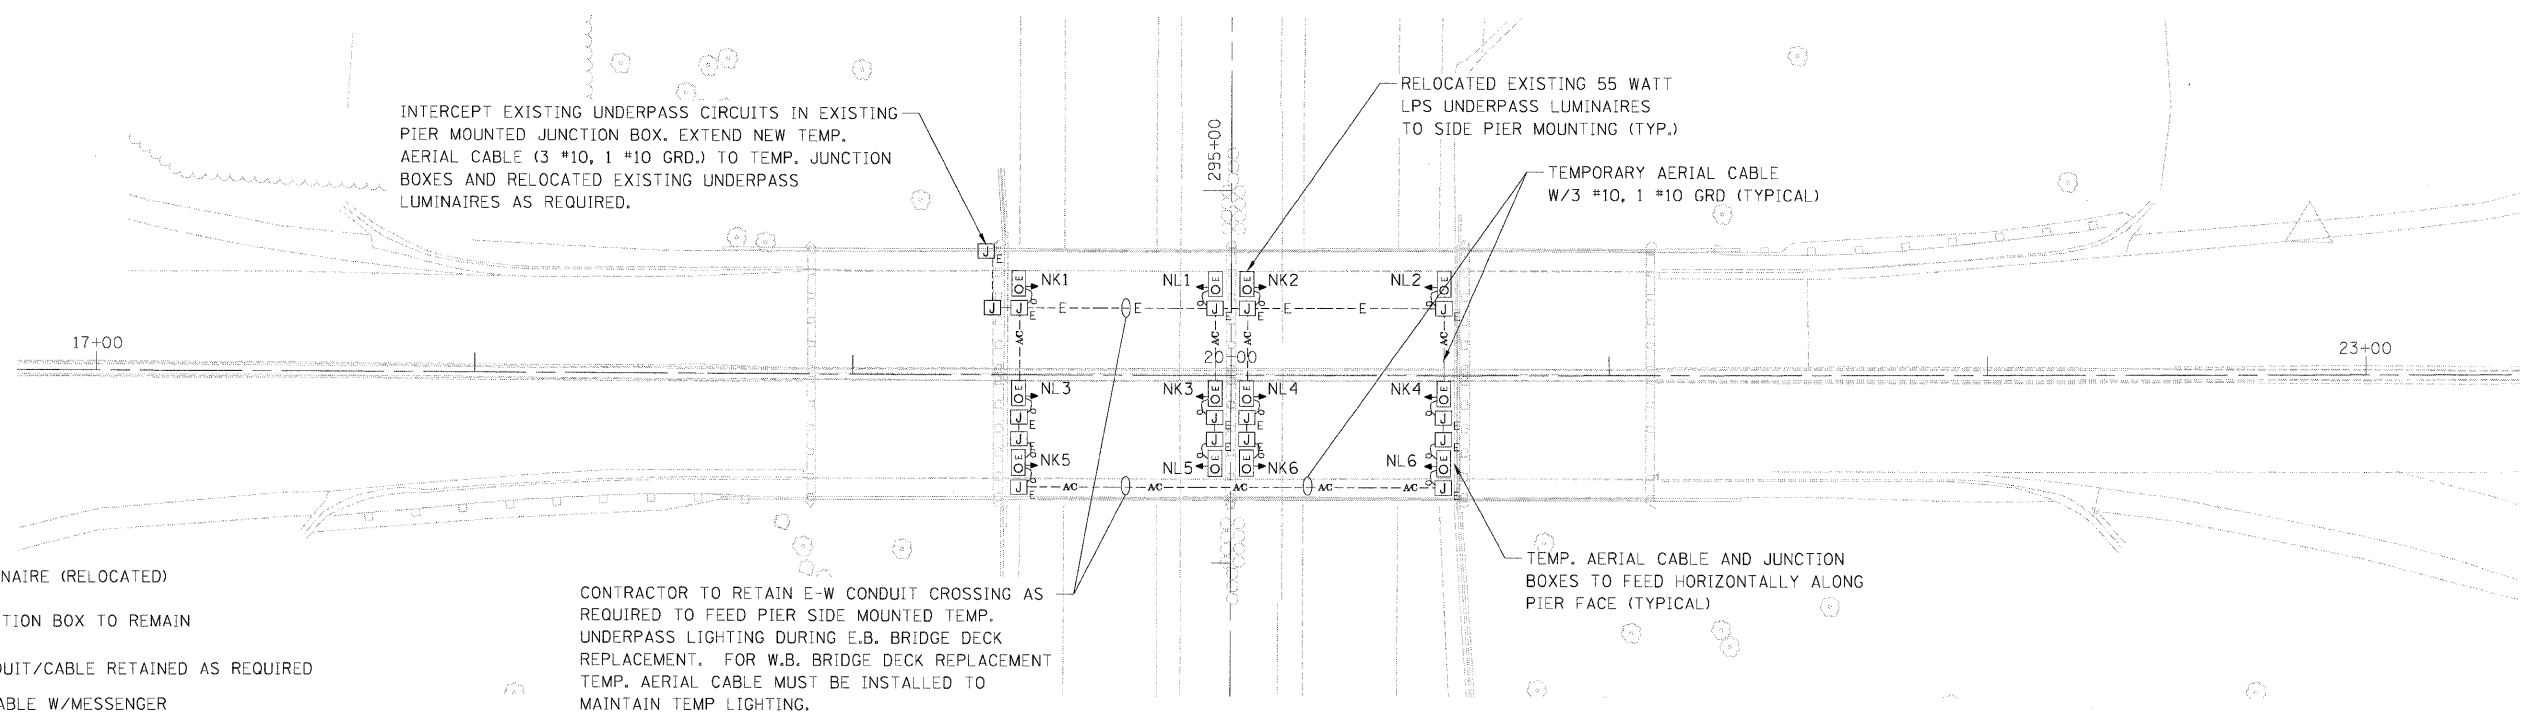


LEGEND
 [OE] EXISTING LUMINAIRE (RELOCATED)
 [J]_E EXISTING JUNCTION BOX TO REMAIN
 ---E--- EXISTING CONDUIT/CABLE RETAINED AS REQUIRED
 ---AC--- NEW AERIAL CABLE W/MESSENGER

CONTRACTOR TO RETAIN E-W CONDUIT CROSSING AS REQUIRED TO FEED PIER SIDE MOUNTED TEMP. UNDERPASS LIGHTING DURING E.B. BRIDGE DECK REPLACEMENT. FOR W.B. BRIDGE DECK REPLACEMENT TEMP. AERIAL CABLE MUST BE INSTALLED TO MAINTAIN TEMP LIGHTING.

TEMPORARY UNDERPASS LIGHTING

THE EXISTING UNDERPASS LUMINAIRES, SIGN LUMINAIRES AND LIGHT POLES THAT ARE REMOVED SHALL BE SALVAGED TO IDOT AND DELIVERED TO A DESIGNATION DETERMINED BY THE ENGINEER.



BOWMAN, BARRETT & ASSOCIATES INC.
 CONSULTING ENGINEERS
 Chicago, Illinois
 312.228.0100
 www.bbainc.com

FILE NAME = D168C05-shr-und-stgl.dgn	USER NAME = default	DESIGNED - RR	REVISED -	STATE OF ILLINOIS DEPARTMENT OF TRANSPORTATION	STAGE I EXISTING AND TEMPORARY UNDERPASS LIGHTING PLAN US 30 OVER IL RTE. 394	F.A. RTE. 0353	SECTION 0303.1B-1	COUNTY COOK	TOTAL SHEETS 91	SHEET NO. 36		
PLOT SCALE = #SCALE#	CHECKED - DF	REVISIED -	SCALE: 1" = 25'			SHEET NO. 3 OF 12 SHEETS	STA. 17+00.00 TO STA. 23+00.00	CONTRACT NO. 60C05				
PLOT DATE = 5/6/2009	DATE - 5/6/2009	REVISIED -	FED. ROAD DIST. NO. ILLINOIS FED. AID PROJECT									