



F.A.I. RTE.	SECTION	COUNTY	TOTAL SHEETS	SHEET NO.
90/94		COOK	45	26
STA. 8220+23.67 TO STA. 8222+75				
FED. ROAD DIST. NO. 1 ILLINOIS FED. AID PROJECT				
•(1818, 1919, 1919.15) I-11 62983				

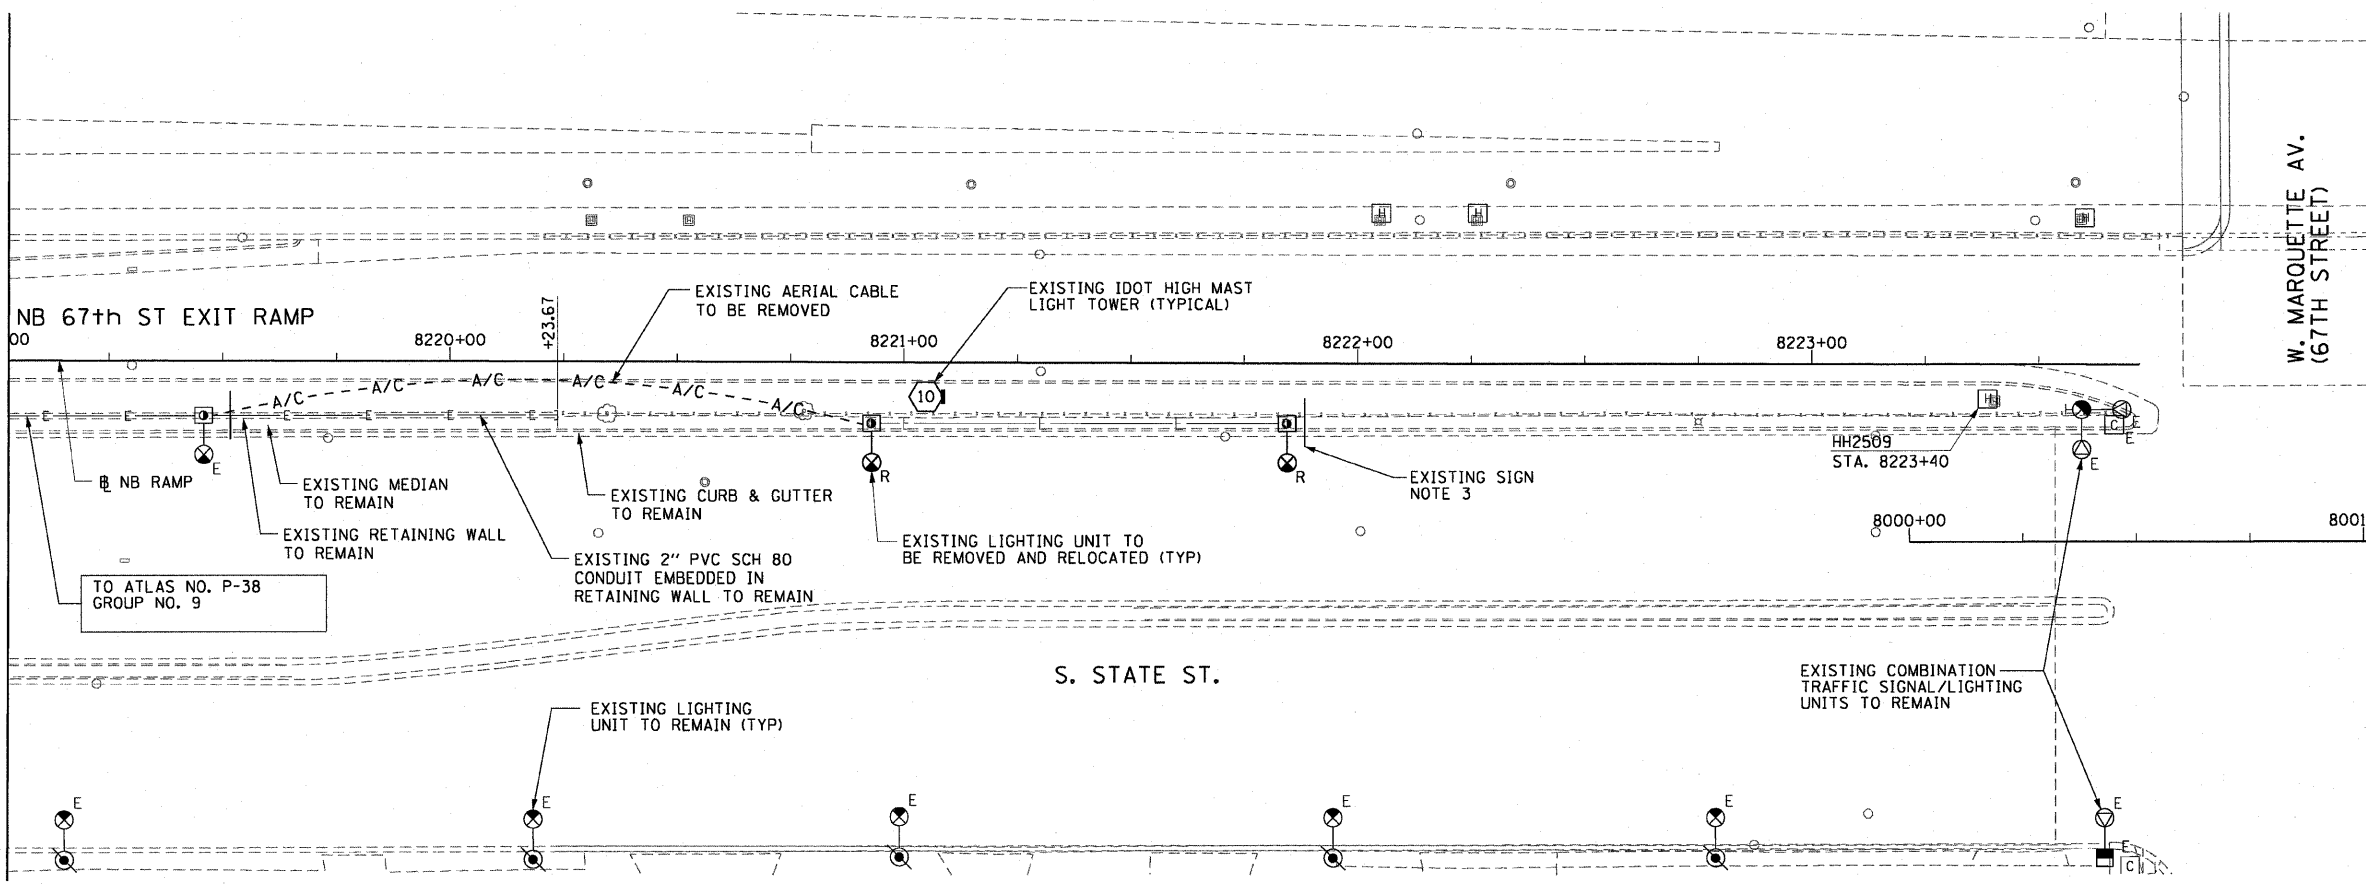

EXISTING CONDUIT/DEMOLITION PLAN

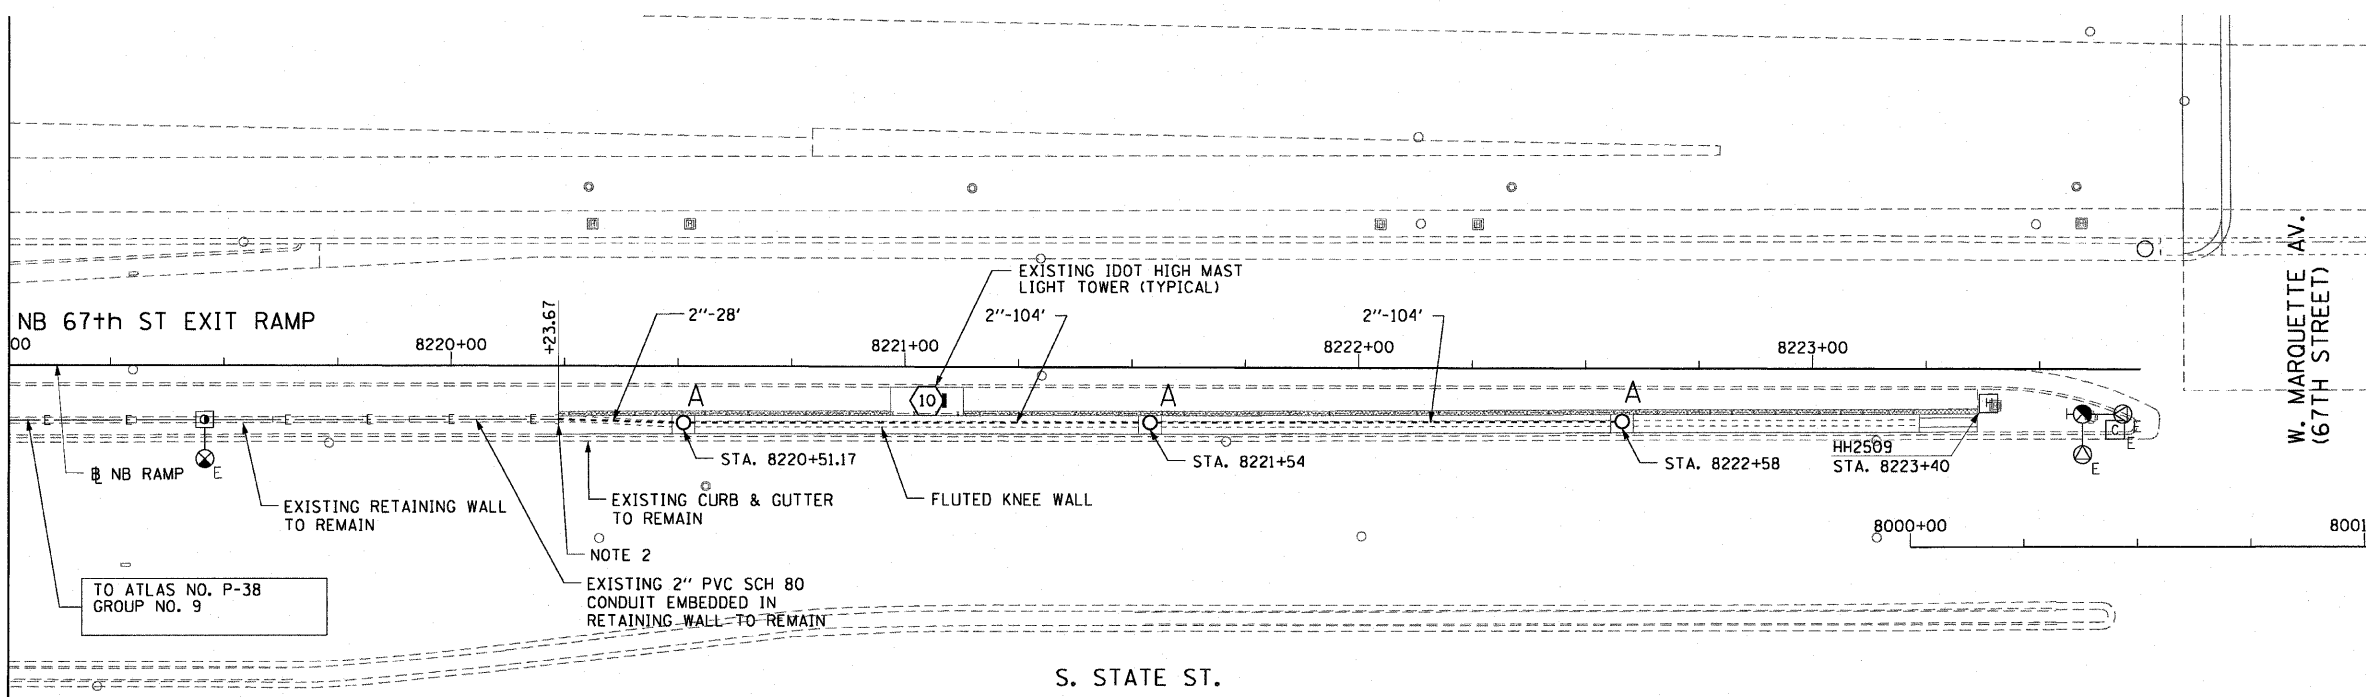

PROPOSED CONDUIT AND FOUNDATION PLAN

- NOTES:**
1. SEE DRAWINGS E-1 AND E-2 FOR GENERAL NOTES SYMBOLS AND ABBREVIATIONS.
 2. INTERCEPT EXISTING RACEWAY AND EXTEND TO WALL MOUNTED LIGHTING UNIT. (2" PVC SCH 80 EMBEDDED IN WALL).
 3. REGULATORY SIGNS ATTACHED TO LIGHT POLES SHALL BE INVENTORIED, REMOVED AND STORED BY THE CONTRACTOR FOR REINSTALLATION ON RELOCATED LIGHT POLES.

A- FOUNDATION INTEGRAL WITH KNEE WALL SEE STRUCTURAL DRAWINGS. 10" B.C., 1/4" ANCHOR RODS
 2" CONDUIT BETWEEN FOUNDATIONS SHALL BE SCHEDULE 80 PVC EMBEDDED IN KNEE WALL



REVISIONS	
NAME	DATE

ILLINOIS DEPARTMENT OF TRANSPORTATION
 F.A.I. 90/94 (DAN RYAN EXPRESSWAY)
 71ST ST TO 63RD ST (NORTHBOUND KNEE WALLS)

**EXISTING PLAN
 PROPOSED CONDUIT AND
 FOUNDATION PLAN**

SCALE: 1"=20'
 DATE: JANUARY 14, 2009

DRAWN BY: JCM
 CHECKED BY: JPC

AECOM

E-3
 1/13/2009 11:34:40 AM