


F.A.U. RTE.	SECTION	COUNTY	TOTAL SHEETS	SHEET NO.
	97-0084-00-BR	DUPAGE	241	66
STA. 11+00		TO STA. 16+00		
FED. ROAD DIST. NO.		ILLINOIS FED. AID PROJECT		
CONTRACT NO. 83908				



DATE	BY
DATE	BY
DATE	BY

DATE	BY
DATE	BY
DATE	BY

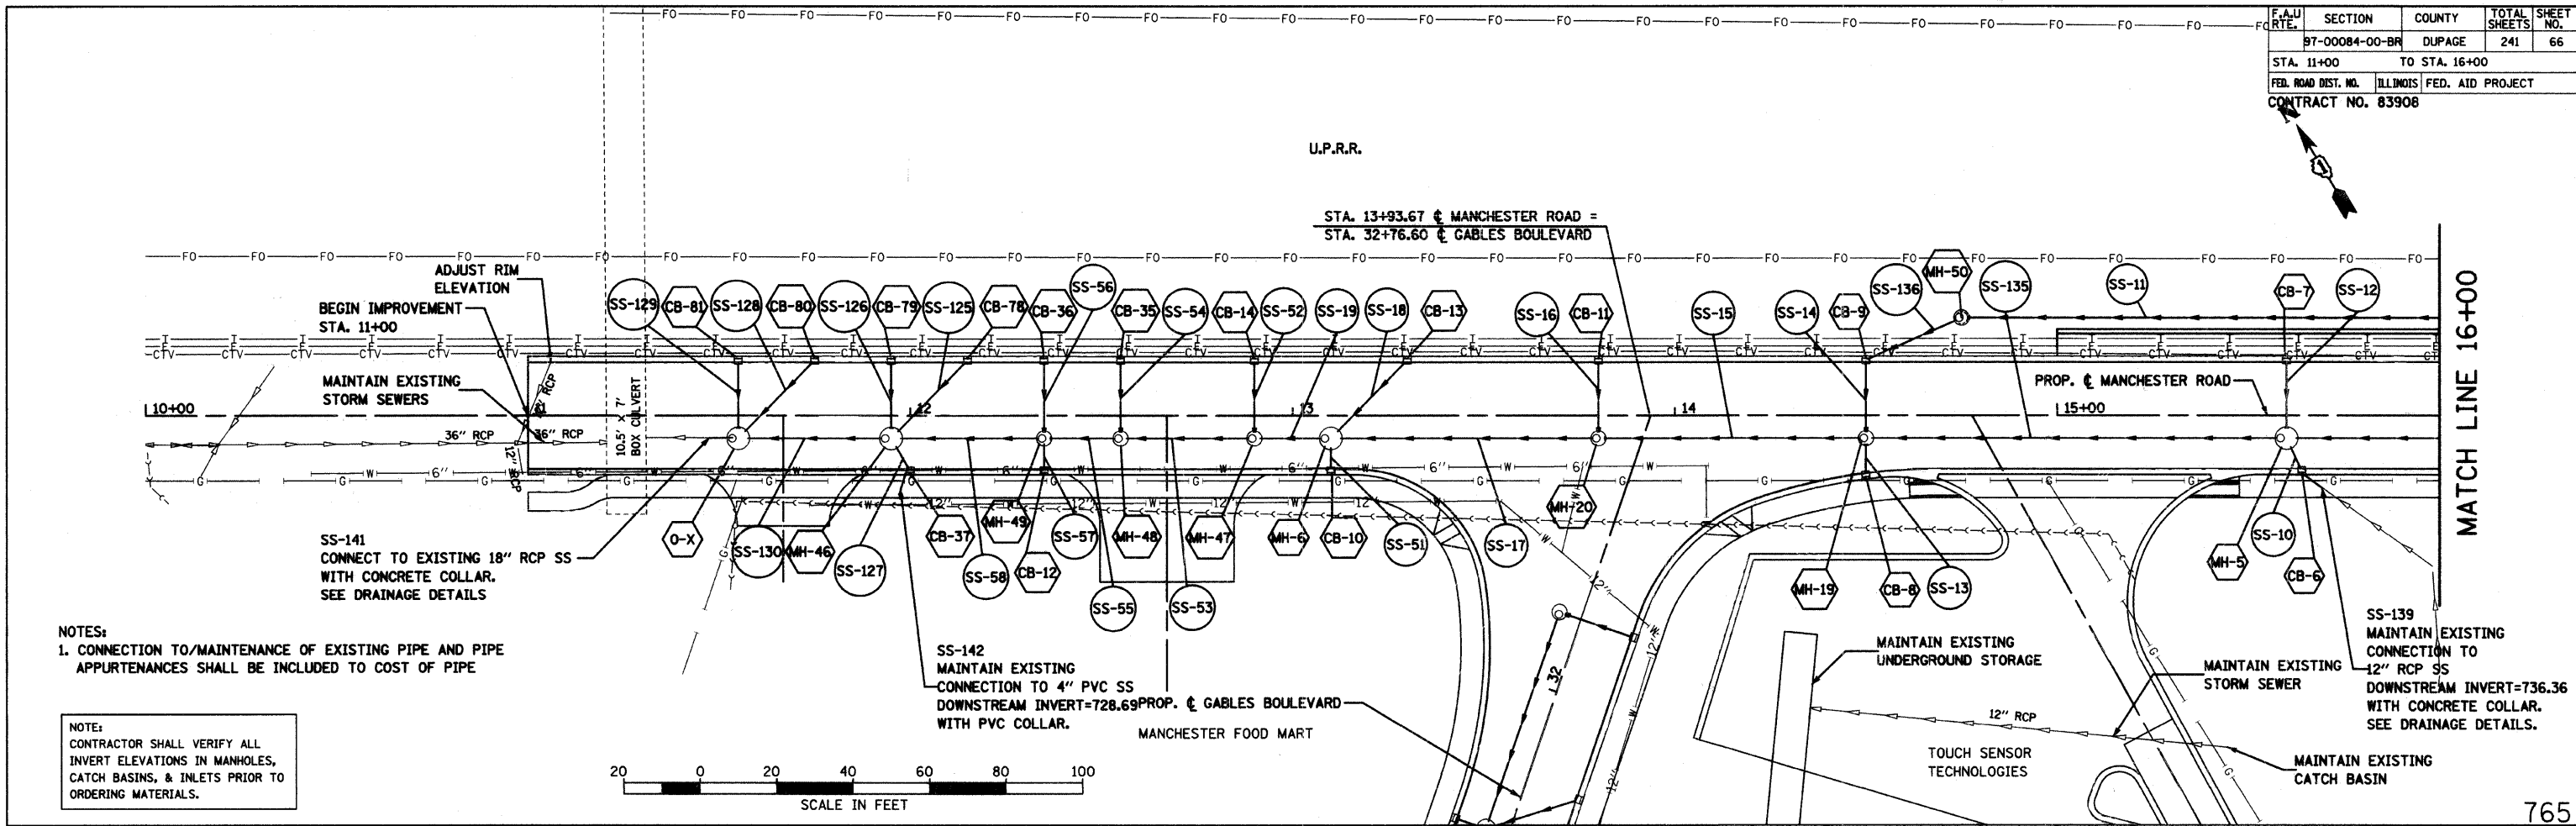

NOTES:  
1. CONNECTION TO/MAINTENANCE OF EXISTING PIPE AND PIPE APPURTENANCES SHALL BE INCLUDED TO COST OF PIPE

 NOTE:  
CONTRACTOR SHALL VERIFY ALL INVERT ELEVATIONS IN MANHOLES, CATCH BASINS, & INLETS PRIOR TO ORDERING MATERIALS.

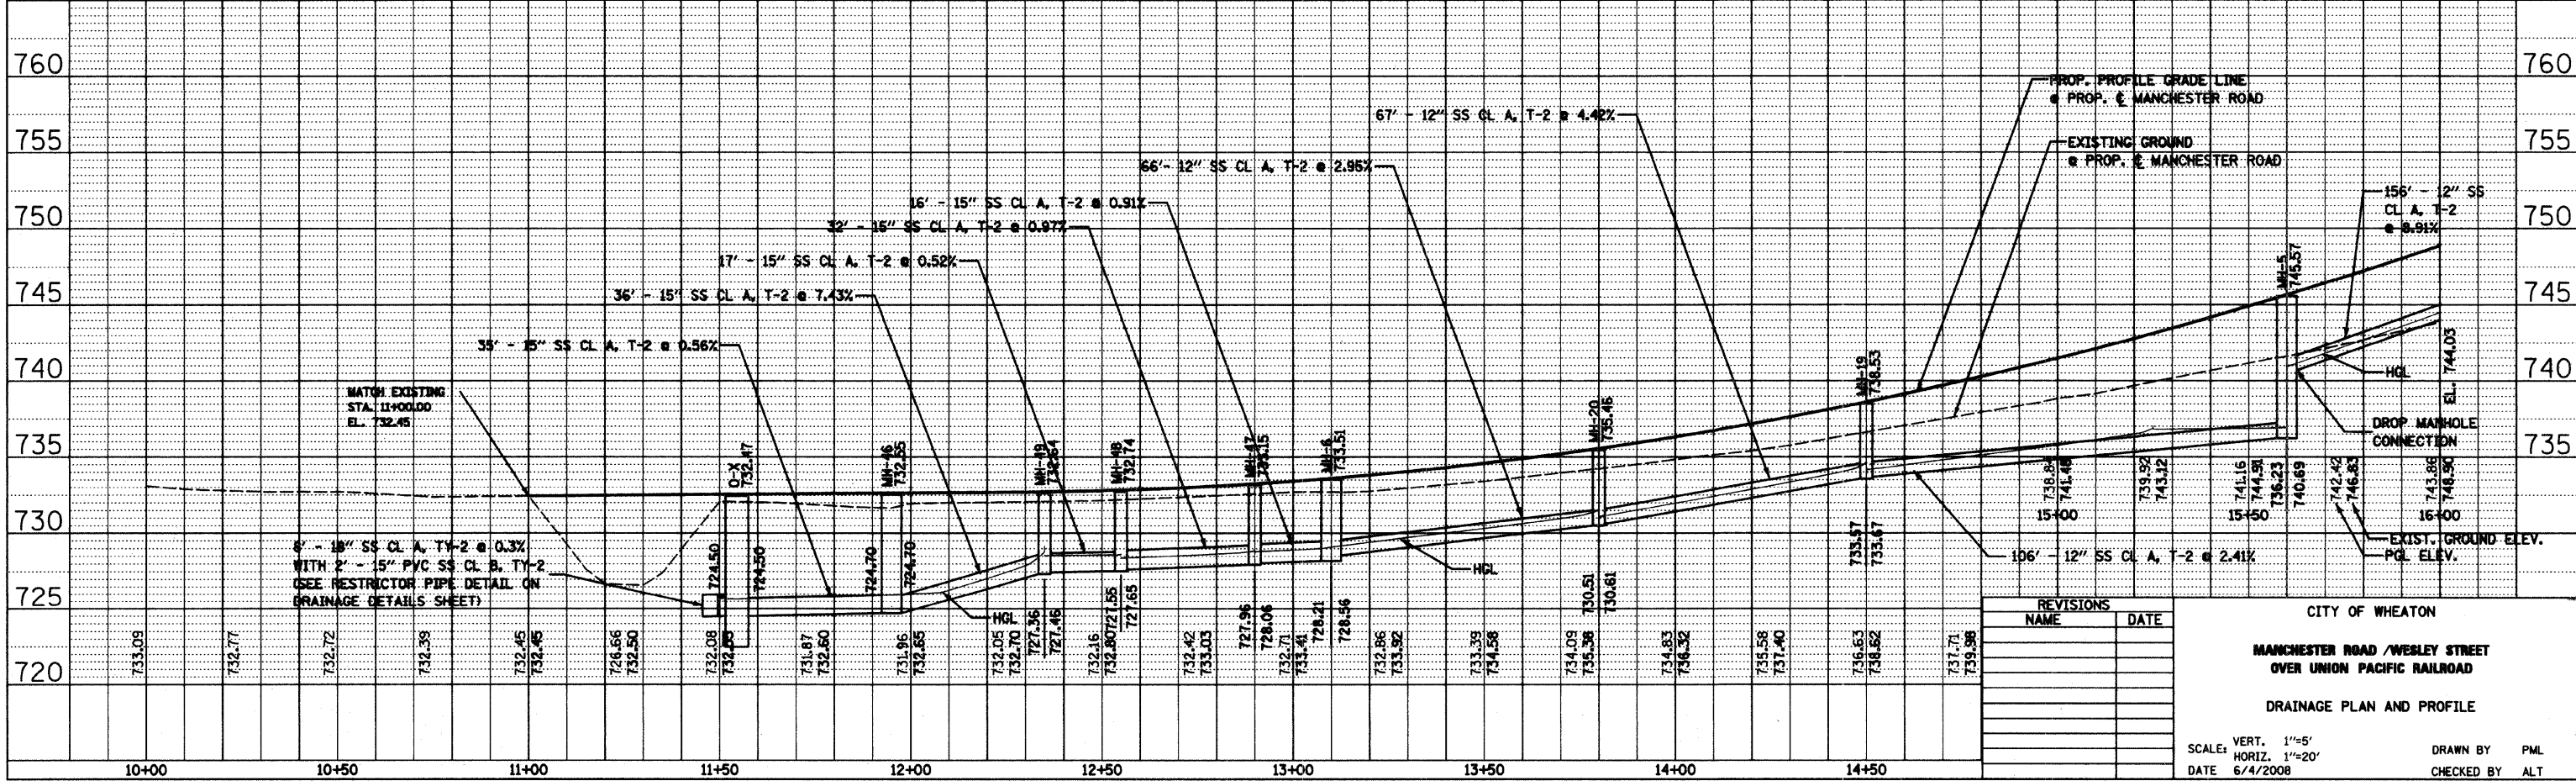

REVISIONS	
NAME	DATE

CITY OF WHEATON  
**MANCHESTER ROAD /WESLEY STREET  
OVER UNION PACIFIC RAILROAD**  
DRAINAGE PLAN AND PROFILE  
SCALE: VERT. 1"=5'  
HORIZ. 1"=20'  
DATE 6/4/2008  
DRAWN BY PML  
CHECKED BY ALT