


PLAN	SURVEYED	DATE
	NOTED	
	CHECKED	
	BY	
	NO.	


PROFILE	SURVEYED	DATE
	NOTED	
	CHECKED	
	BY	
	NO.	

F.A.U. SECTION COUNTY TOTAL SHEET				
RTE. 97-00084-00-BR DUPAGE ILLINOIS AID PROJECT			241	72
STA. 60+00 TO STA. 65+40				
CONTRACT NO. 83908				

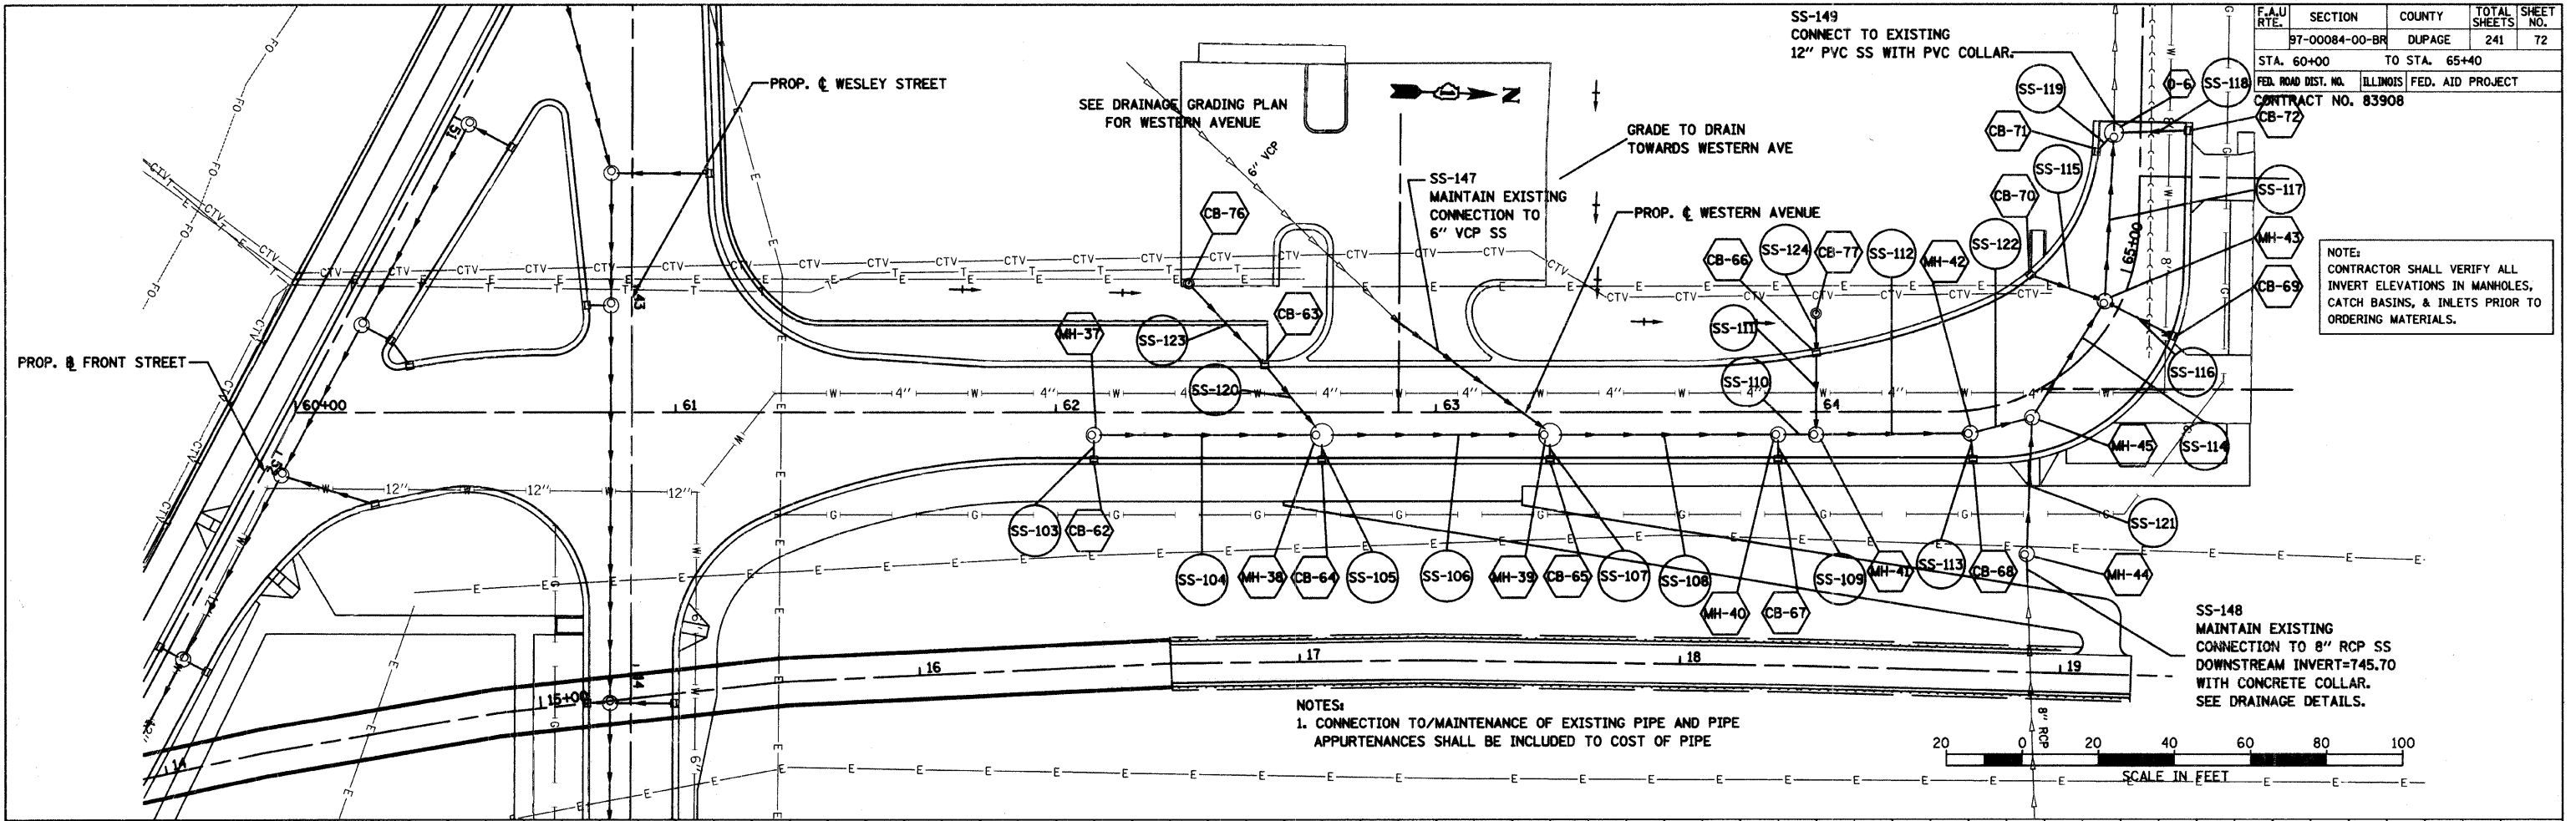

NOTES:  
1. CONNECTION TO/MAINTENANCE OF EXISTING PIPE AND PIPE APPURTENANCES SHALL BE INCLUDED TO COST OF PIPE

NOTE:  
CONTRACTOR SHALL VERIFY ALL INVERT ELEVATIONS IN MANHOLES, CATCH BASINS, & INLETS PRIOR TO ORDERING MATERIALS.

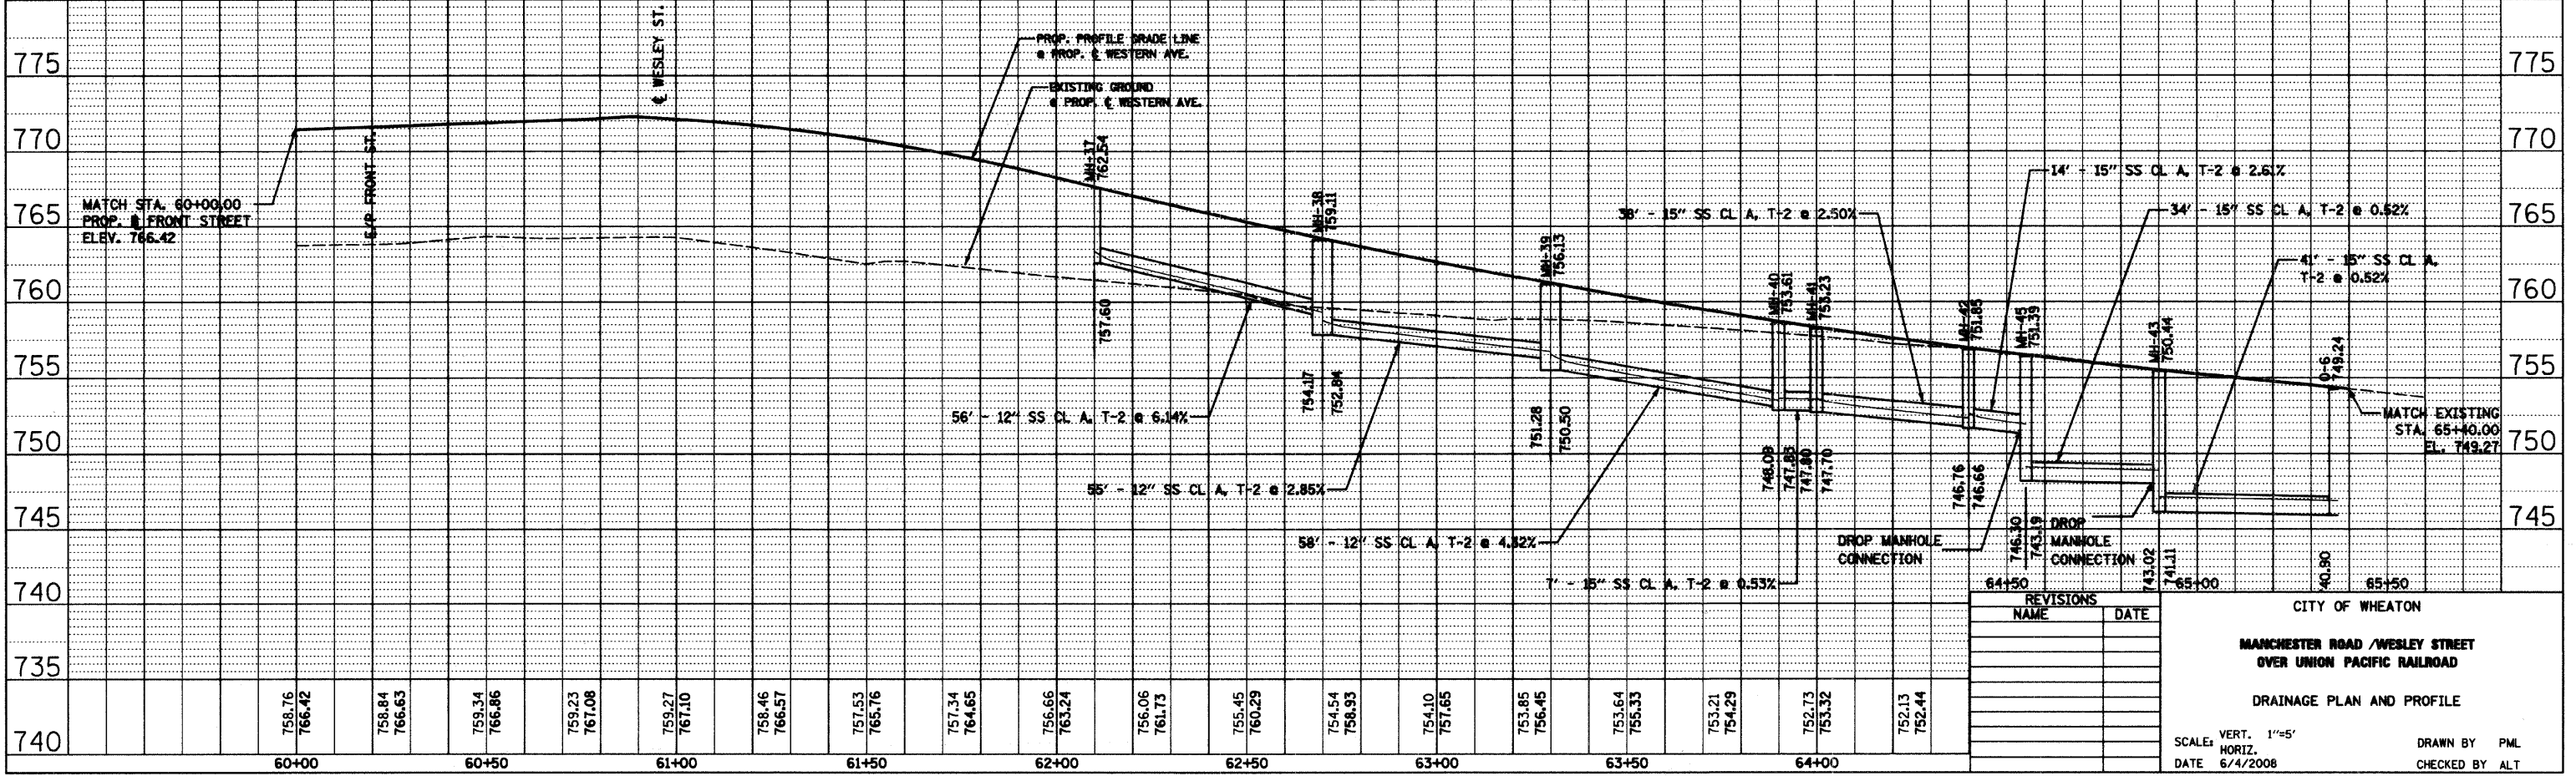

REVISIONS	
NAME	DATE

CITY OF WHEATON  
MANCHESTER ROAD / WESLEY STREET  
OVER UNION PACIFIC RAILROAD  
DRAINAGE PLAN AND PROFILE  
SCALE: VERT. 1"=5'  
HORIZ. DATE 6/4/2008  
DRAWN BY PML  
CHECKED BY ALT