

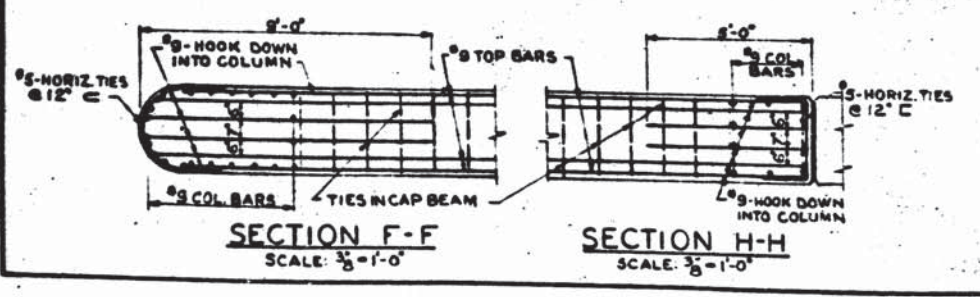
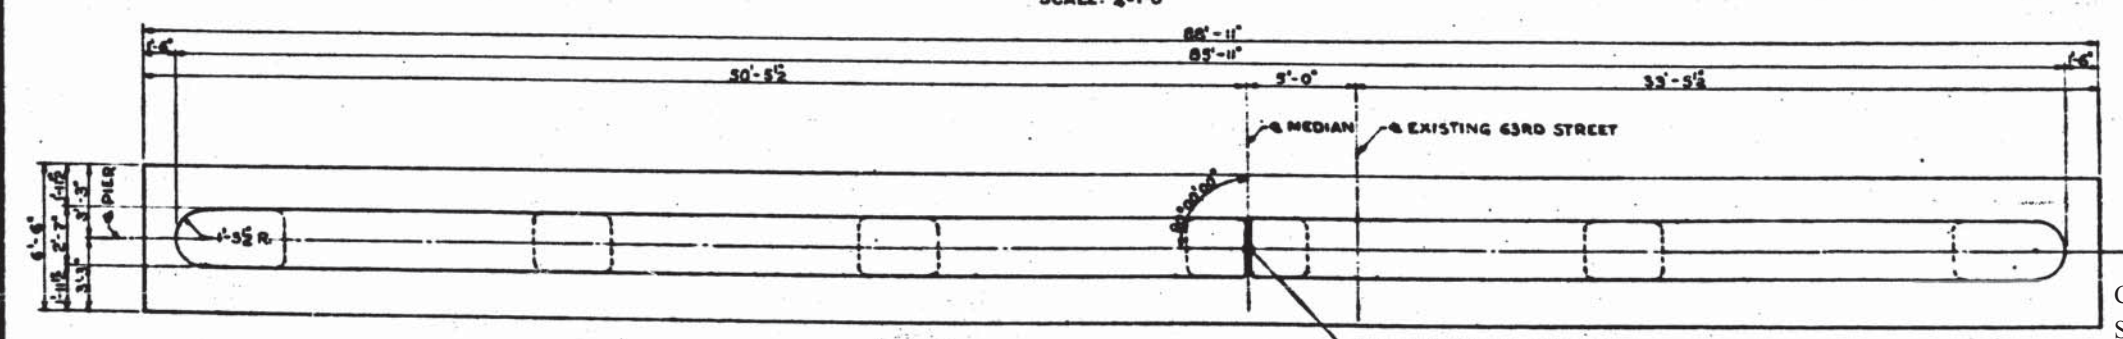
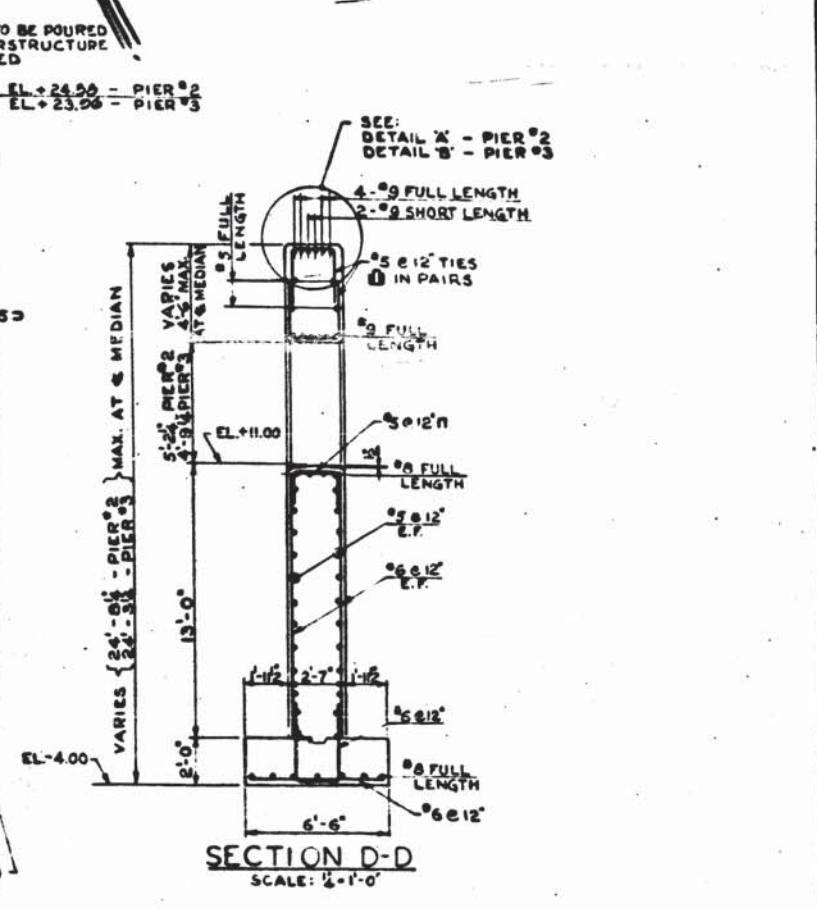


FOR INFORMATION ONLY

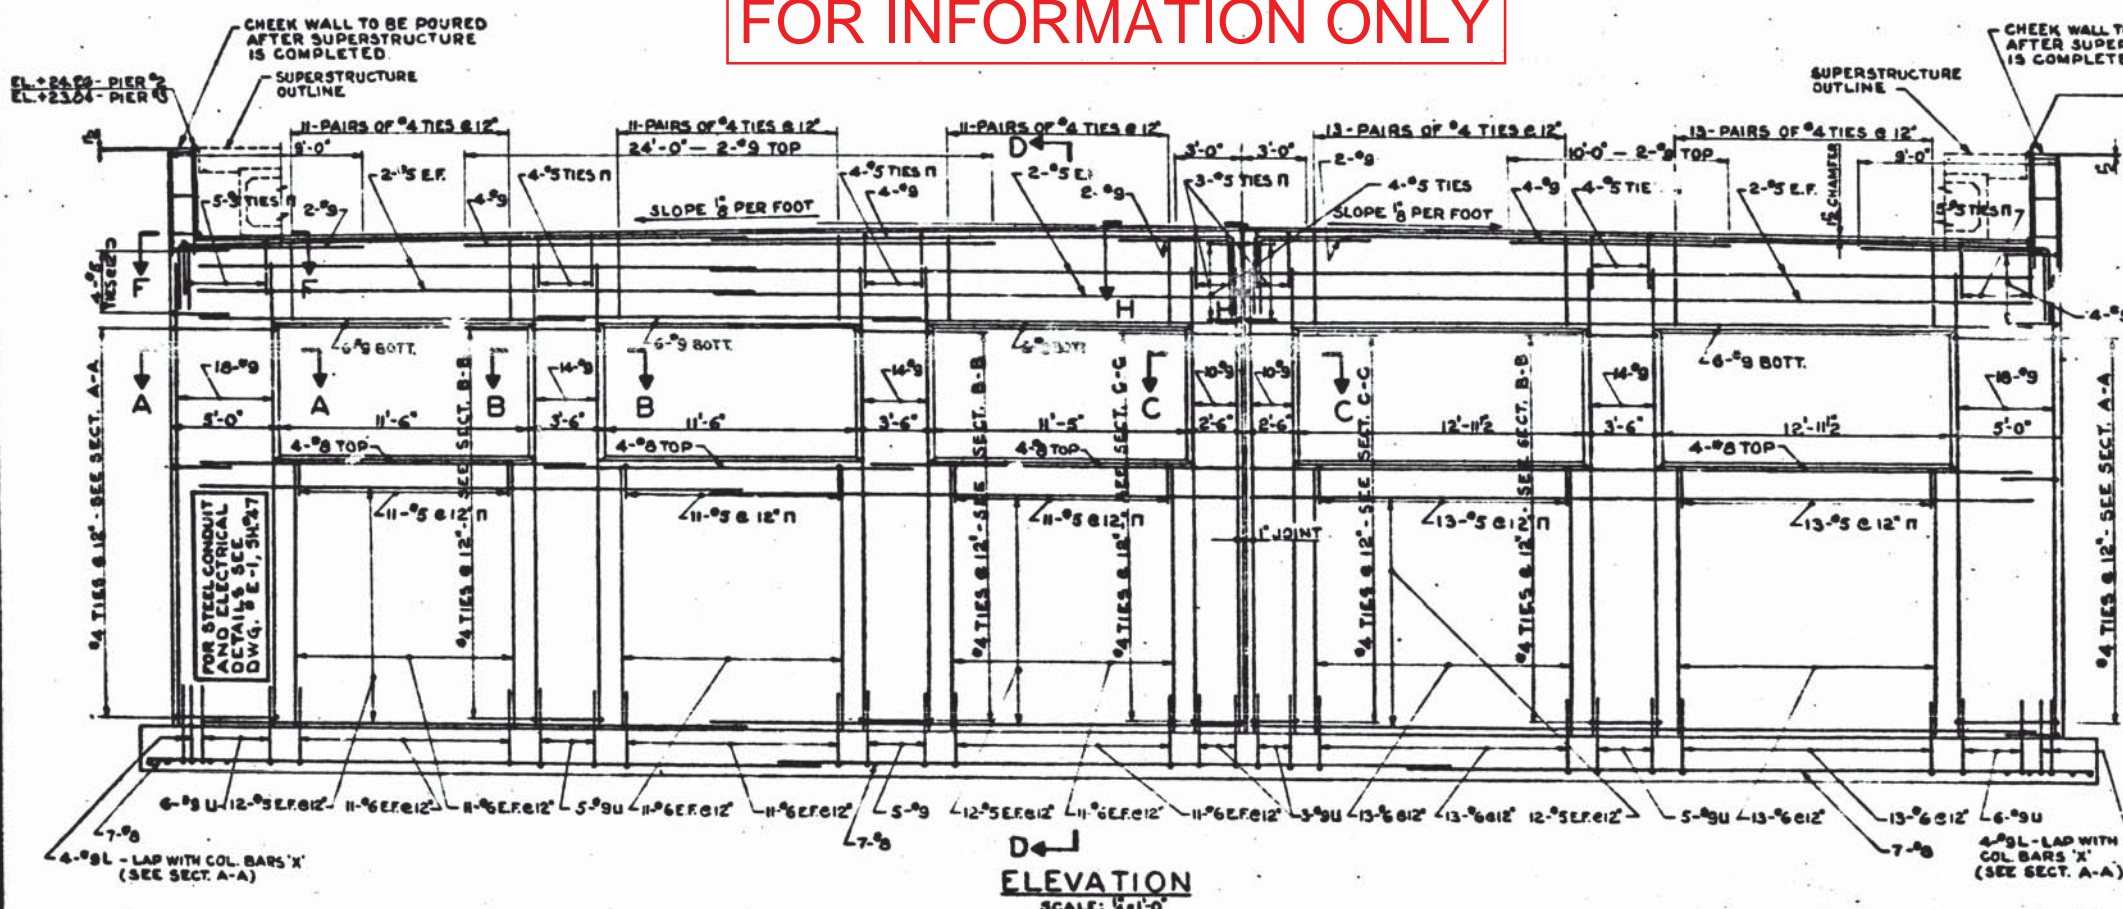

FOOTING PLAN SCALE: 1/8"=1'-0"

BILL OF MATERIAL				
ITEM	UNIT	PIER #2	PIER #3	
CLASS 'X' CONCRETE	CU YDS	197.0	196.0	
REINFORCEMENT BARS	LBS	24,700	24,700	

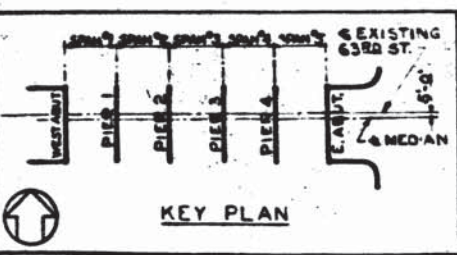

NOTES FOR ELECTRICAL DETAILS SEE SHEET NO. 47 & 48

REVISIONS		
DATE	BY	DESCRIPTION

CONTRACT NO. 60J15
SHEET NO. 117 OF 137

DEPARTMENT OF HIGHWAYS
COOK COUNTY, ILLINOIS

PIERS #2 & 3
63RD STREET GRADE SEPARATION
OVER
SOUTH ROUTE EXPRESSWAY

COMPUTED S.G. PROJECT 801-94-3(55)22
DRAWN L.R. SCALE AS SHOWN
CHECKED E.M.C. APPROVED [Signature]

APPROVED [Signature] F.A.I. COUNTY Highway Sheet No. Total Sheets Drawing No.
94 066-820-C.F. 8 48 S-7

DE LEUW, CATHY & COMPANY
CONSULTING ENGINEERS