
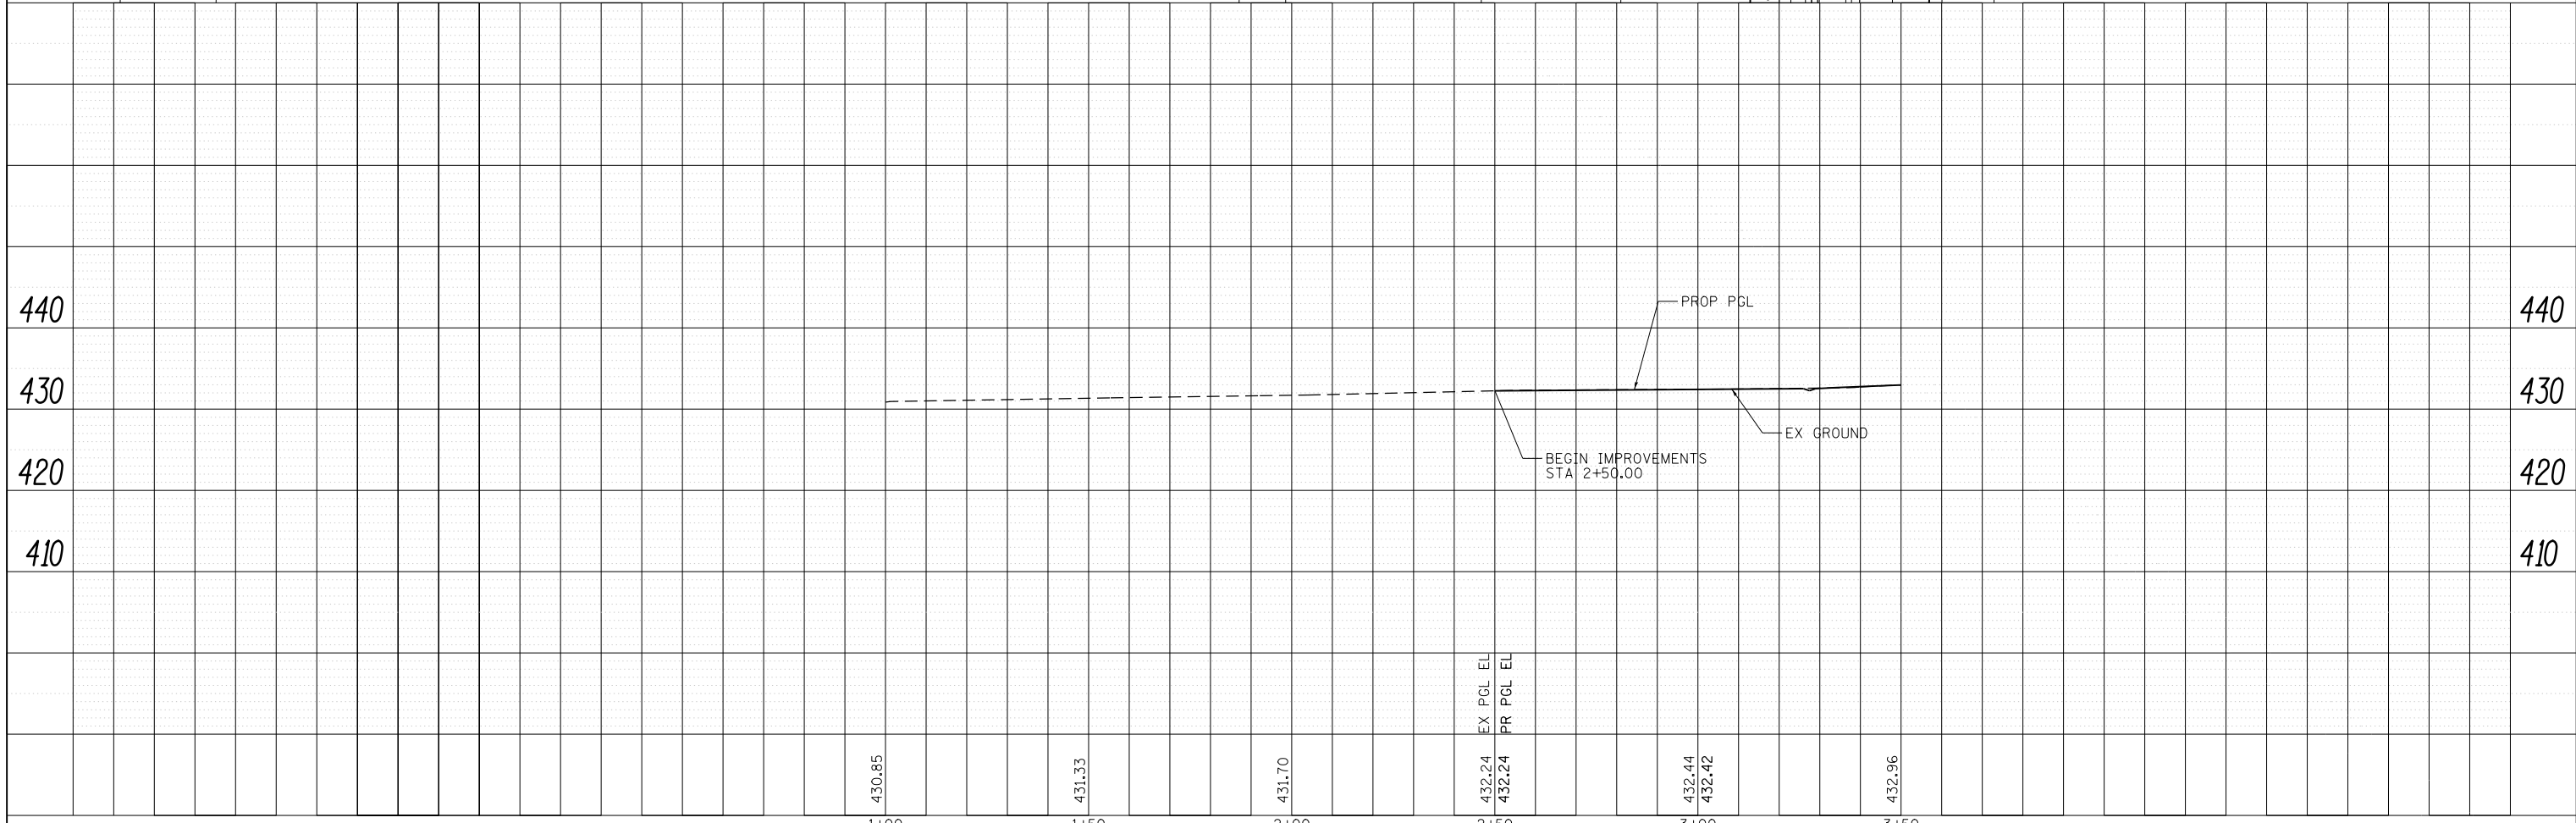


NOTES:

1. FOR STORM SEWER DETAILS, SEE DRAWING NO. DU-27.

PLAN	SURVEYED	DATE
NO.	PLOTTED	
	ALIGNMENT	
	CHECKED	
	BY	
	FILE NAME	

PROFILE	SURVEYED	DATE
NO.	PLOTTED	
	GRADES	
	CHECKED	
	BY	
	NOTATIONS	

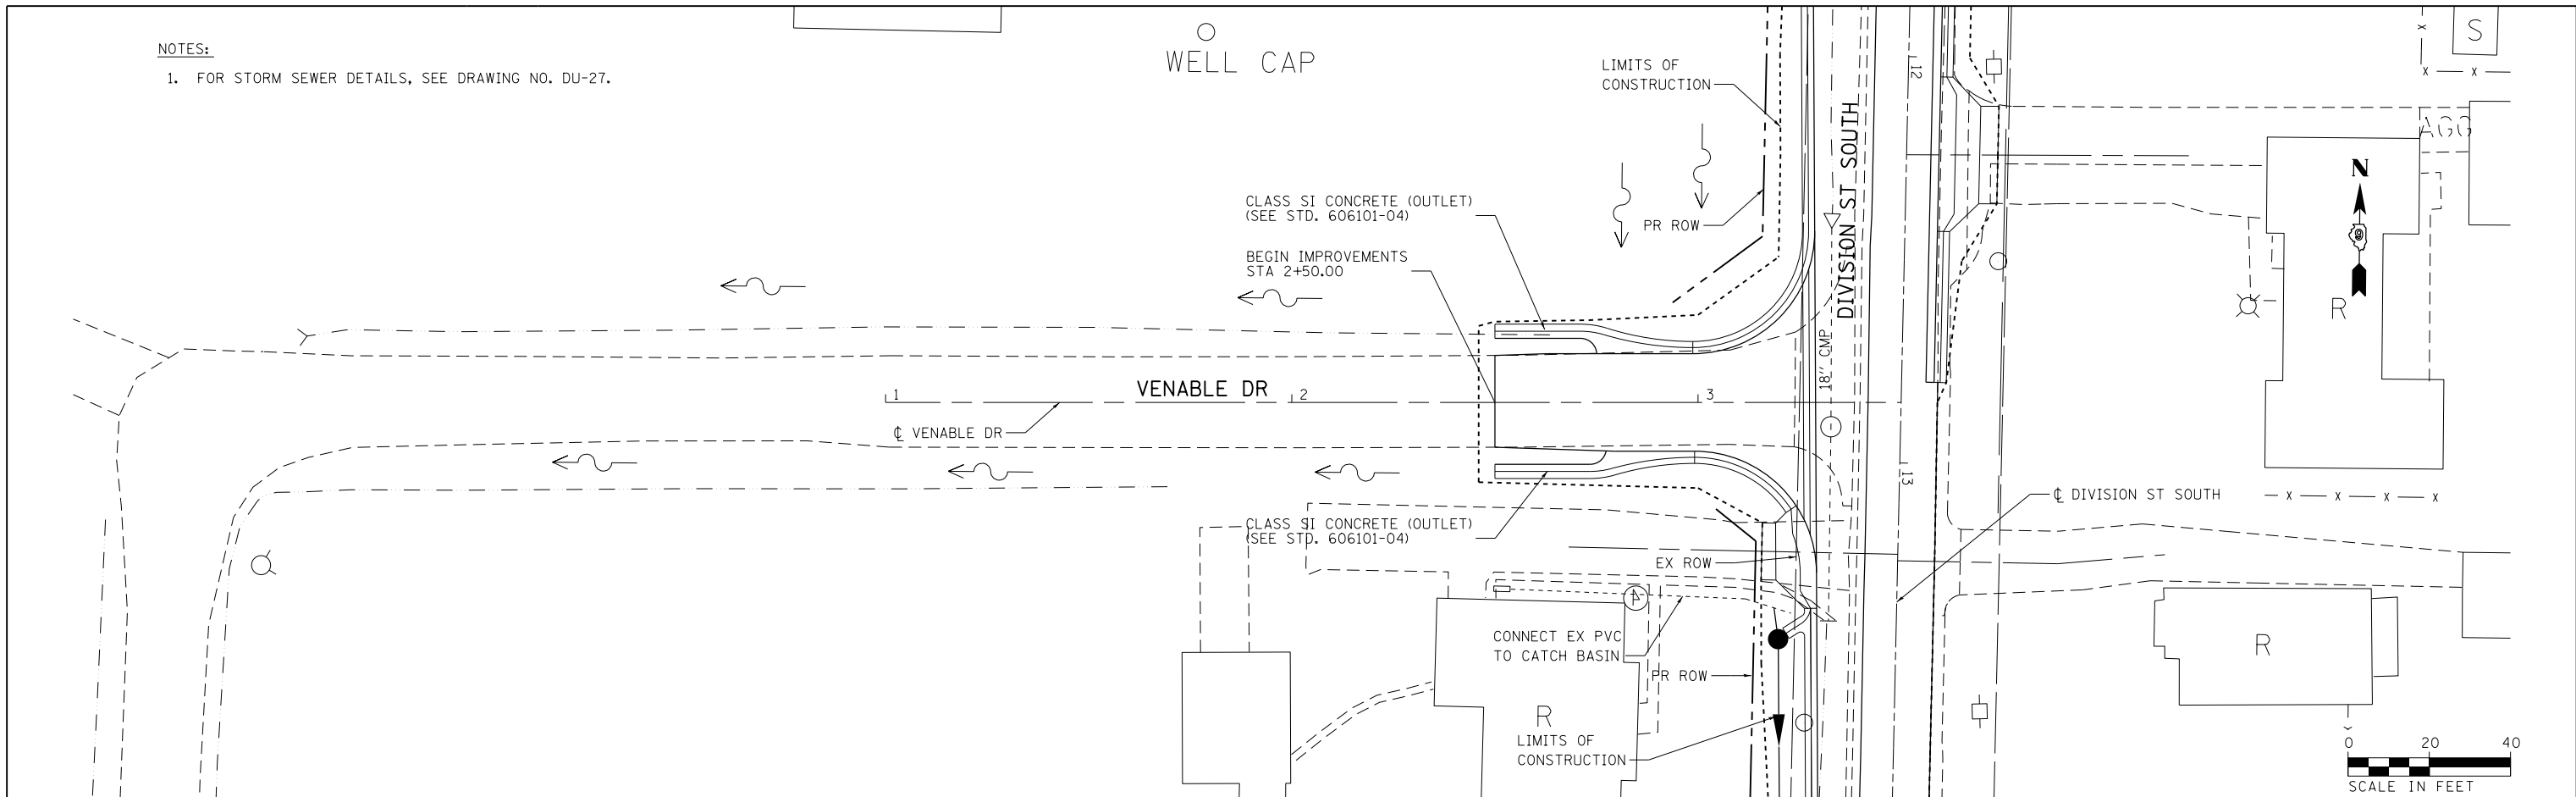

FILE NAME =	USER NAME = mfox	DESIGNED - KN	REVISED -	STATE OF ILLINOIS DEPARTMENT OF TRANSPORTATION	DRAINAGE AND UTILITY PLANS VENABLE DRIVE	F.A.P. RTE.	SECTION	COUNTY	TOTAL SHEETS	SHEET NO.	
D978258-shit-drain-30.dgn		DRAWN - AS	REVISED -			331	(1-4)R-2, N-4, TS-4	WILLIAMSON	381	196	
CH2MHILL	PLOT SCALE = 40.0000' / in.	CHECKED -	REVISED -			DRAWING NO. DU-41		CONTRACT NO. 78258		ILLINOIS FED. AID PROJECT	
	PLOT DATE = 1/31/2013	DATE -	REVISED -			SCALE:	SHEET NO. 41 OF 43 SHEETS	STA. 2+50.00	TO STA. 3+50.00		