
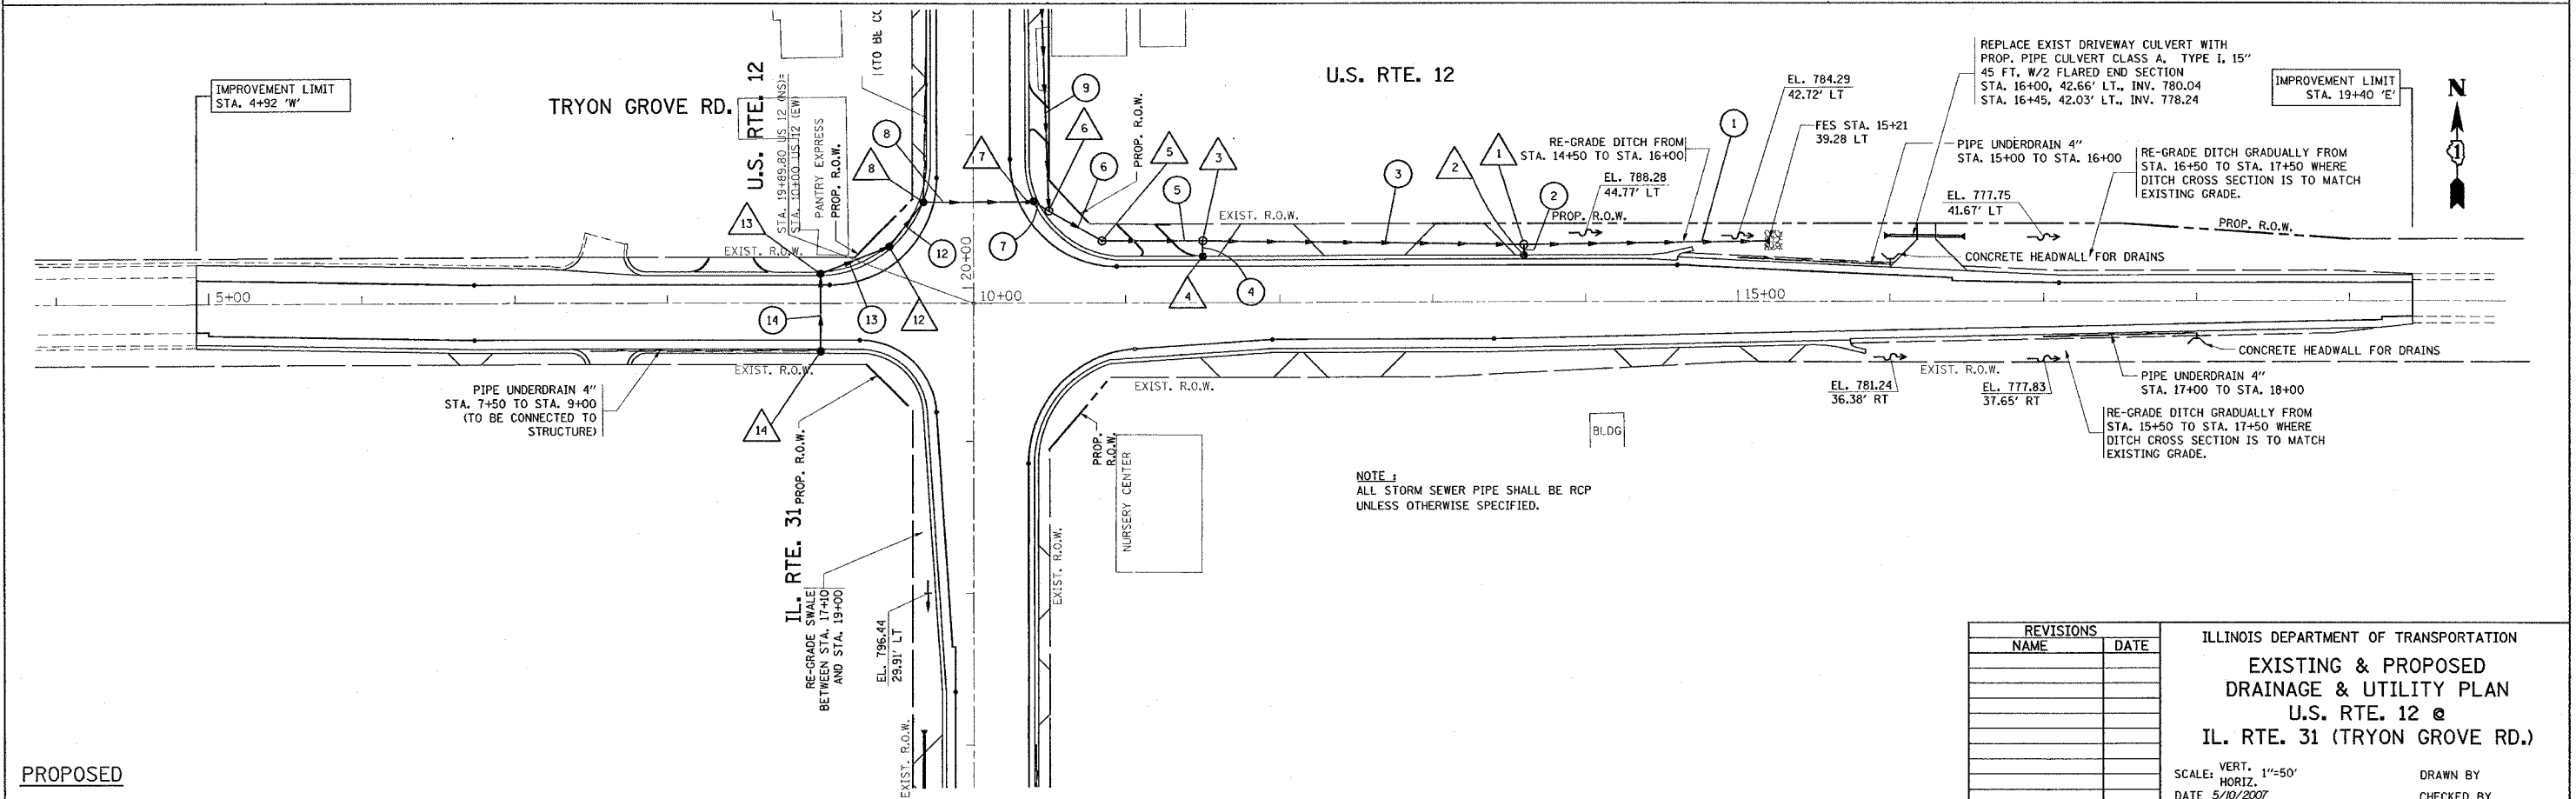


REF-EDR03
REF-PDR03

CONTRACT NO. 60A91

F.A.P. RTE.	SECTION	COUNTY	TOTAL SHEETS	SHEET NO.
334	III RS-5 & 116 B-1	MCHENRY	98	37
STA. TO STA.		ILLINOIS FED. AID PROJECT		

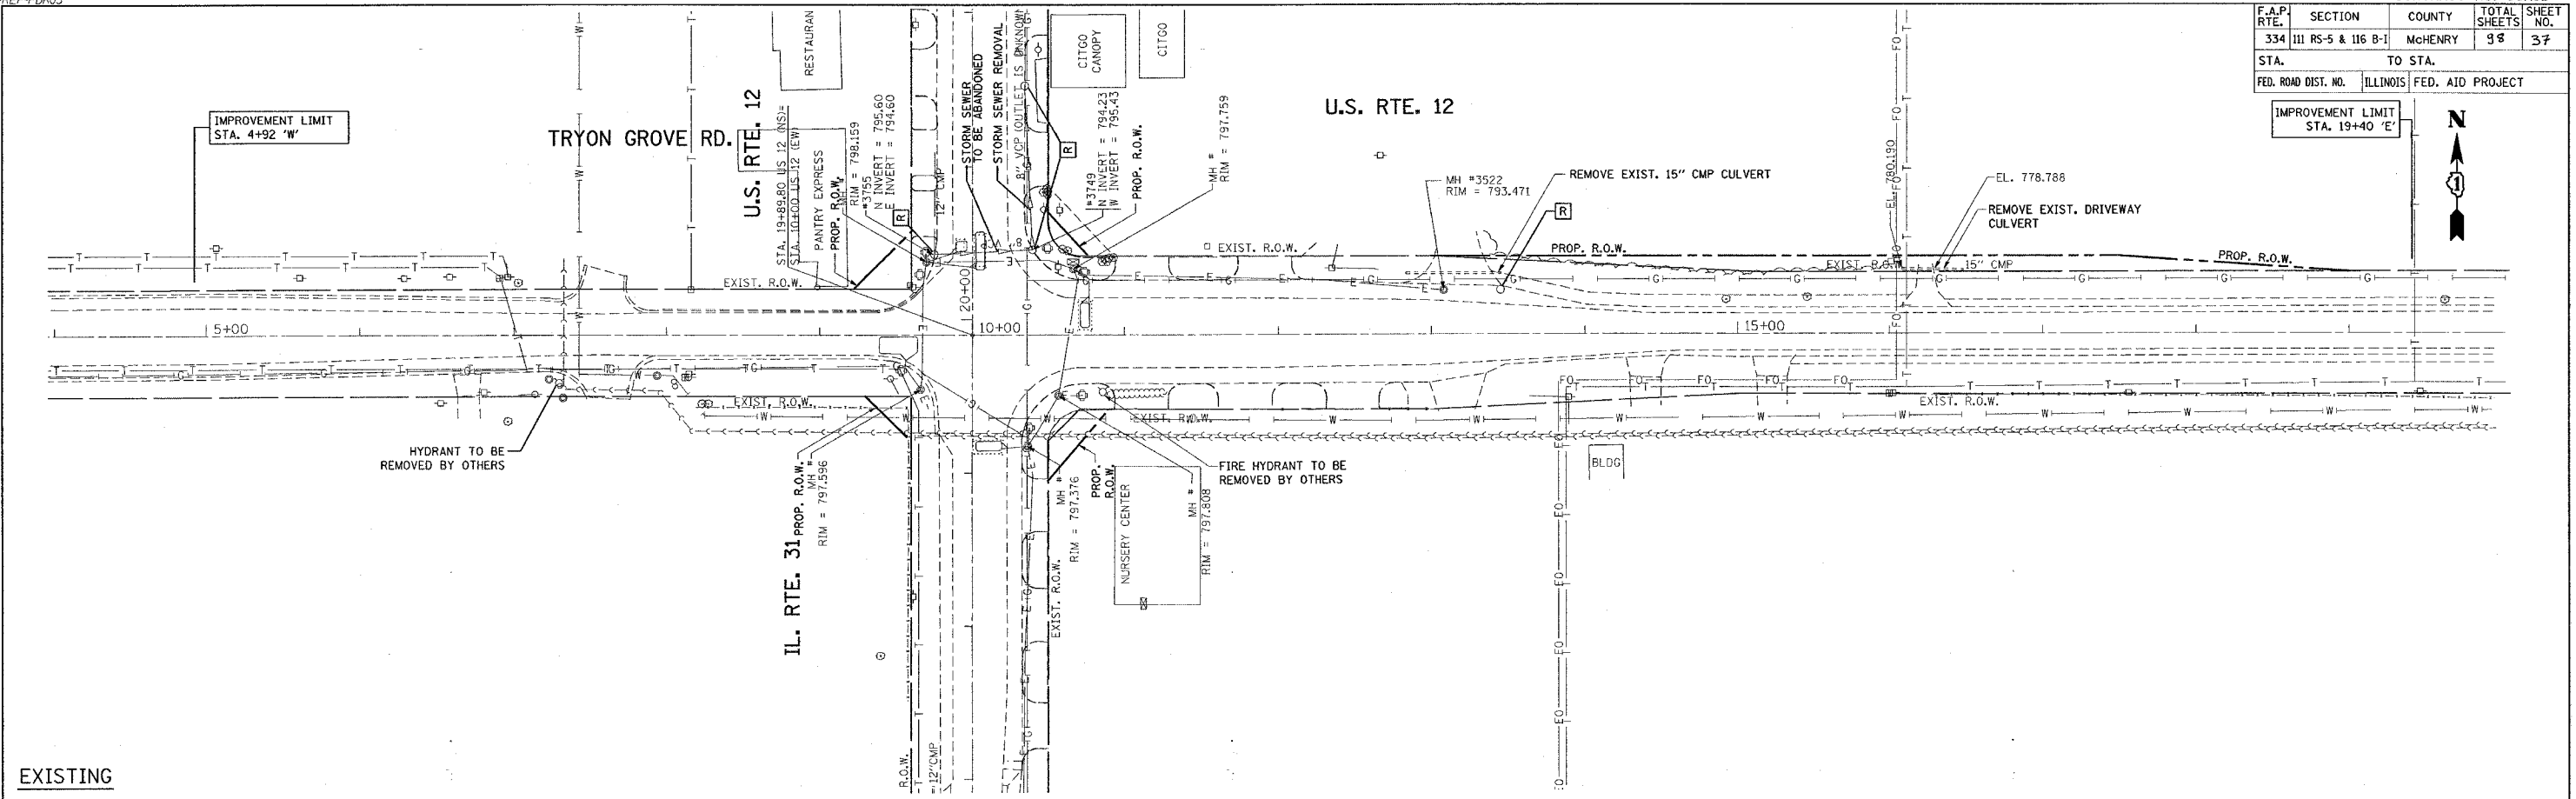

REVISIONS	
NAME	DATE

ILLINOIS DEPARTMENT OF TRANSPORTATION
EXISTING & PROPOSED
DRAINAGE & UTILITY PLAN
U.S. RTE. 12 @
IL. RTE. 31 (TRYON GROVE RD.)

SCALE: VERT. 1"=50'
HORIZ. "=50'
DATE 5/10/2007

DRAWN BY
CHECKED BY

PLOT DATE = 5/10/2007
FILE NAME = c:\projects\114895\ah.drain2.dgn
PLOT SCALE = 30.0000 / IN.
USER NAME = baurel