
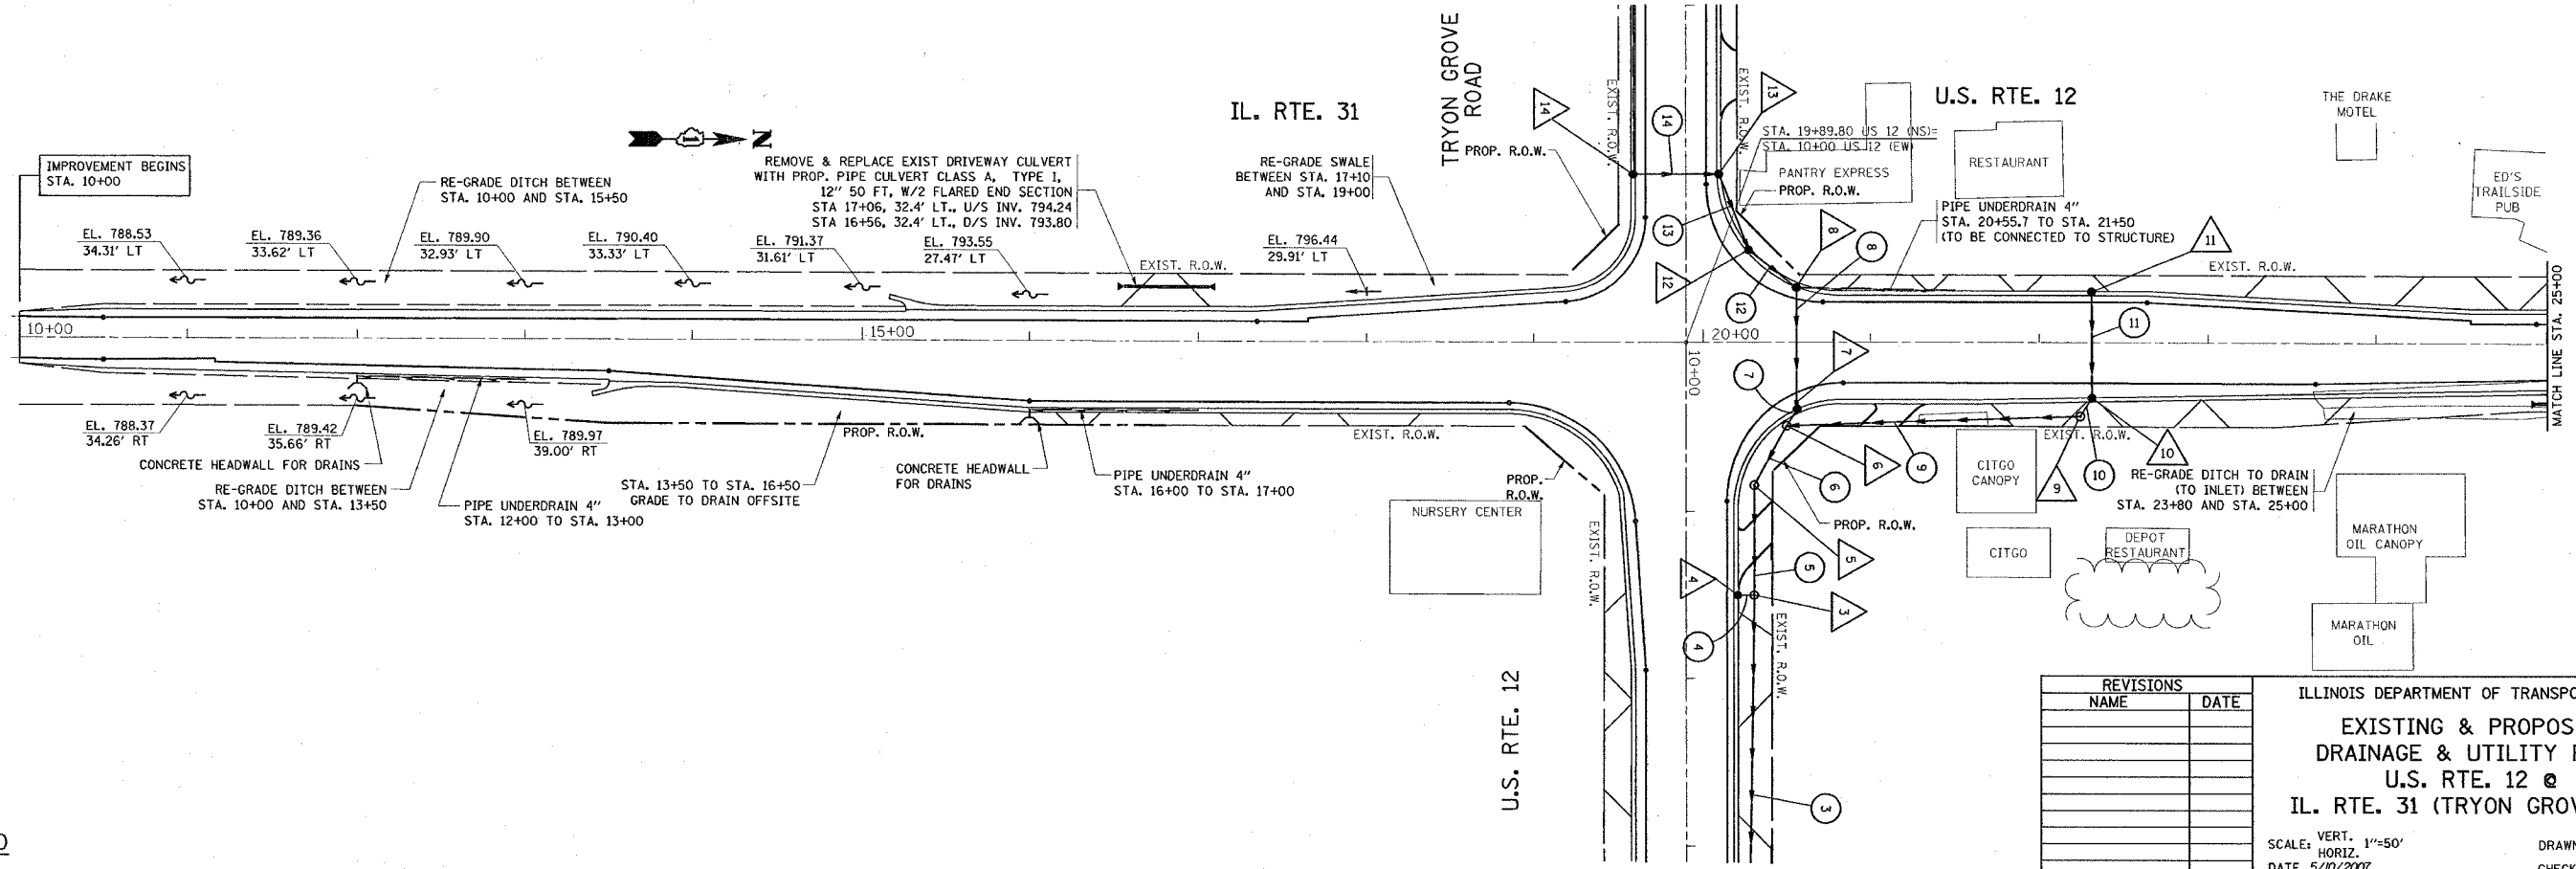


REF-EDR01  
REF-PDR01

CONTRACT NO. 60A91

F.A.P. RTE.	SECTION	COUNTY	TOTAL SHEETS	SHEET NO.
334	III RS-5 & 116 B-1	McHENRY	98	38
STA.		TO STA.		
FED. ROAD DIST. NO.		ILLINOIS FED. AID PROJECT		

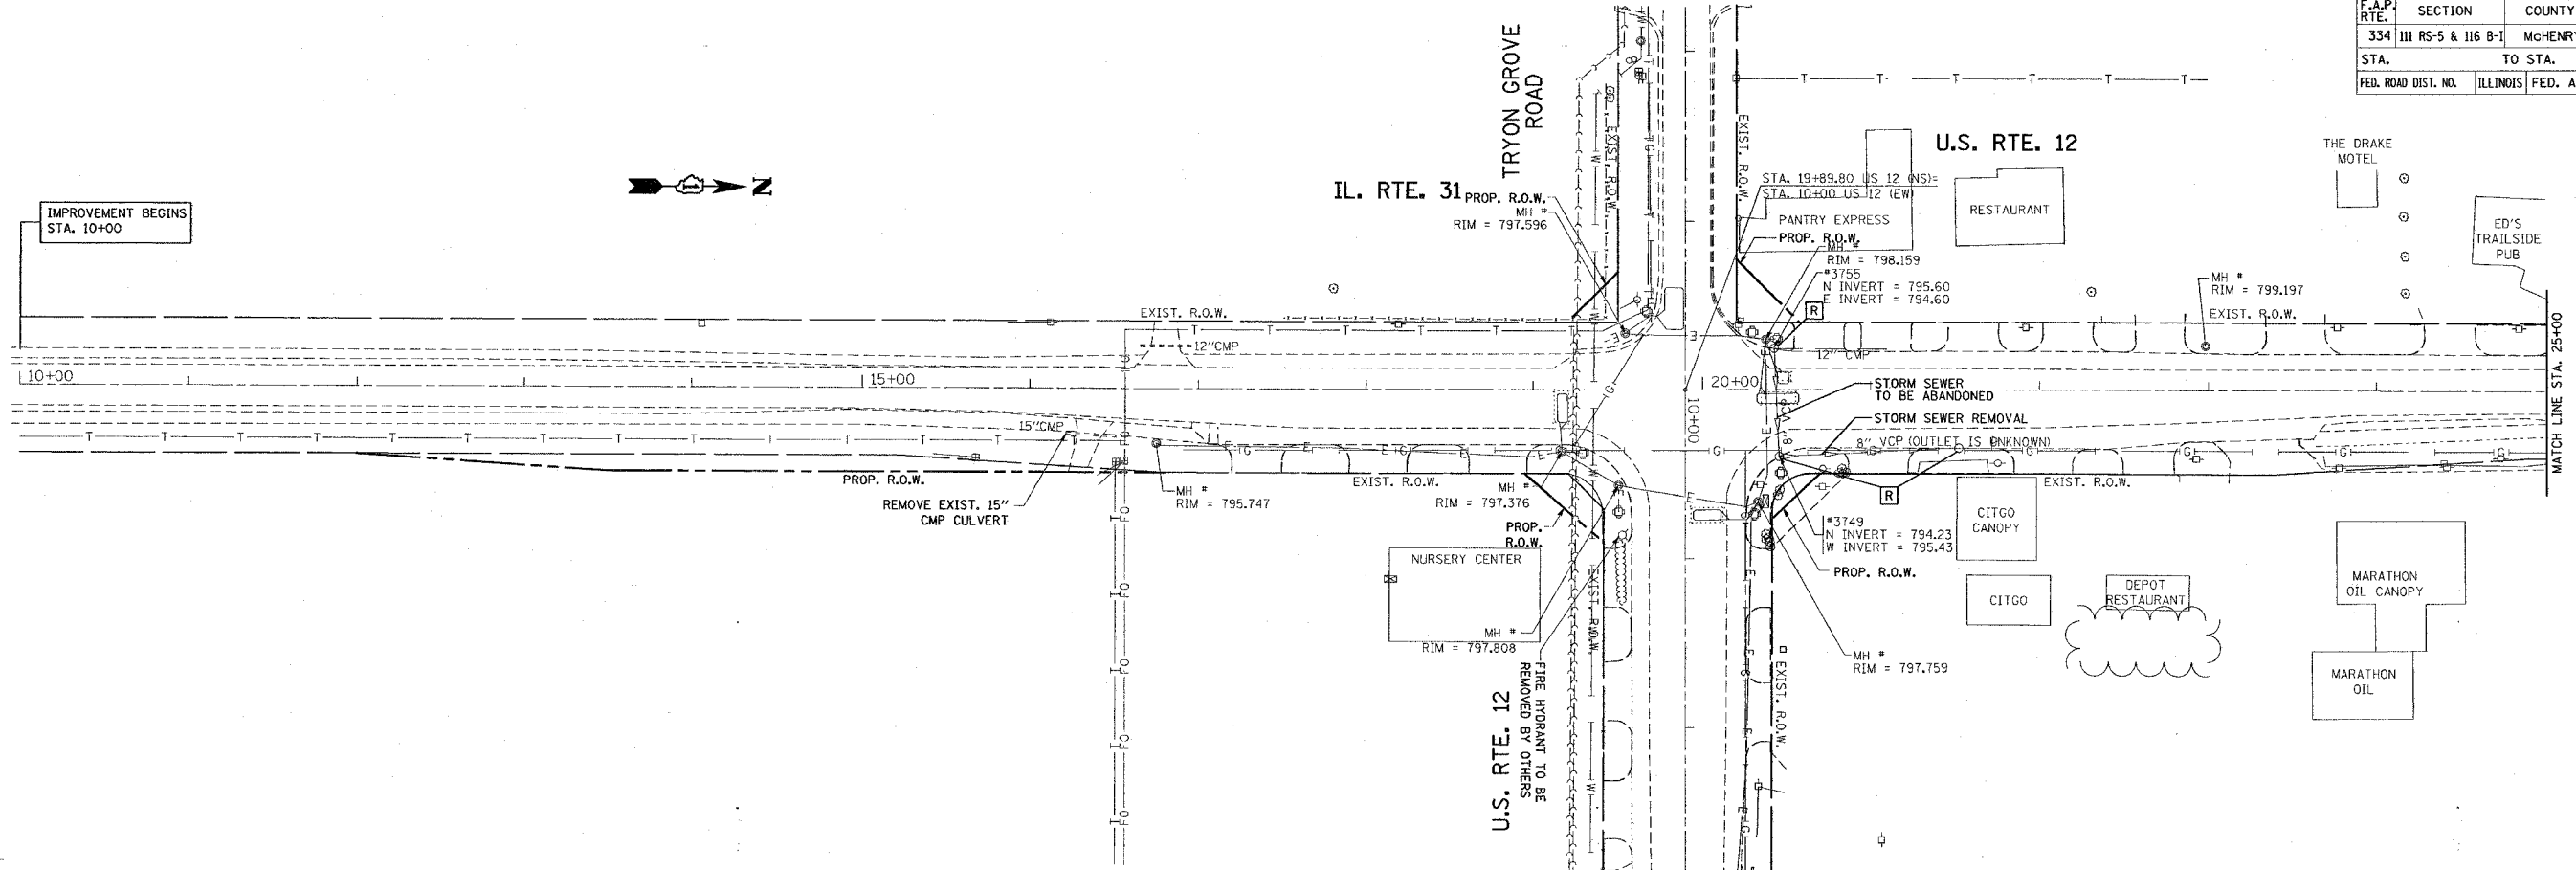

REVISIONS	
NAME	DATE

ILLINOIS DEPARTMENT OF TRANSPORTATION

**EXISTING & PROPOSED DRAINAGE & UTILITY PLAN**

**U.S. RTE. 12 @ IL. RTE. 31 (TRYON GROVE RD.)**

SCALE: VERT. 1"=50'  
HORIZ. 1"=50'

DATE 5/10/2007

DRAWN BY  
CHECKED BY

PLOT DATE = 5/10/2007  
FILE NAME = c:\projects\11495\sh\_drain2.dgn  
PLOT SCALE = 50.000000 / 1 IN.  
USER NAME = bauerd