


F.A.I. RTE.	SECTION	COUNTY	TOTAL SHEETS	SHEET NO.
55	2007-003 I	WILL	44	38
STA.		TO STA.		
FED. ROAD DIST. NO.		ILLINOIS FED. AID PROJECT		

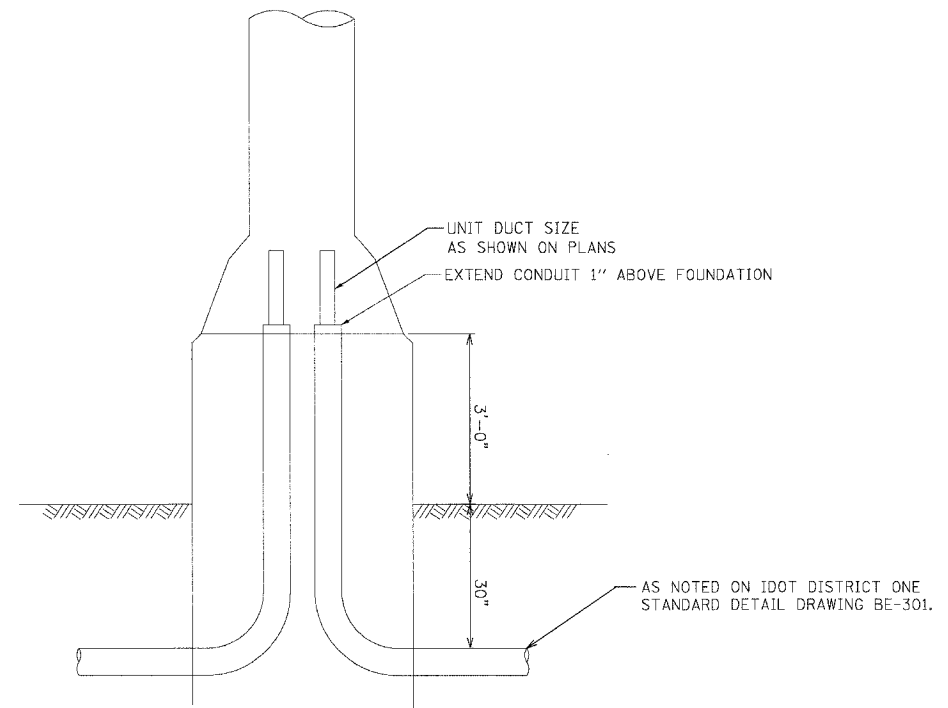

ASSUME THAT REINFORCING STEEL IS ALL INTERCONNECTED VIA TIE WRAPPING OR OTHER SUITABLE MEANS AND CONNECTED TO THE ANCHOR BOLTS.
 REFER TO STANDARD DISTRICT ONE DETAIL BE-702 FOR POLE WIRING DETAILS.

① NEW POLE BASE DETAIL
 NO SCALE

PLOT DATE = #DATE*
 FILE NAME = #FILE*
 PLOT SCALE = #SCALE*
 USER NAME = #USER*
 ..\DPP\1\001\DDN... \L\06\APP\...
 R14-2007.141434 GARCIBAZ
 S:\DOCUMENT\2236568\1\FILES\CON\101118MS.SHT

REVISIONS	
NAME	DATE

ILLINOIS DEPARTMENT OF TRANSPORTATION
 FAI ROUTE 55 (U.S. 6 TO U.S. 30)
 PARK AND RIDE LOTS

ELECTRICAL DETAILS

SCALE: N.T.S. DRAWN BY: MMP
 DATE: 06/14/07 CHECKED BY: JM

TENG
 TENG & ASSOCIATES, INC.
 ENGINEERS/ARCHITECTS/PLANNERS
 CHICAGO, ILLINOIS