



F.A.P. RTE.	SECTION	COUNTY	TOTAL SHEETS	SHEET NO.
332	(2SB-FAGH)I	IROQUOIS	14	4
FED. ROAD DIST. NO. ILLINOIS		STATE AID PROJECT		

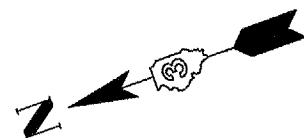

LENGEND

- — — — — EXISTING STORM SEWER
- ⊙ EXISTING MANHOLE
- EXISTING INLET

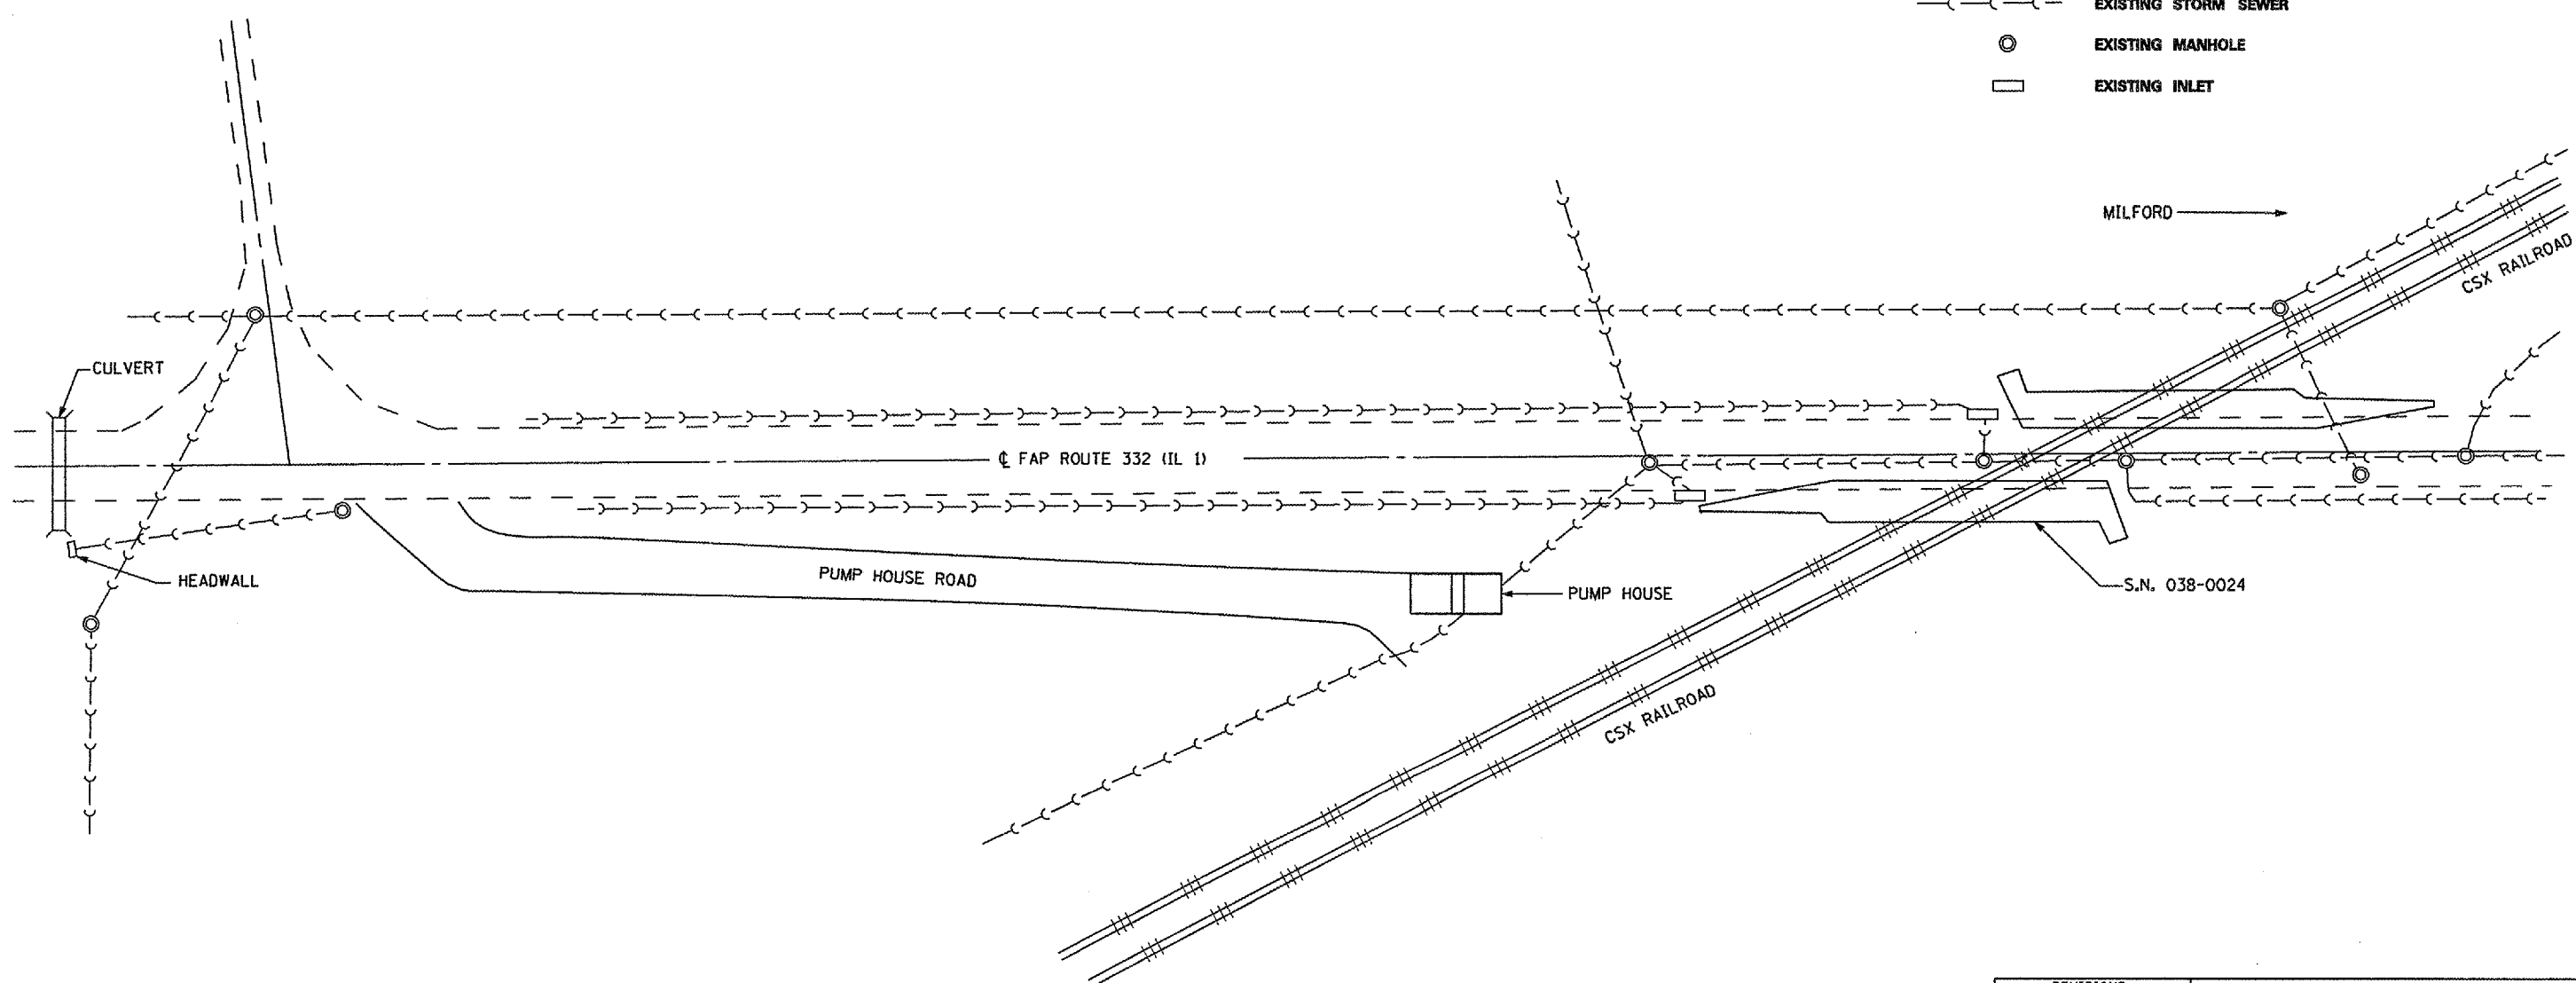

DATE: JANUARY 7, 2007
FILE: c:/projects/cm309/details.dgn

REVISIONS	
NAME	DATE

ILLINOIS DEPARTMENT OF TRANSPORTATION
GENERAL SITE PLAN
FAP ROUTE 332 (IL 1) SECTION (2SB-FAGH)I
IROQUOIS COUNTY
MILFORD PUMP STATION
S.N. 038-0024