


ROUTE NO.	SECTION	COUNTY	TOTAL SHEETS	SHEET NO.
FAU 8367	05-0005-00-77	EFFINGHAM	18	16
FED. ROAD DIST. NO. 7	ILLINOIS	FED. AID PROJECT-		

CONTRACT #95507

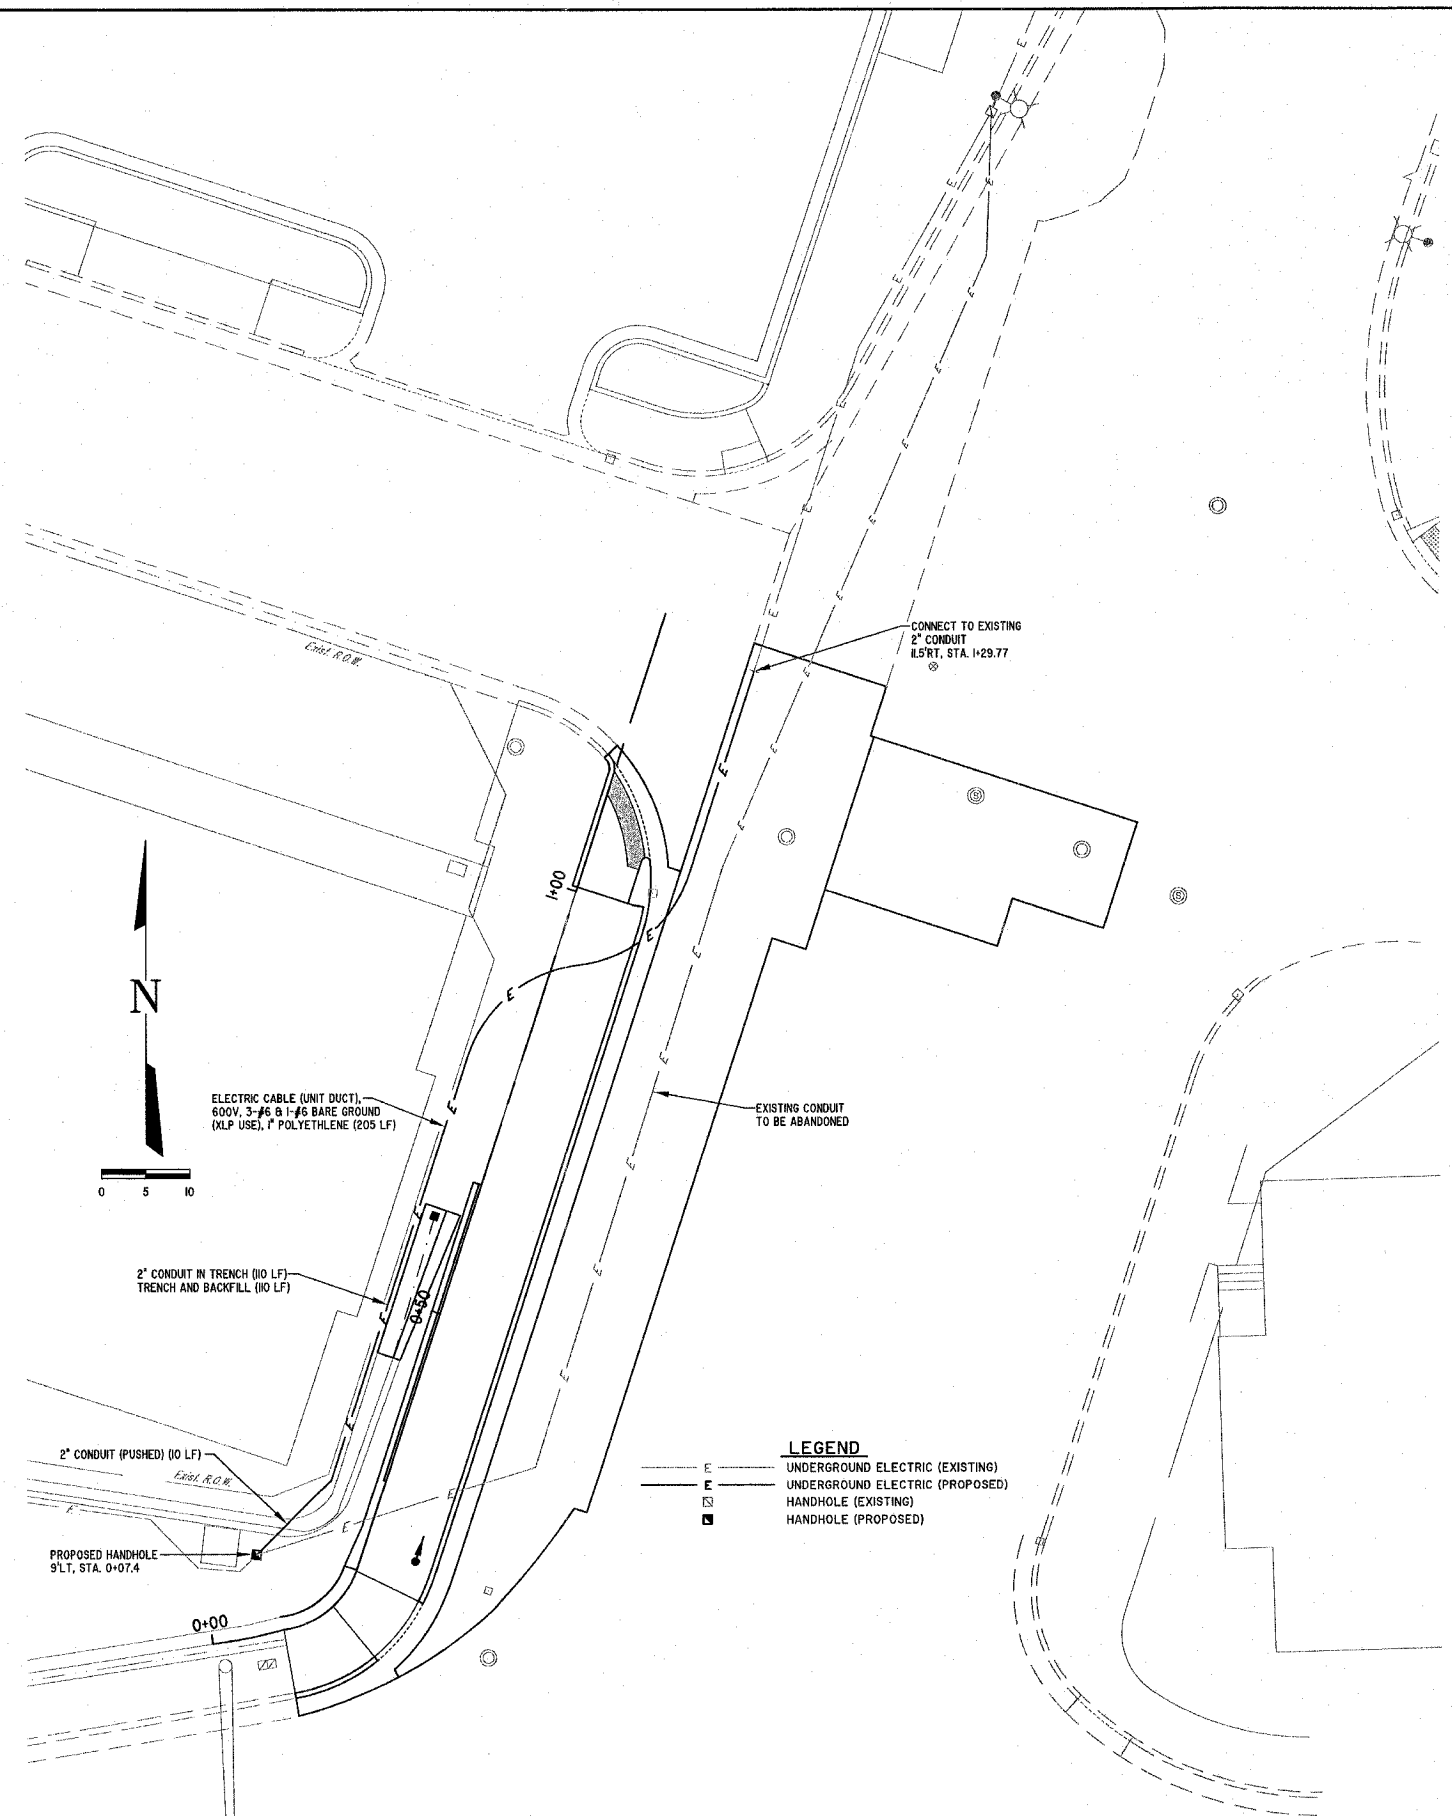

ELECTRIC CABLE (UNIT DUCT)
600V, 3-#6 B-1-#6 BARE GROUND
(XLP USE), 1" POLYETHYLENE (205 LF)

2" CONDUIT IN TRENCH (10 LF)
TRENCH AND BACKFILL (10 LF)

2" CONDUIT (PUSHED) (0 LF)

PROPOSED HANDHOLE
S.T. STA. 0+07.4

CONNECT TO EXISTING
2" CONDUIT
I.S.R.T. STA. 1+29.77

EXISTING CONDUIT
TO BE ABANDONED

LEGEND

- E — UNDERGROUND ELECTRIC (EXISTING)
- - - E - - - UNDERGROUND ELECTRIC (PROPOSED)
- ⊠ EXISTING HANDHOLE (EXISTING)
- PROPOSED HANDHOLE (PROPOSED)

MILANO & GRUNLOH ENGINEERS, LLC
 14 WEST WASHINGTON
 P.O. BOX 897
 EFFINGHAM, ILLINOIS 62401
 PHONE: (217) 347-7282
 (800) 677-2774
 FAX #: (217) 348-3433

STREET LIGHTING ELECTRICAL PLAN
 BANKER STREET
 CITY OF EFFINGHAM
 EFFINGHAM COUNTY, ILLINOIS

File name: S:\DWG\03\0303RTR\dwg\01rml Lights.dwg
 Plot date: 04/27/07 at 12:00 P.M.