


F.A.U. RTE.	SECTION	COUNTY	TOTAL SHEETS	SHEET NO.
9104 05-00001-00-WR	MADISON	ILLINOIS	102	46
FED. ROAD DIST. NO. - ILLINOIS FED. AID PROJECT			CONTRACT NO. 97314	

BY	DATE


FINAL SURVEYED SURVEY PLOTTED NOTE BOOK TEMPLATE AREAS CHECKED NO.

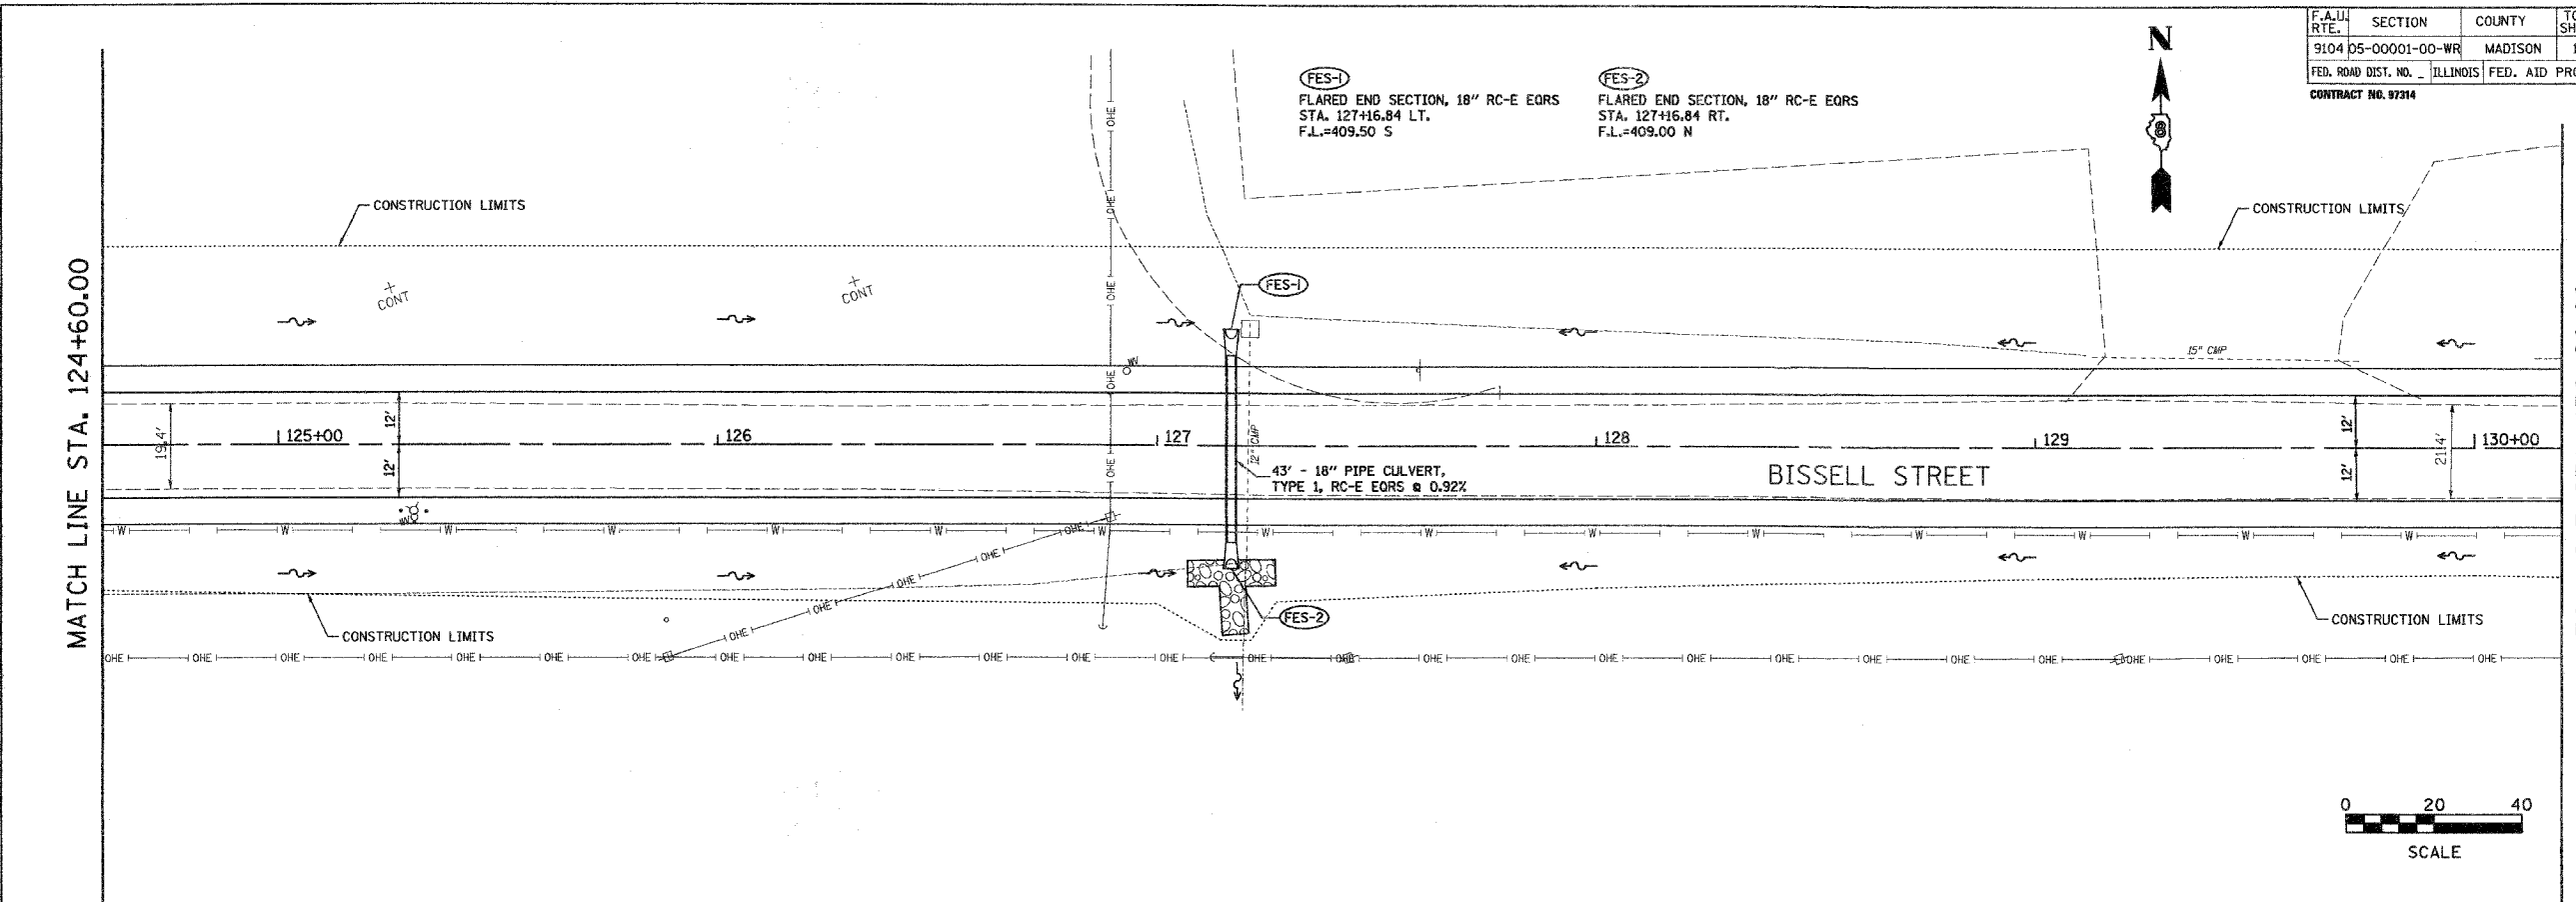

425										425
420										420
415										415
410										410
405										405
400										400
395										395

BY	DATE

ORIGINAL SURVEYED SURVEY PLOTTED NOTE BOOK TEMPLATE AREAS CHECKED NO.

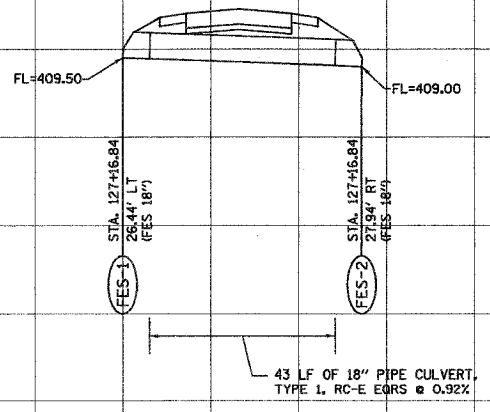

Juneau Associates, Inc. P.C.
CONSULTING ENGINEERS AND LAND SURVEYORS
2100 South Street, P.O. Box 1320
Madison, Illinois 62608
Phone: (618)427-1400 / FAX: (618)427-2531
Fax: (618)427-2541

DRAINAGE PLAN
BISSELL STREET
MADISON, ILLINOIS
SECTION No. 05-0001-00-WR

REVISIONS			
NO.	DATE	BY	REMARKS
DWG. NO.			

SCALE:
1 Inch = 20 feet

DSN. BY:	BFK	DATE:	1/19/07	SHEET
DWN. BY:	JDH	DATE:	1/19/07	46
CHKD. BY:	BFK	DATE:	1/19/07	
JOB NO.	E061300	DGN. NAME:	DRAIN03	OF 102 SHTS