



F.A.U. RTE.	SECTION	COUNTY	TOTAL SHEETS	SHEET NO.
9104	05-00001-00-WR	MADISON	102	48
FED. ROAD DIST. NO. - ILLINOIS		FED. AID PROJECT		
CONTRACT NO. 97314				

FINAL SURVEY PLOTTED	BY	DATE
NOTE BOOK TEMPLATE		
AREAS CHECKED		
NO.		

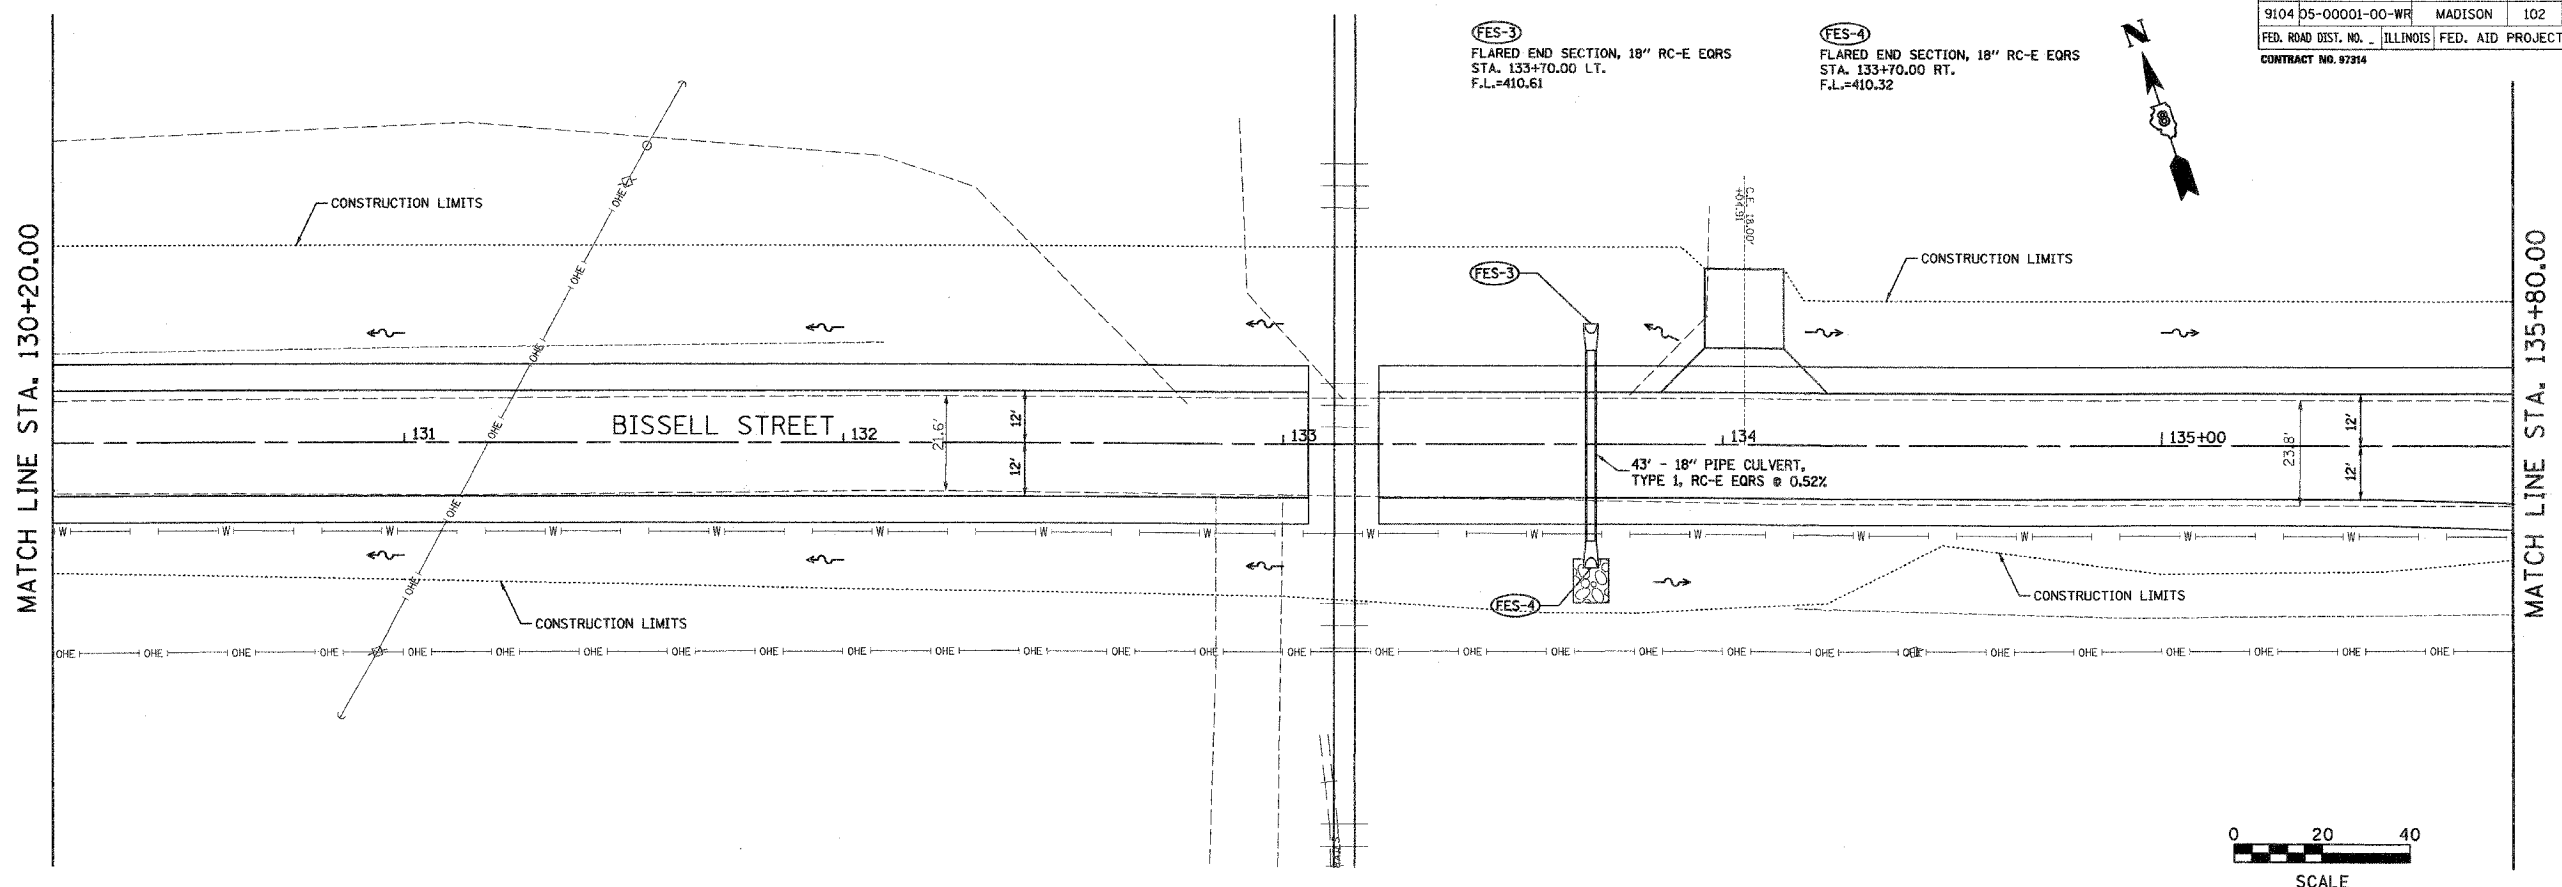

ORIGINAL SURVEY PLOTTED	BY	DATE
NOTE BOOK TEMPLATE		
AREAS CHECKED		
NO.		

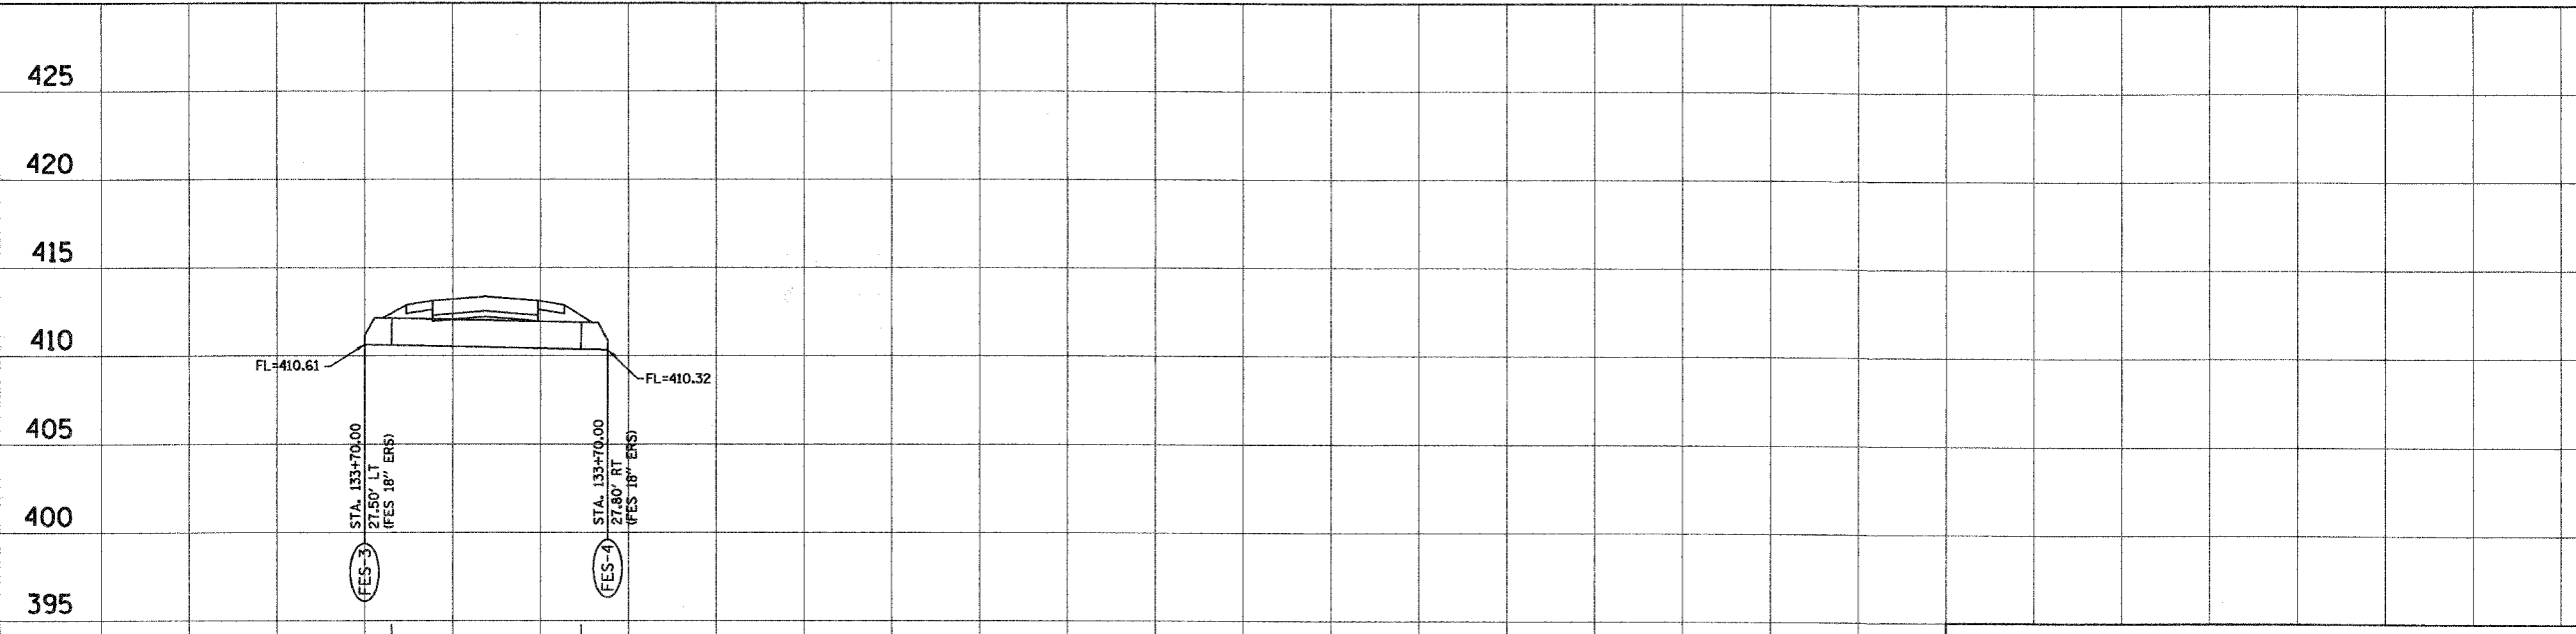

Juneau Associates, Inc. P.C.
 CONSULTING ENGINEERS AND LAND SURVEYORS
 2000 State Street, S.E., Box 1320
 Graysville City, Illinois 62404
 Phone: (618) 387-4400 / (618) 387-5500
 Fax: (618) 387-4541

DRAINAGE PLAN
BISSELL STREET
MADISON, ILLINOIS
SECTION No. 05-00001-00-WR

REVISIONS			
NO.	DATE	BY	REMARKS

SCALE: 1 Inch = 20 feet			
DSN. BY:	BFK	DATE:	1/19/07
DWN. BY:	JDH	DATE:	1/19/07
CHKD. BY:	BFK	DATE:	1/19/07
DWG. NO.	E061300	DGN. NAME:	DRAIN04
SHEET			48
OF 102 SHTS			