

 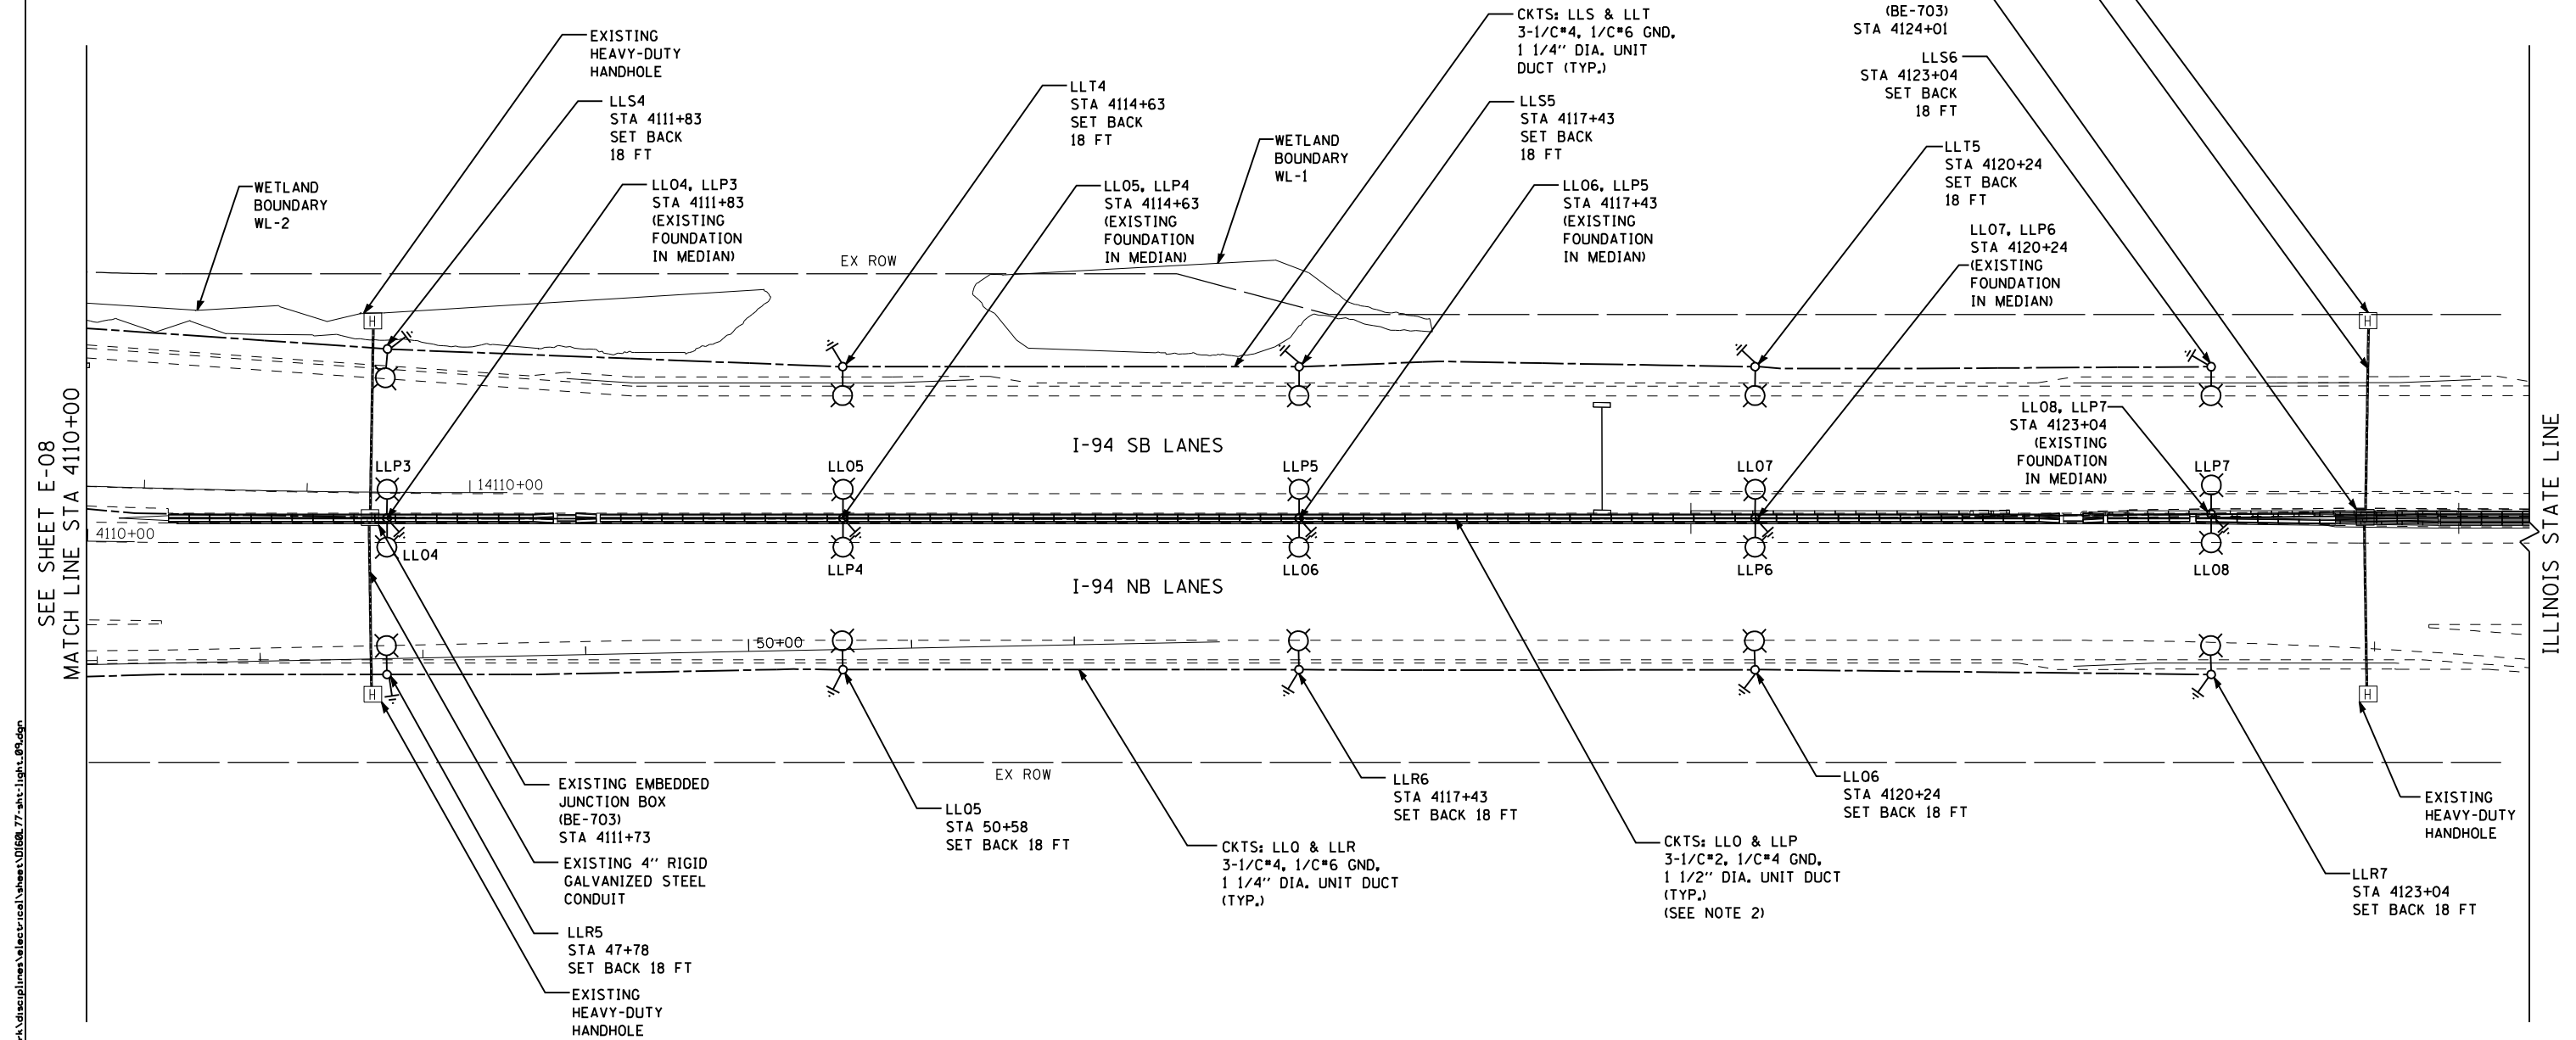


- NOTES**
- 5 FOUNDATIONS IN MEDIAN ARE EXISTING. INSTALL PROPOSED LIGHT POLES WITH DUAL ARMS ON EXISTING CENTER MEDIAN FOUNDATIONS.
  - INSTALL PROPOSED UNIT DUCT IN EXISTING 4" PVC RACEWAY EMBEDDED IN CENTER MEDIAN.
  - SETBACKS ARE MEASURED FROM EDGE OF TRAVELED PAVEMENT TO CENTER OF POLE.

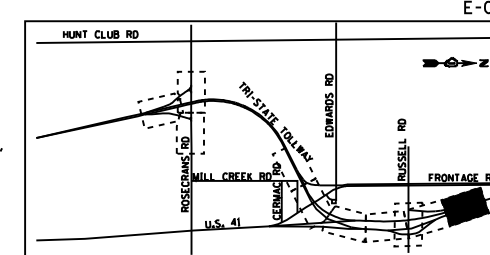

s:\projects\2012\11-41-mse to il 173 - bba\proj\set work\disciplines\electrical\sheet\11066-77-ah-light\_09.dwg

**EJM ENGINEERING, INC.**  
 411 South Wells Street Suite 1000  
 Chicago, Illinois 60607



FILE NAME	USER NAME = rsonson	DESIGNED - RAS	REVISED -
		DRAWN - BHH	REVISED -
	PLOT SCALE = 100.0000' / IN.	CHECKED - MKR	REVISED -
	PLOT DATE = 6/18/2012	DATE - 6/19/2012	REVISED -

**STATE OF ILLINOIS  
 DEPARTMENT OF TRANSPORTATION**

**PROPOSED IDOT LIGHTING PLAN  
 I-94 FROM ROSECRANS RD TO STATE LINE**

SCALE: 1"=50'    SHEET NO. 9 OF 53 SHEETS    STA. 4110+00 TO STA. 4125+00

F.A. RTE.	SECTION	COUNTY	TOTAL SHEETS	SHEET NO.
94	49-1-R-1	LAKE	677	369
CONTRACT NO. 60L77				
ILLINOIS FED. AID PROJECT				

E-09