


- NOTES:**
- EXISTING LIGHTING UNITS INSTALLED IN TOLLWAY CONTRACTS I-07-5236 AND I-07-5237.
 - EXISTING LIGHTING UNITS TO BE RELOCATED (RLD) ARE SHOWN IN PROPOSED LOCATION.
 - ALL LIGHTING SHOWN ON THIS SHEET IS TOLLWAY-MAINTAINED.
 - ALL OFFSETS AND LIGHT STANDARD FOUNDATIONS FOR GROUND MOUNTED POLES ARE PER TOLLWAY STANDARD DETAIL HI-01, UNLESS NOTED OTHERWISE.

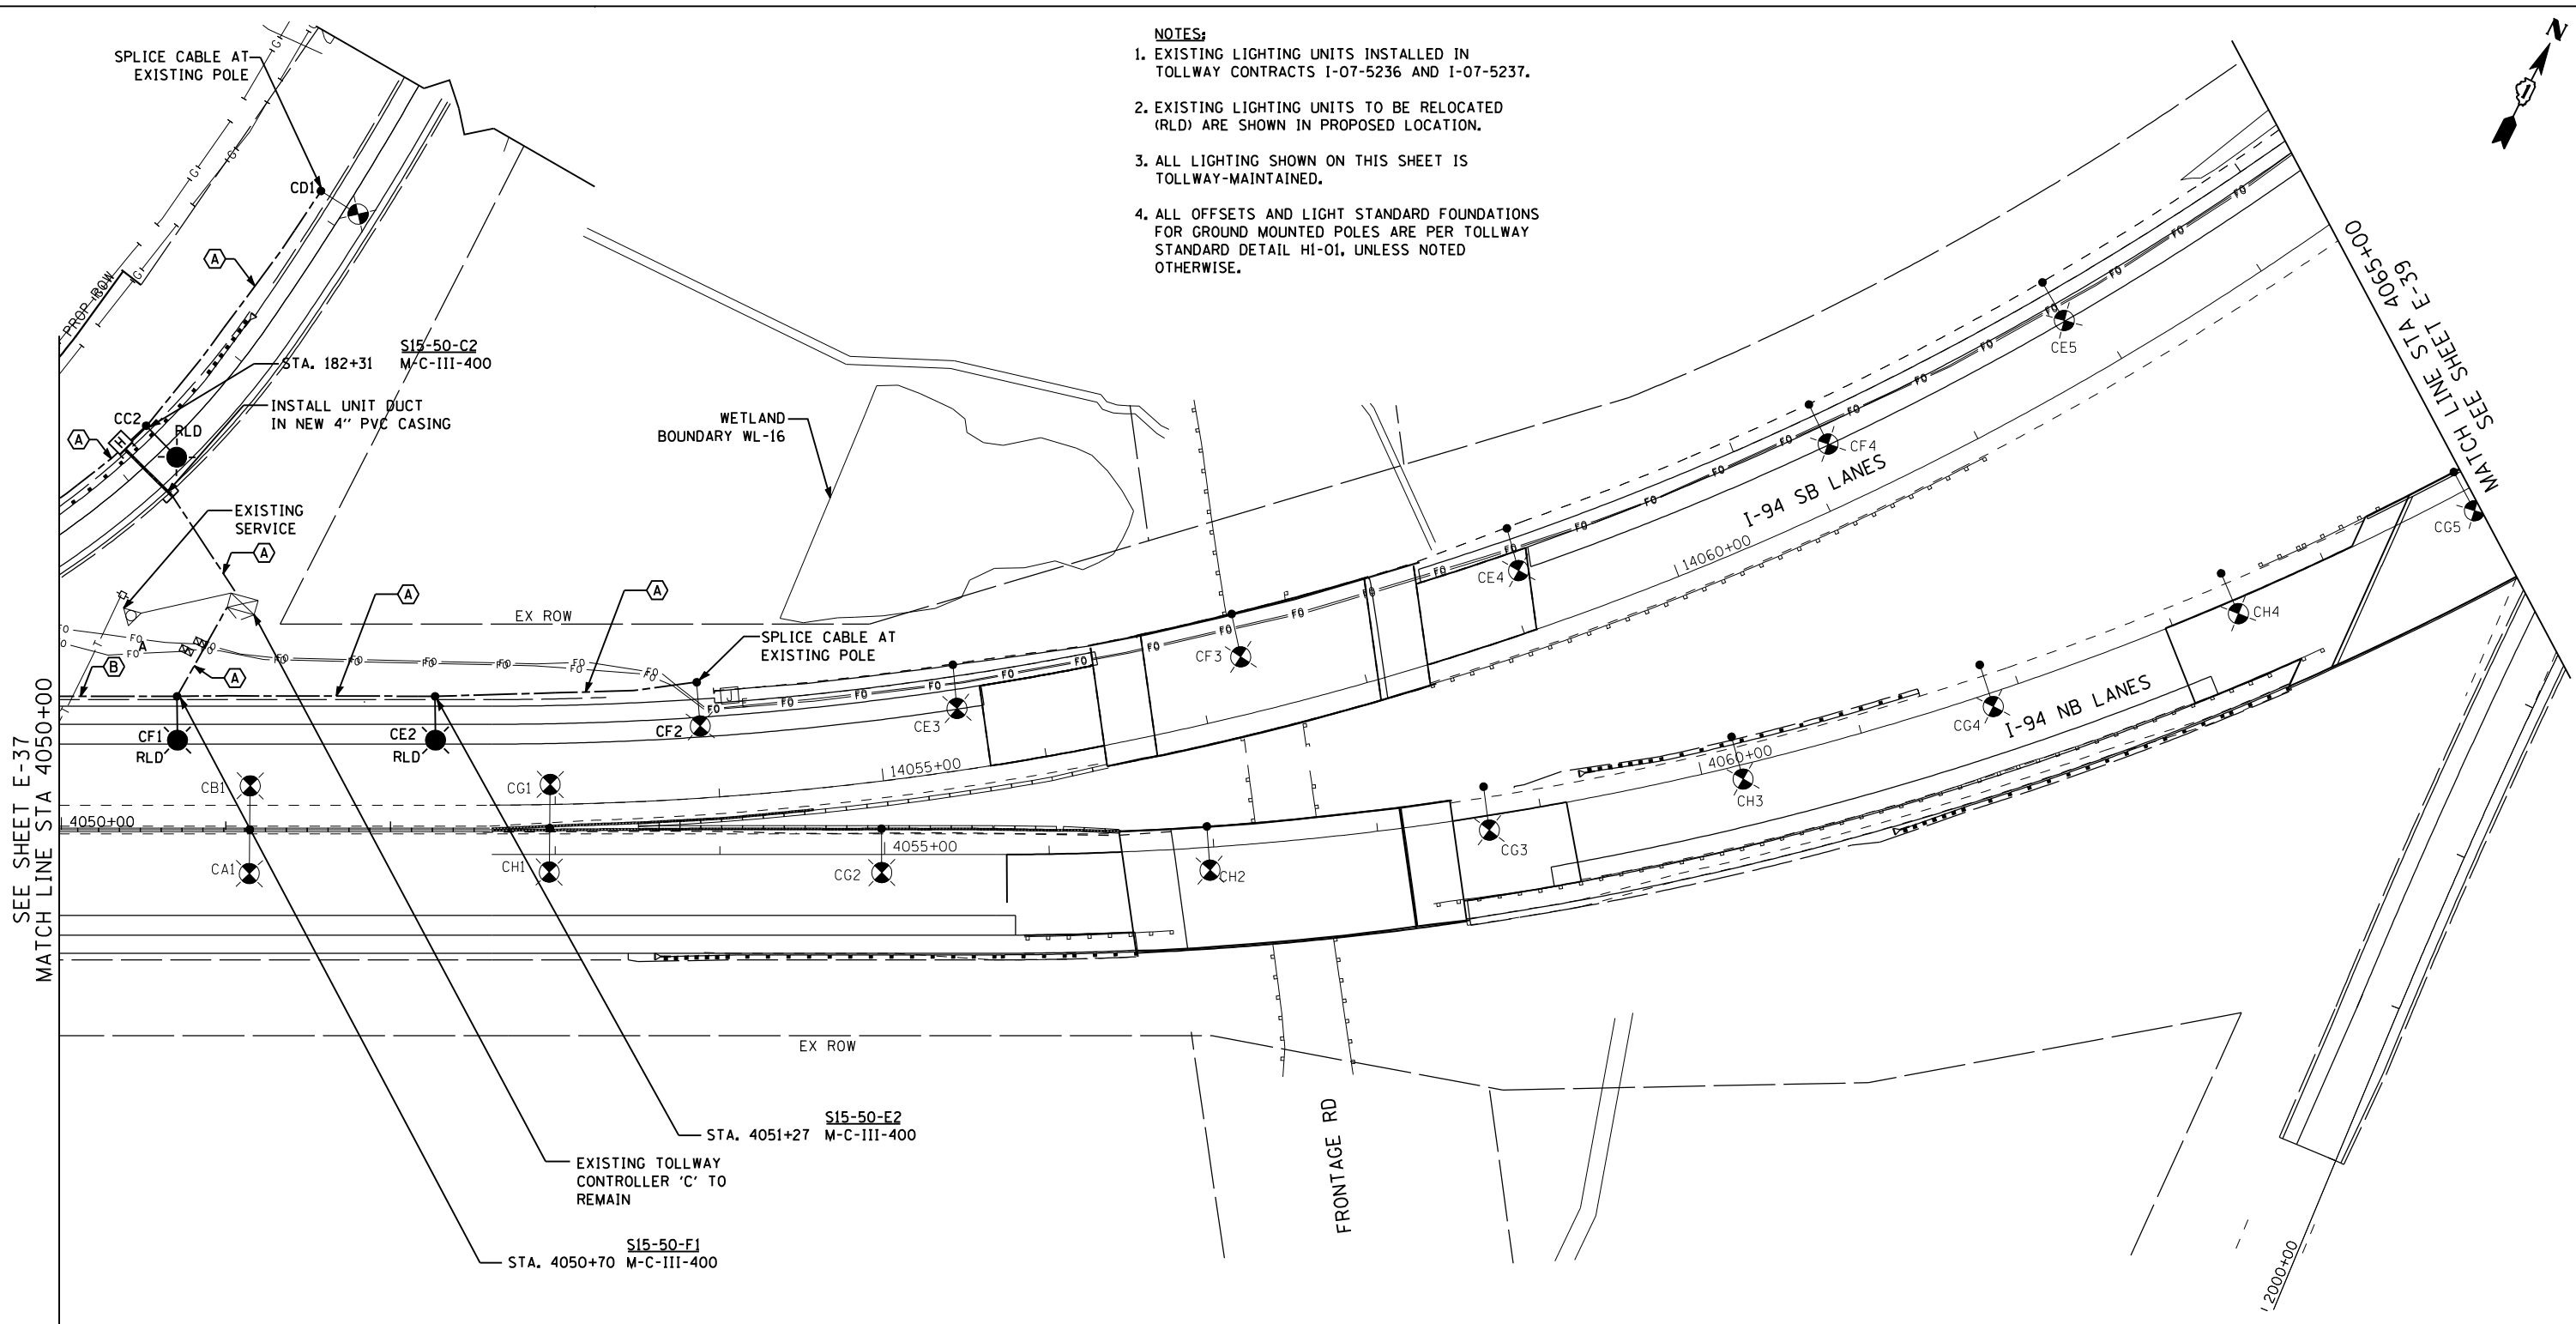

TOLLWAY CONDUIT TAGS:

TAG	DESCRIPTION
(A)	2" DIA. UNIT DUCT WITH 4-1/C NO. 4, 1-1/C NO. 6 GND
(B)	2" DIA. UNIT DUCT WITH 2-1/C NO. 4, 1-1/C NO. 6 GND
(C)	2" DIA. UNIT DUCT WITH 4-1/C NO. 2, 1-1/C NO. 4 GND



EJM ENGINEERING, INC.
 411 South Wells Street Suite 1000
 Chicago, Illinois 60607

FILE NAME	USER NAME = rsonson	DESIGNED - RAS	REVISED -
		DRAWN - BHH	REVISED -
		CHECKED - MKR	REVISED -
		DATE - 6/19/2012	REVISED -

**STATE OF ILLINOIS
 DEPARTMENT OF TRANSPORTATION**

**PROPOSED TOLLWAY LIGHTING PLAN
 I-94 FROM ROSECRANS RD TO STATE LINE**

 SCALE: 1"=50' SHEET NO. 38 OF 53 SHEETS STA. 4050+00 TO STA. 4065+00

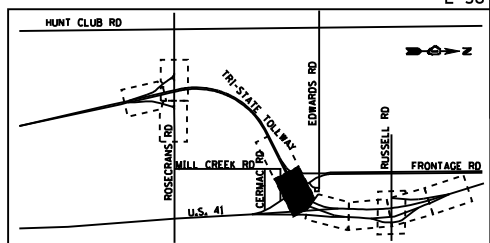

F.A. RTE.	SECTION	COUNTY	TOTAL SHEETS	SHEET NO.
94	49-1-R-1	LAKE	677	398
CONTRACT NO. 60L77				
ILLINOIS FED. AID PROJECT				

s:\projects\2012\11-1173 - bba\proj\set\work\disciplines\electrical\sheet\060677-ht-light_38.dgn