 




REVISIONS		
NUMBER	BY	DATE



**LANSING MUNICIPAL AIRPORT  
 LANSING, ILLINOIS  
 NORTH QUADRANT SITework - PHASE 1  
 AND TAXIWAY G2 EXTENSION  
 STORM SEWER PROFILES**

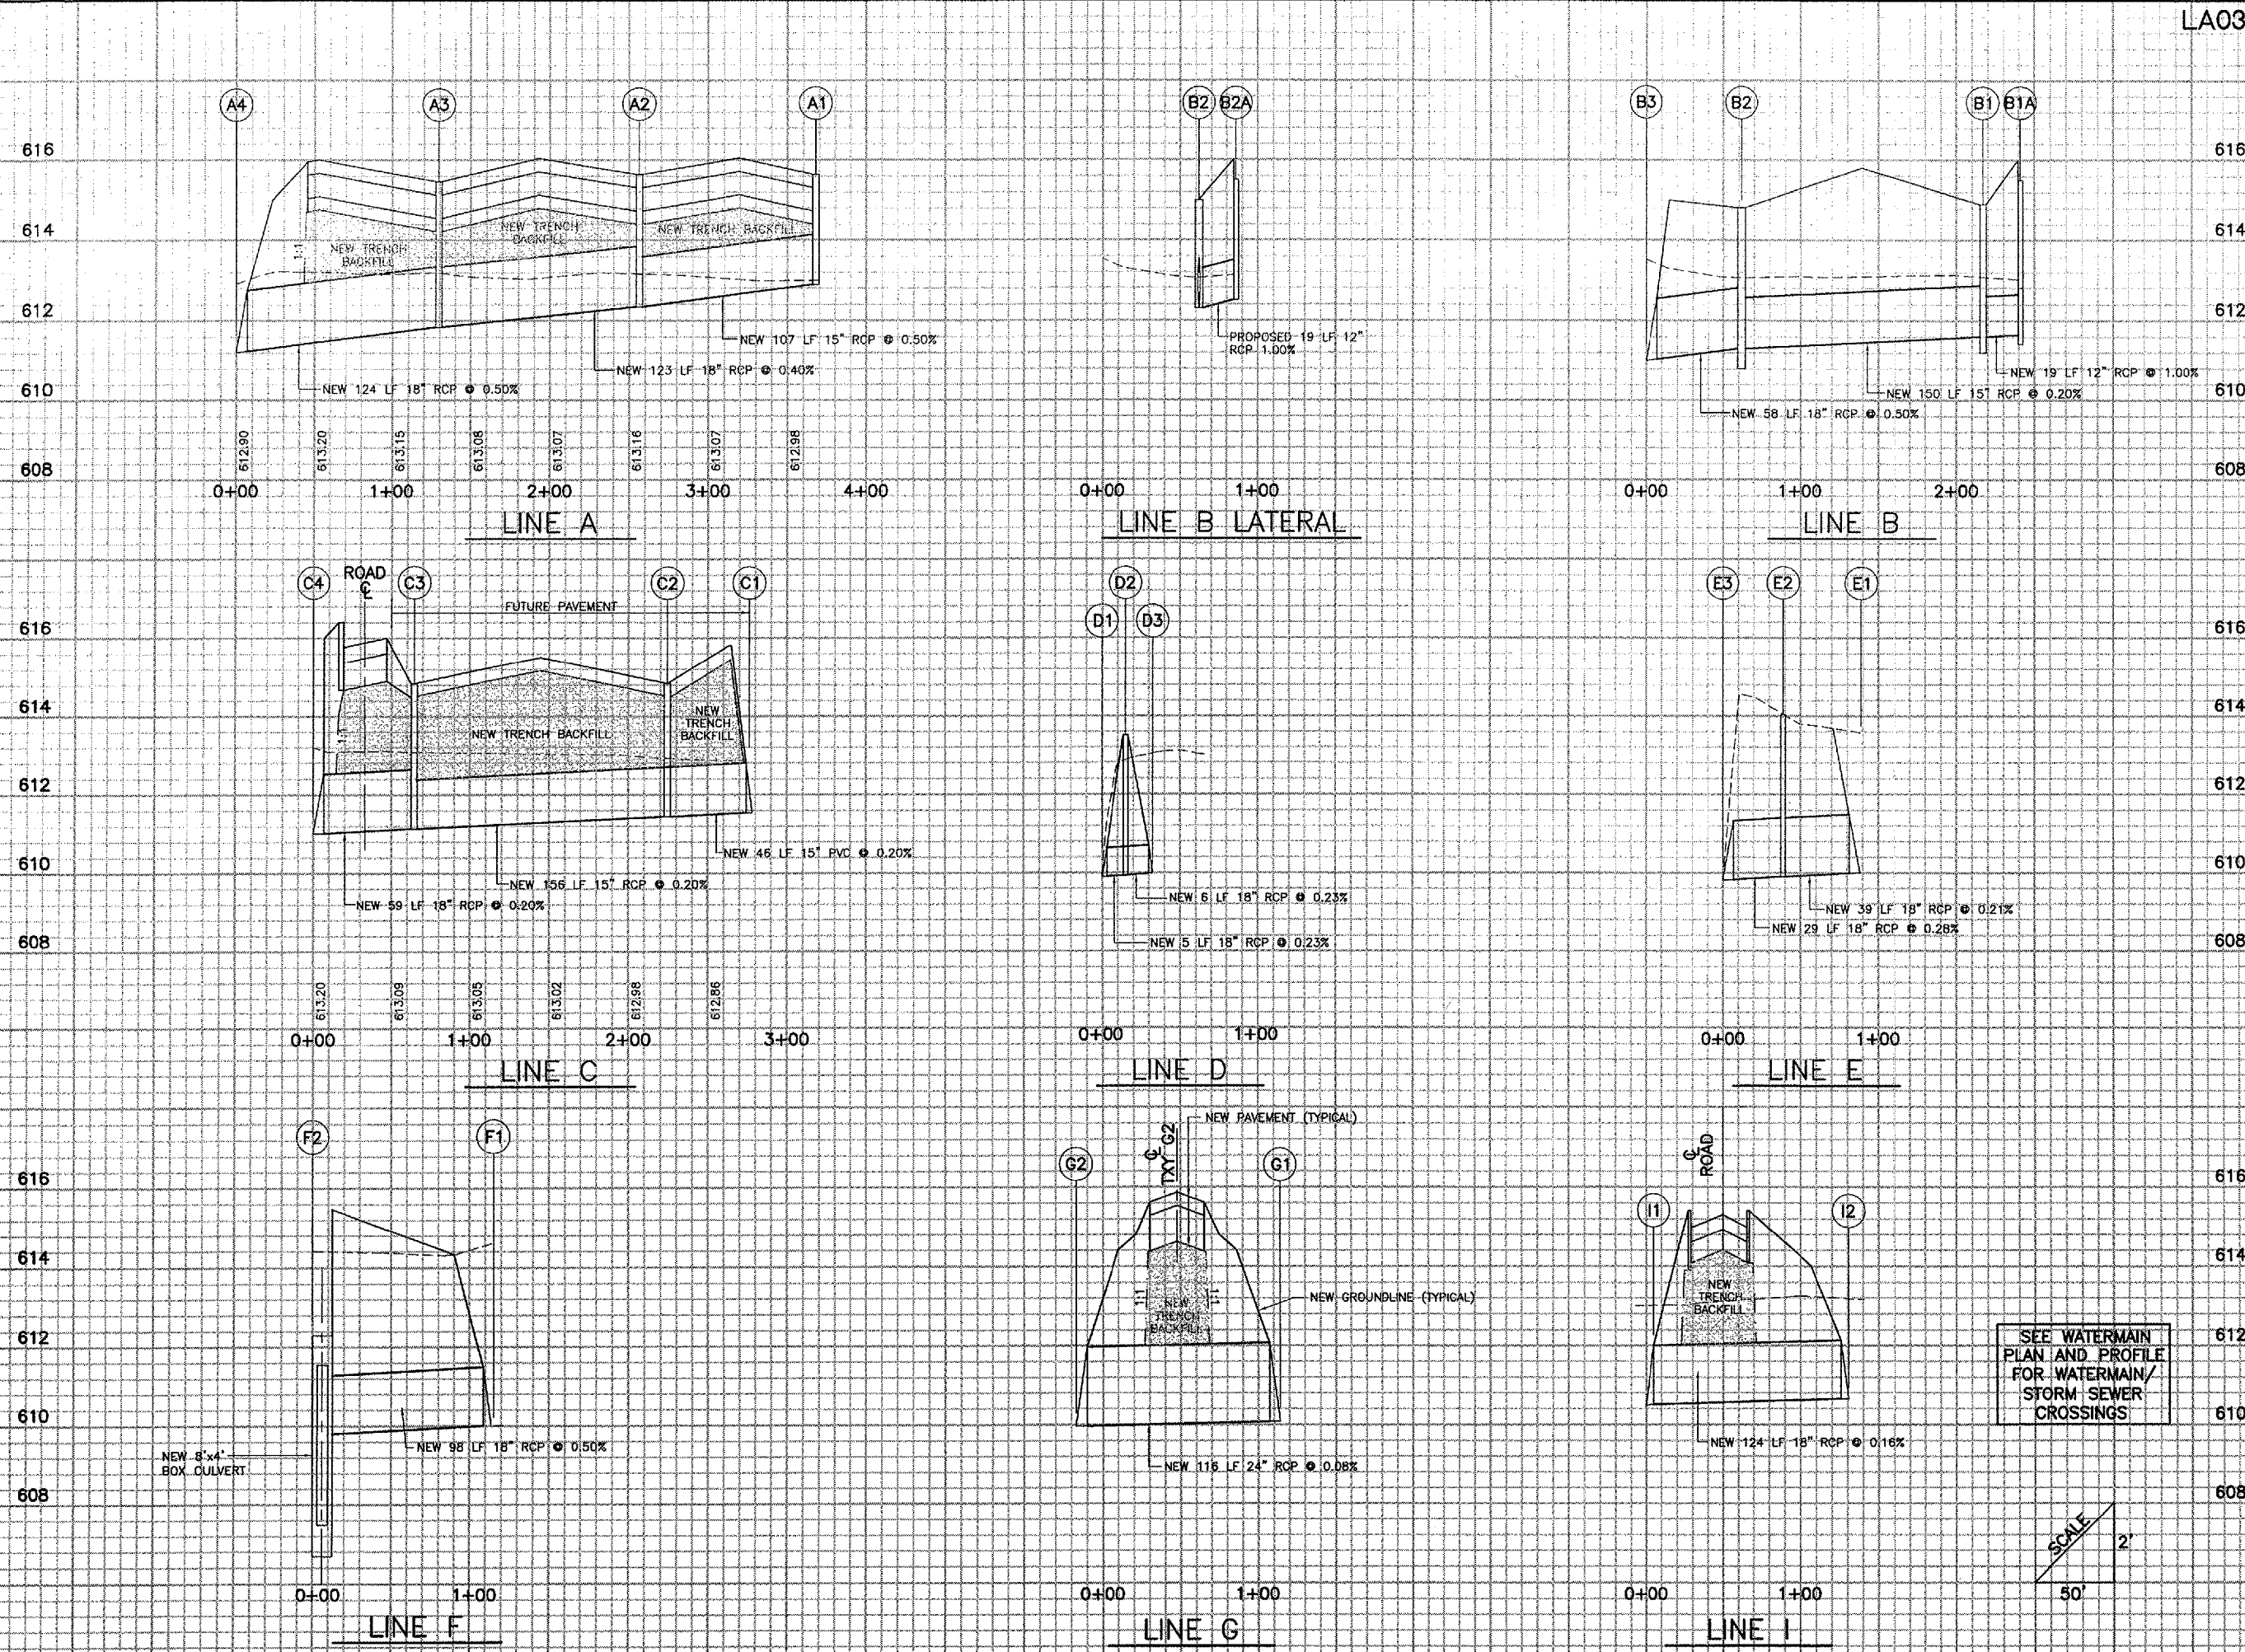

SEE WATERMAIN  
 PLAN AND PROFILE  
 FOR WATERMAIN/  
 STORM SEWER  
 CROSSINGS

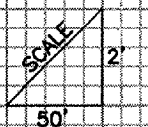

© Copyright CMT, Inc.

**CMT**  
 CRAWFORD, MURPHY & TILLY, INC.  
 CONSULTING ENGINEERS  
 License No. 984-000618

Lansing Municipal  
**airport**

DESIGN BY:	ARM
DRAWN BY:	JRO
CHECKED BY:	ARM
APPROVED BY:	
DATE:	03/04/05
JOB No:	03297-02
IL PROJECT: IGQ-3329 A.I.P. PROJECT: 3-17-0121-B21	
SHEET 16 OF 50 SHEETS	