
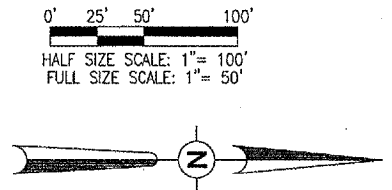


07/14/2005, 08:18 AM Bok

I:\airports\MtSterling\818-05TXY\Airport\Sheets\R-131-DRN.dgn

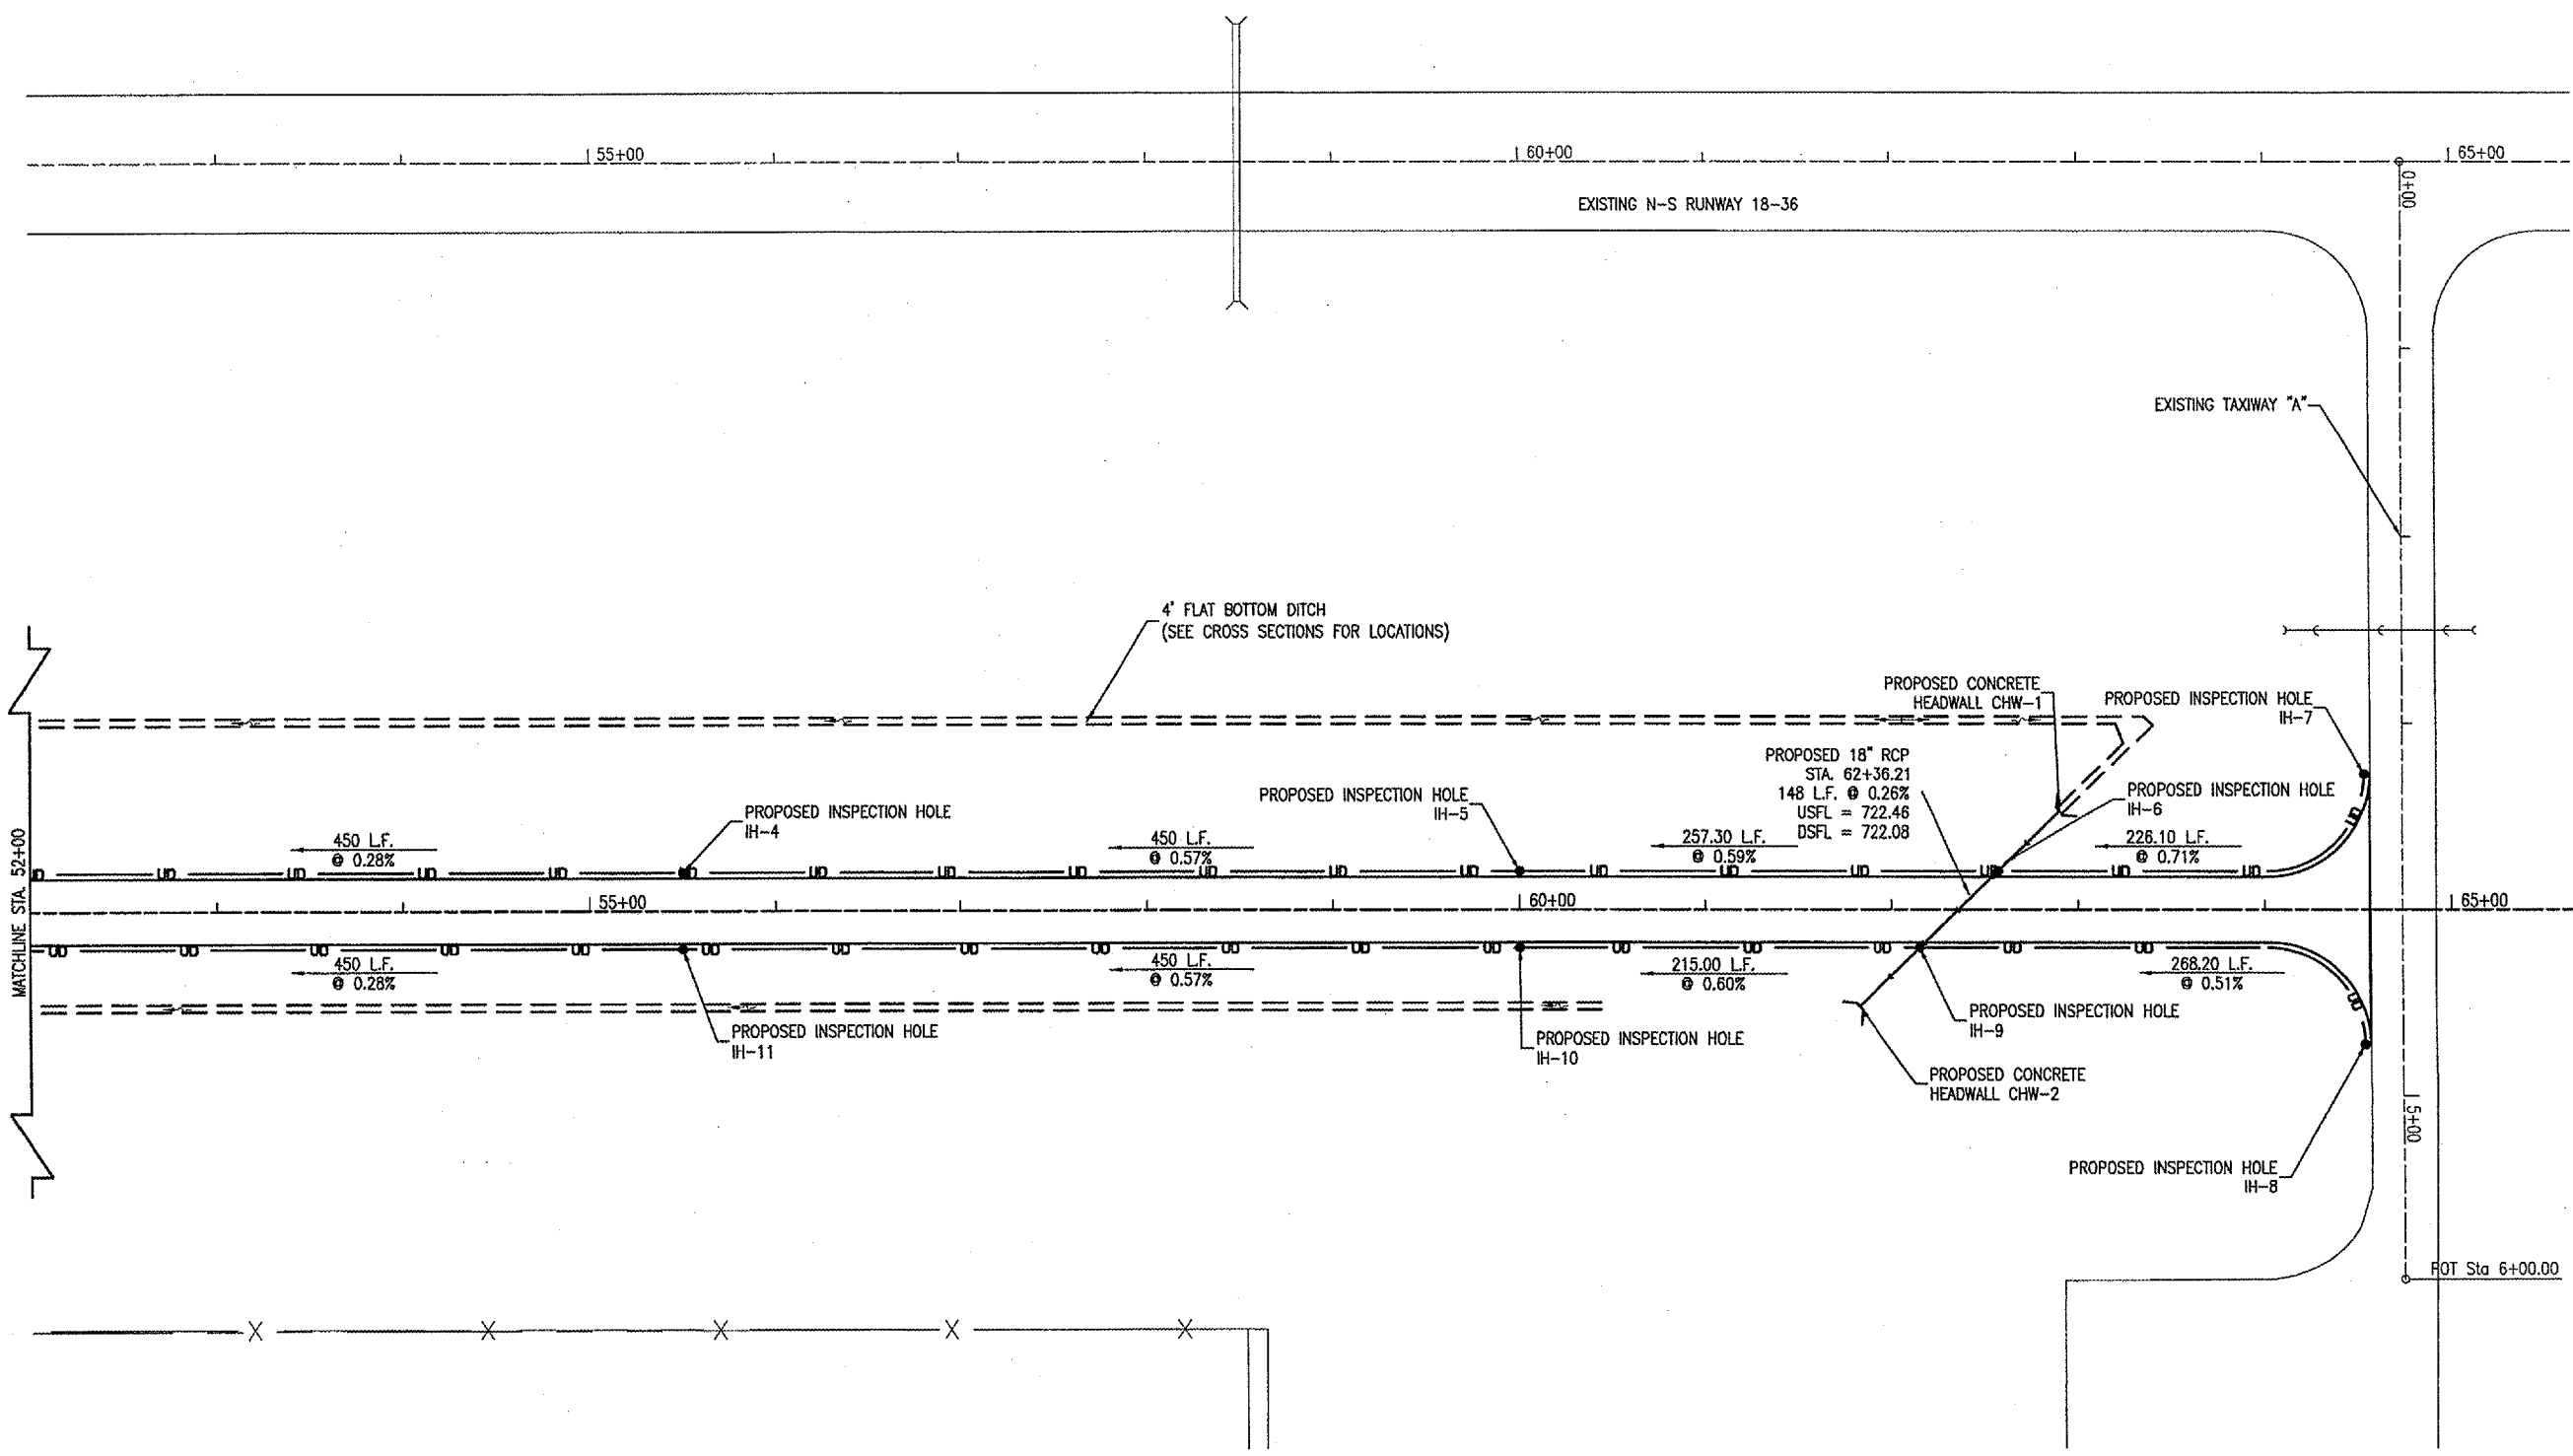

- LEGEND**
- EXISTING IMPROVEMENTS
 - PROPOSED IMPROVEMENTS
 - UD — PROPOSED 6" P.E. TUBING (WRAPPED)
 - PROPOSED INSPECTION HOLE
 - ▲— PROPOSED RCP PIPE
 - ▲— PROPOSED PRECAST FLARED END SECTION
 - +— PROPOSED DITCH SUMMIT
 - +— DITCH FLOW

REVISION	DATE	BY

MT. STERLING MUNICIPAL AIRPORT
 MT. STERLING, ILLINOIS
 A.I.P. PROJ.: 3-17-0417-B6
 I.L. PROJ.: 163-3431

I.E.L. Project No. 818-05TXY	
Drawing No. R-131DRN	
Scale: 1"=50'	
Date: 04/28/05	
LAYOUT	JEO 03/14/05
DRAWN	JEO 03/21/05
REVIEWED	CAH 05/17/05

HANSON
 Hanson Professional Services Inc.
 1525 South Sixth Street
 Springfield, Illinois 62793-2886
 Chicago Nationwide

PARALLEL TAXIWAY
 TAXIWAY "B"
 PROPOSED
 DRAINAGE PLAN
 STA. 52+00 TO STA. 65+00