
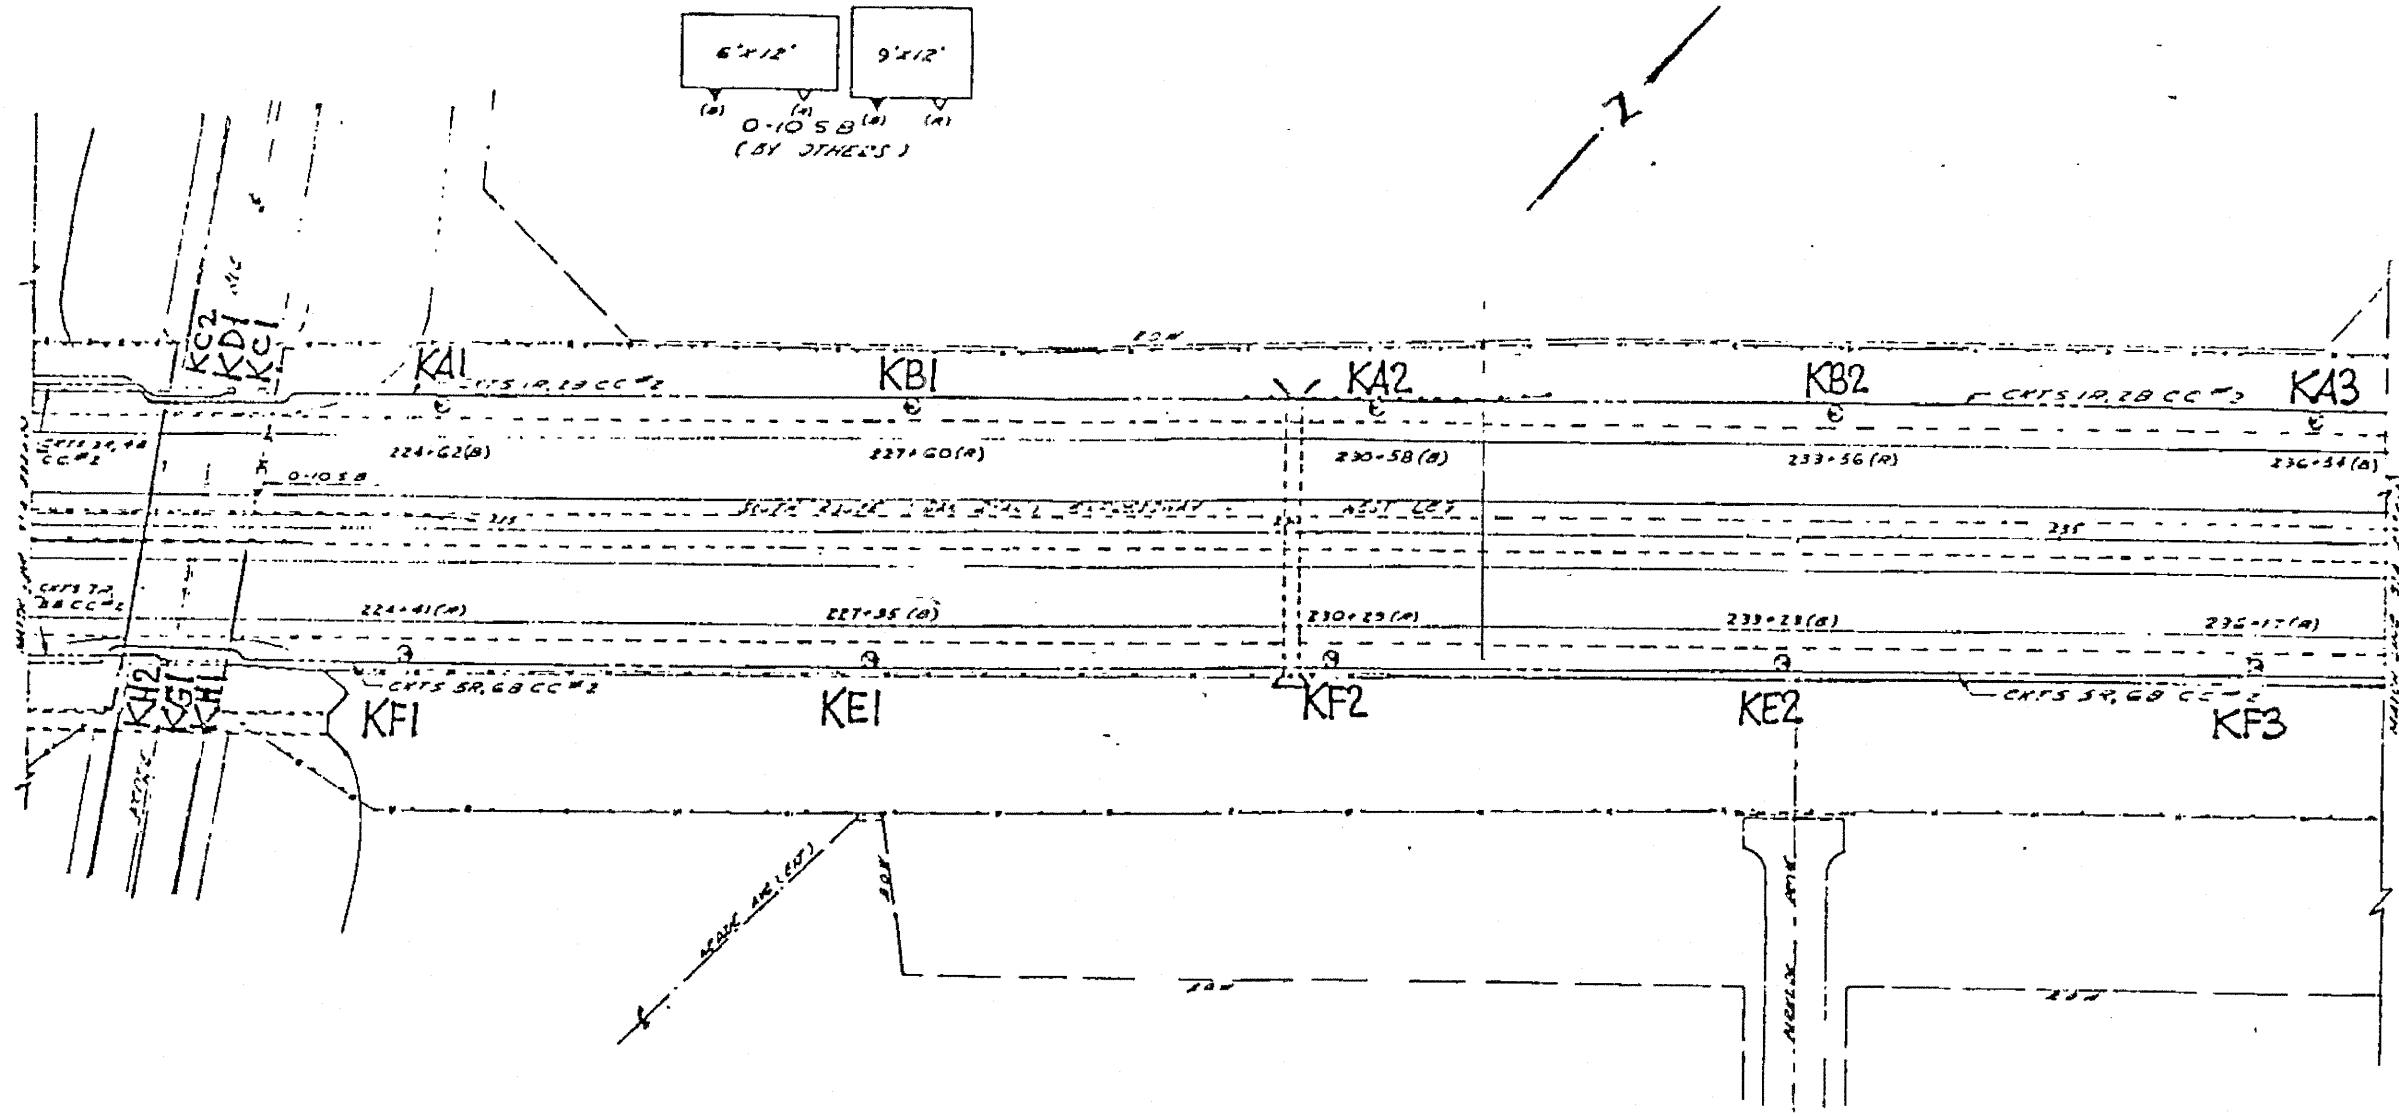


County	File No.	Sheet No.	Total Sheets
068	111430	11	11

PROPOSED SIGN

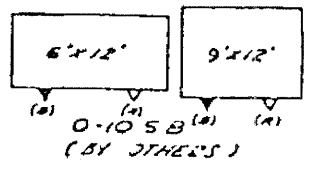

FOR INFORMATION ONLY

40

COUNTY OF COOK
DEPARTMENT OF HIGHWAYS

PLAN SHEET
NO. 111430

TYLIN INTERNATIONAL	USER NAME = #USER#	DESIGNED - DM	REVISED -	STATE OF ILLINOIS DEPARTMENT OF TRANSPORTATION	KEDZIE AVENUE PROJECT EXISTING LIGHTING PLAN		F.A. RTE.	SECTION	COUNTY	TOTAL SHEETS	SHEET NO.	
	PLOT SCALE = #SCALE#	DRAWN - DM	REVISED -		SCALE: N.T.S.	SHEET NO. 2 OF 3 SHEETS	STA. TO STA.	57	1313.1B-1	COOK	162	107
	PLOT DATE = 5/3/2011	CHECKED - SES	REVISED -		DATE - 5/5/2011	REVISED -	FED. ROAD DIST. NO.	ILLINOIS FED. AID PROJECT	CONTRACT NO. 60K14			