



TYPICAL SPLICE DETAIL

N.T.S.

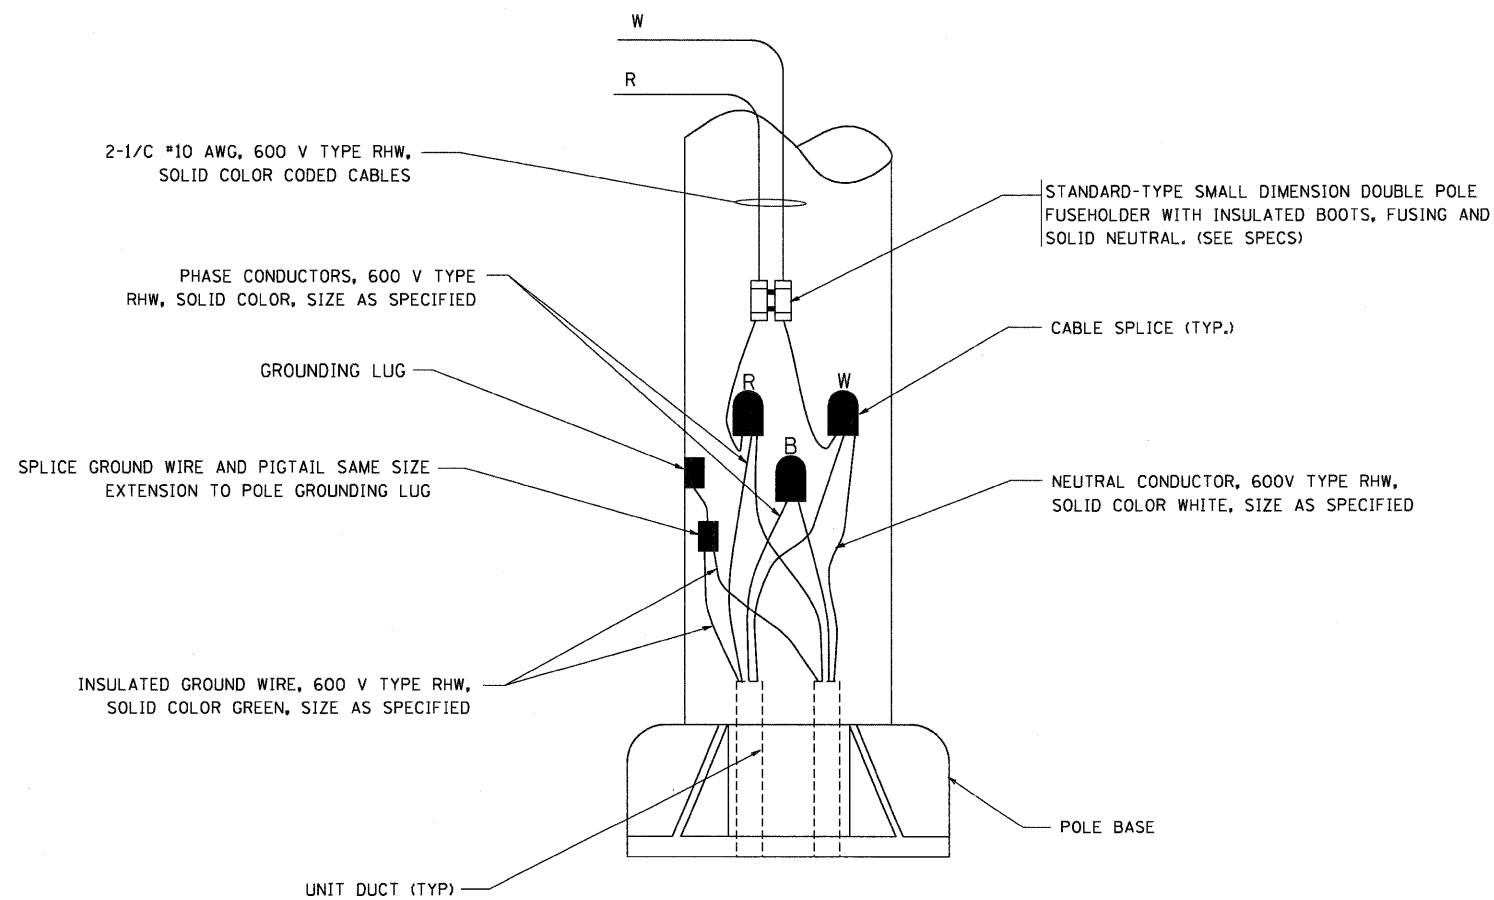

POLE WIRING DETAIL

N.T.S.

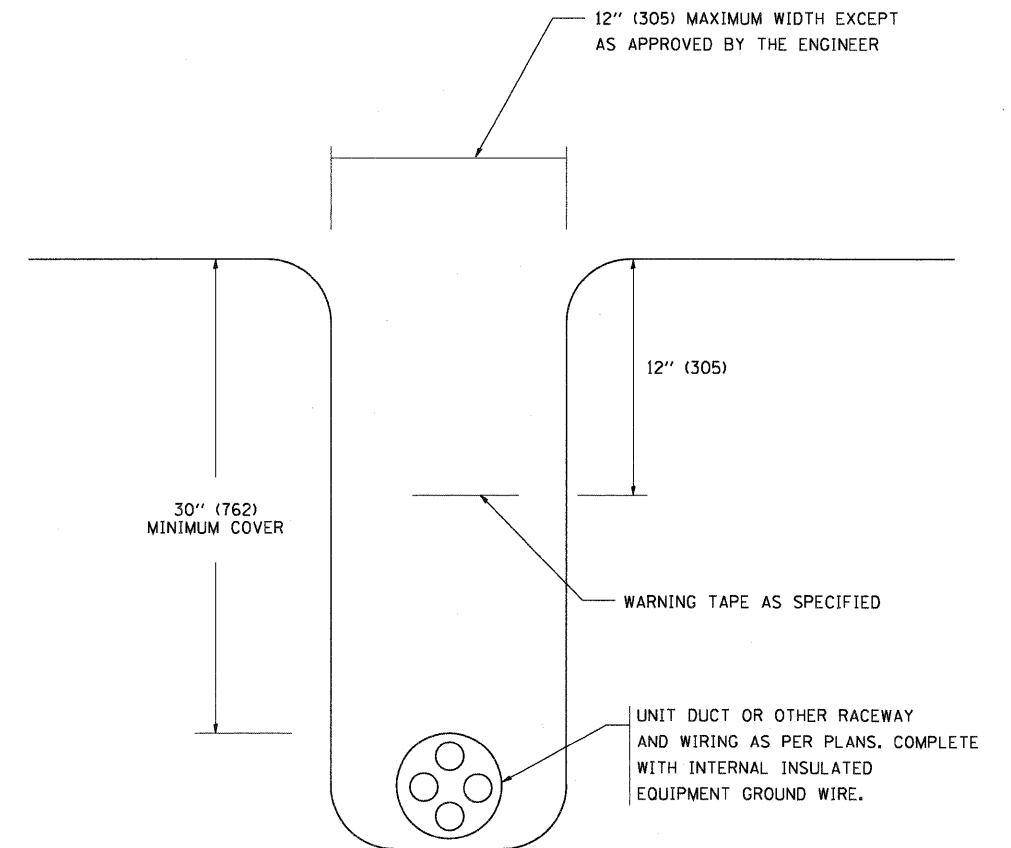

TYPICAL WIRING IN TRENCH DETAIL

N.T.S.

FILE NAME =	USER NAME = geglennob
W:\d:\ststd\22x34\be702.dgn	

DESIGNED -	REVISED - 08-08-03
DRAWN -	REVISED -
PLOT SCALE = 50.000 ' / IN.	CHECKED -
PLOT DATE = 1/4/2008	DATE -

**STATE OF ILLINOIS  
DEPARTMENT OF TRANSPORTATION**

<b>MISC. ELECTRICAL DETAILS SHEET A</b>			
SCALE: NONE	SHEET NO. 1 OF 1 SHEETS	STA.	TO STA.

F.A.P. RTE.	SECTION	COUNTY	TOTAL SHEETS	SHEET NO.
345	8R-HB-2-BY-1	KANE	434	239
<b>BE-702</b>			<b>CONTRACT NO. 60K90</b>	
FED. ROAD DIST. NO. 1 ILLINOIS FED. AID PROJECT				