 

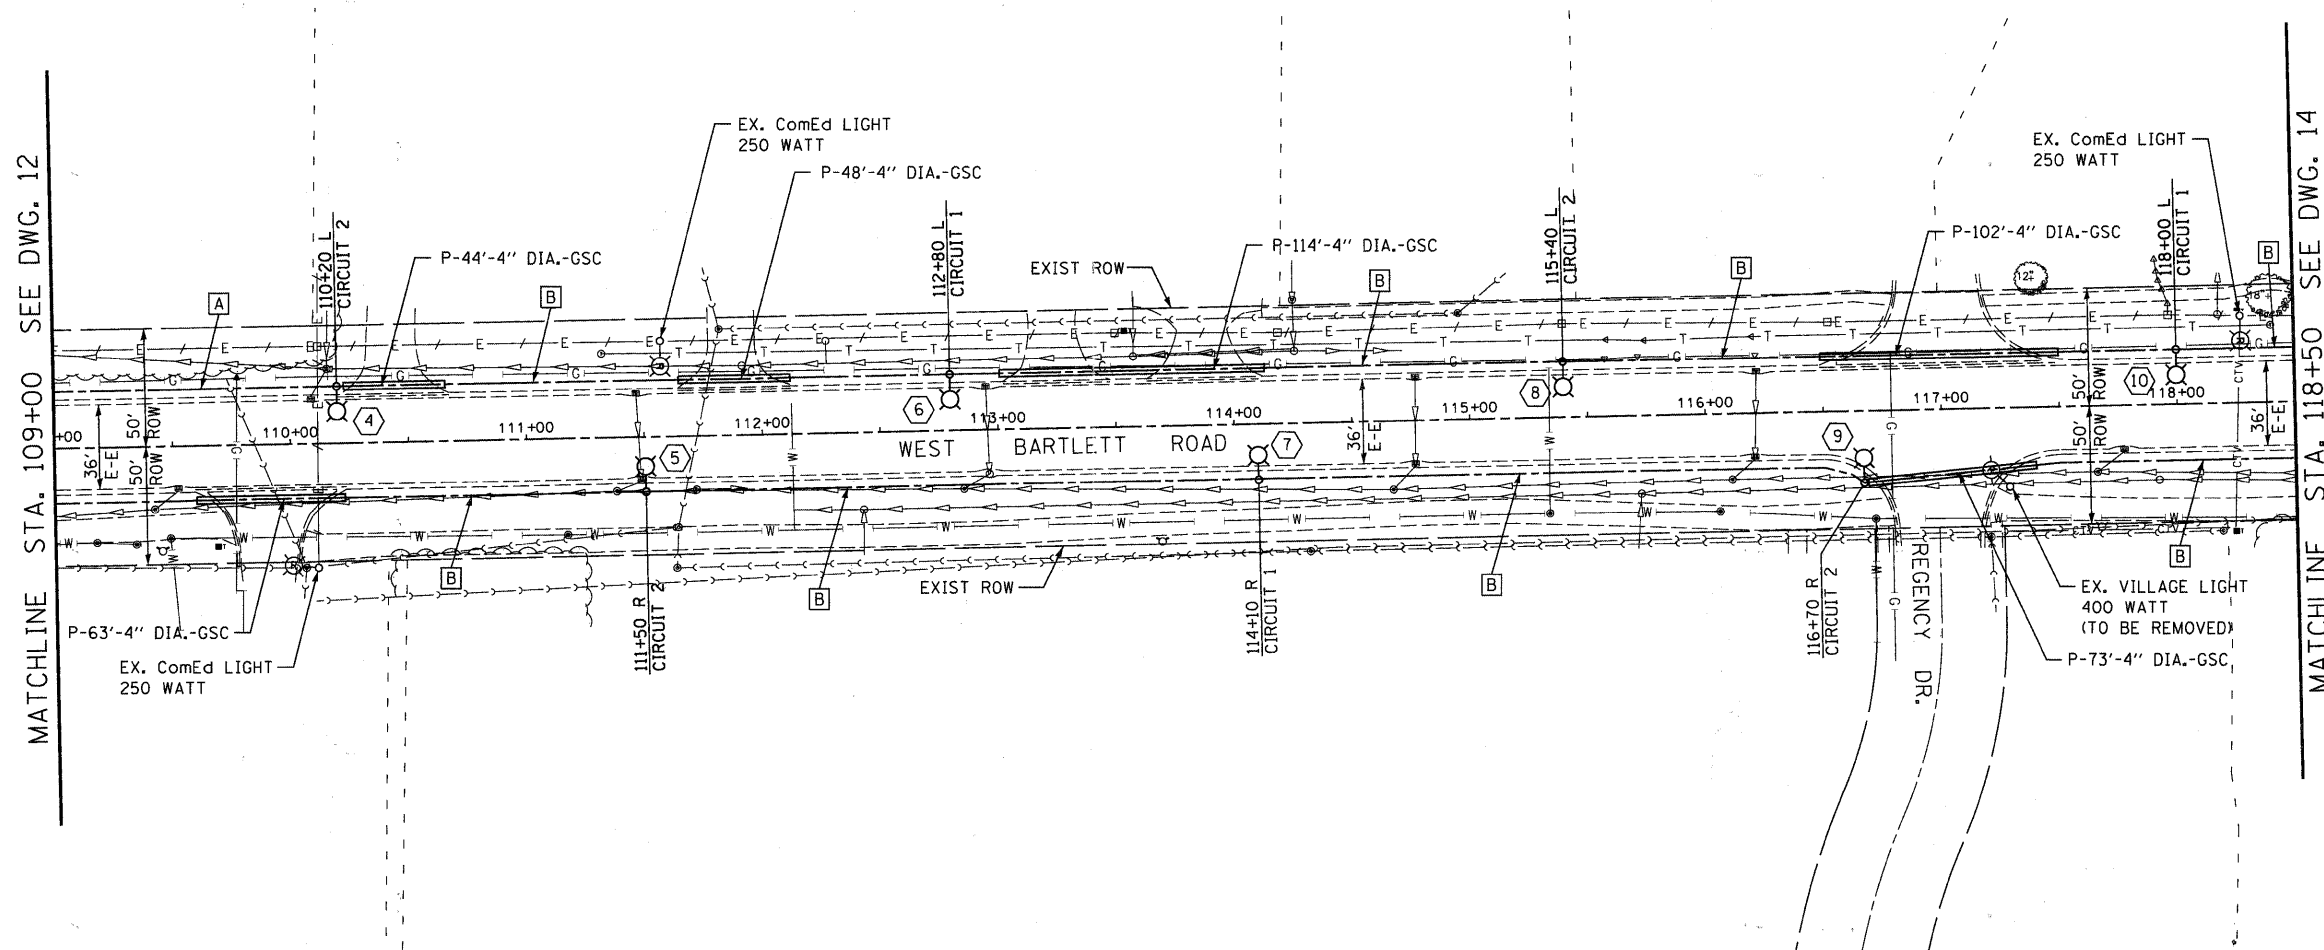


CABLE TABLE

- A UNIT DUCT, 600V, 2-1/C #6 & 1-1/C #6 GROUND (XLP-TYPE USE) IN 1" DIA. POLYETHYLENE CONDUIT
- B UNIT DUCT, 600V, 4-1/C #6 & 1-1/C #6 GROUND (XLP-TYPE USE) IN 1 1/4" DIA. POLYETHYLENE CONDUIT
- C UNIT DUCT, 600V, 2-1/C #4 & 1-1/C #4 GROUND (XLP-TYPE USE) IN 1" DIA. POLYETHYLENE CONDUIT
- D UNIT DUCT, 600V, 4-1/C #4 & 1-1/C #4 GROUND (XLP-TYPE USE) IN 1 1/2" DIA. POLYETHYLENE CONDUIT

LEGEND

- SERVICE LINE - ELECTRIC CABLE IN CONDUIT
600V (XLP-TYPE USE) 2-1/C #2 & 1-1/C #6 GROUND WIRE
- CONDUIT - POLYETHYLENE (SIZE AS NOTED)
- PROPOSED STREET LIGHT POLE WITH 2 LED LAMPS (SEE DETAIL SHEET 25)
- ⊗ PROPOSED STREET LIGHT POLE WITH 1 LED LAMP (SEE DETAIL SHEET 25)
- ▣ PROPOSED STREET LIGHT CONTROLLER CABINET
- ▣ PROPOSED HANDHOLE
- EXISTING LIGHT POLE TO REMAIN
- EXISTING LUMINAIRE AND MAST ARM TO BE REMOVED (BY COMED)
- PROPOSED 4" DIA GALVANIZED STEEL SLEEVE
- ⊗ PROPOSED STREET LIGHT POLE NUMBER

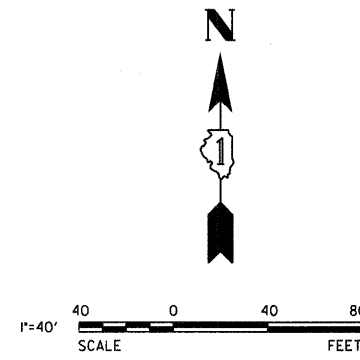

| | | |
|--------------------|----------------|-----------|
| USER NAME = #USER# | DESIGNED - HEV | REVISED - |
| DRAWN - DRP | REVISED - | |
| CHECKED - MJR | REVISED - | |
| DATE - 12-22-10 | REVISED - | |

**WEST BARTLETT ROAD
STREETSCAPE**

LIGHTING AND ELECTRICAL PLANS

| F.A.U. RTE. | SECTION | COUNTY | TOTAL SHEETS | SHEET NO. |
|-------------|----------------|--------|--------------|-----------|
| 1344 | 10-00085-00-LT | COOK | 30 | 13 |

SCALE: 1" = 40' SHEET NO. 2 OF 6 SHEETS STA. 109+00 TO STA. 118+50

CONTRACT NO. 63512 ILLINOIS FED. AID PROJECT