
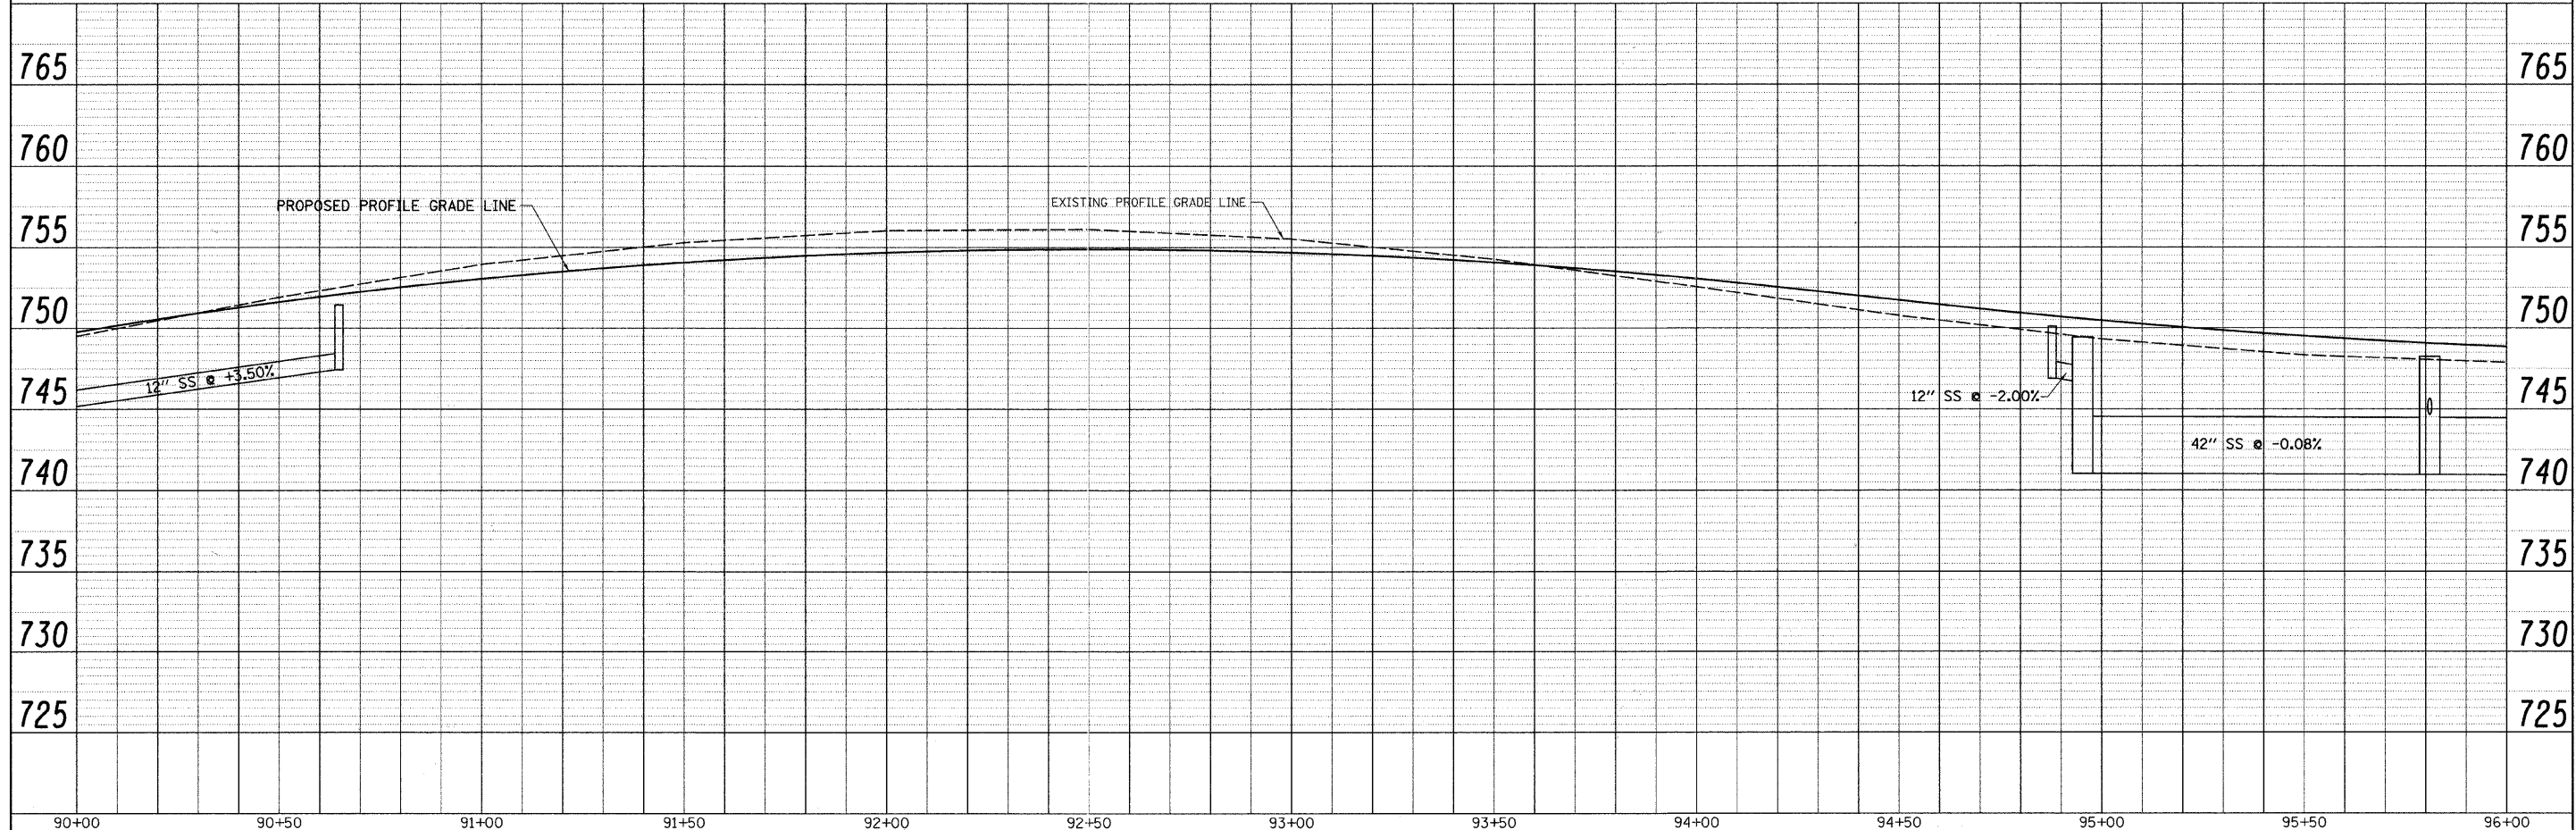


PLAN	SURVEYED	DATE
NOTE BOOK NO.	ALIGNED	BY
	RT. OF WAY CHECKED	
	POD FILE NAME	

PROFILE	SURVEYED	DATE
NOTE BOOK NO.	PLOTTED	BY
	STRUCTURE NOTATIONS CHKD	

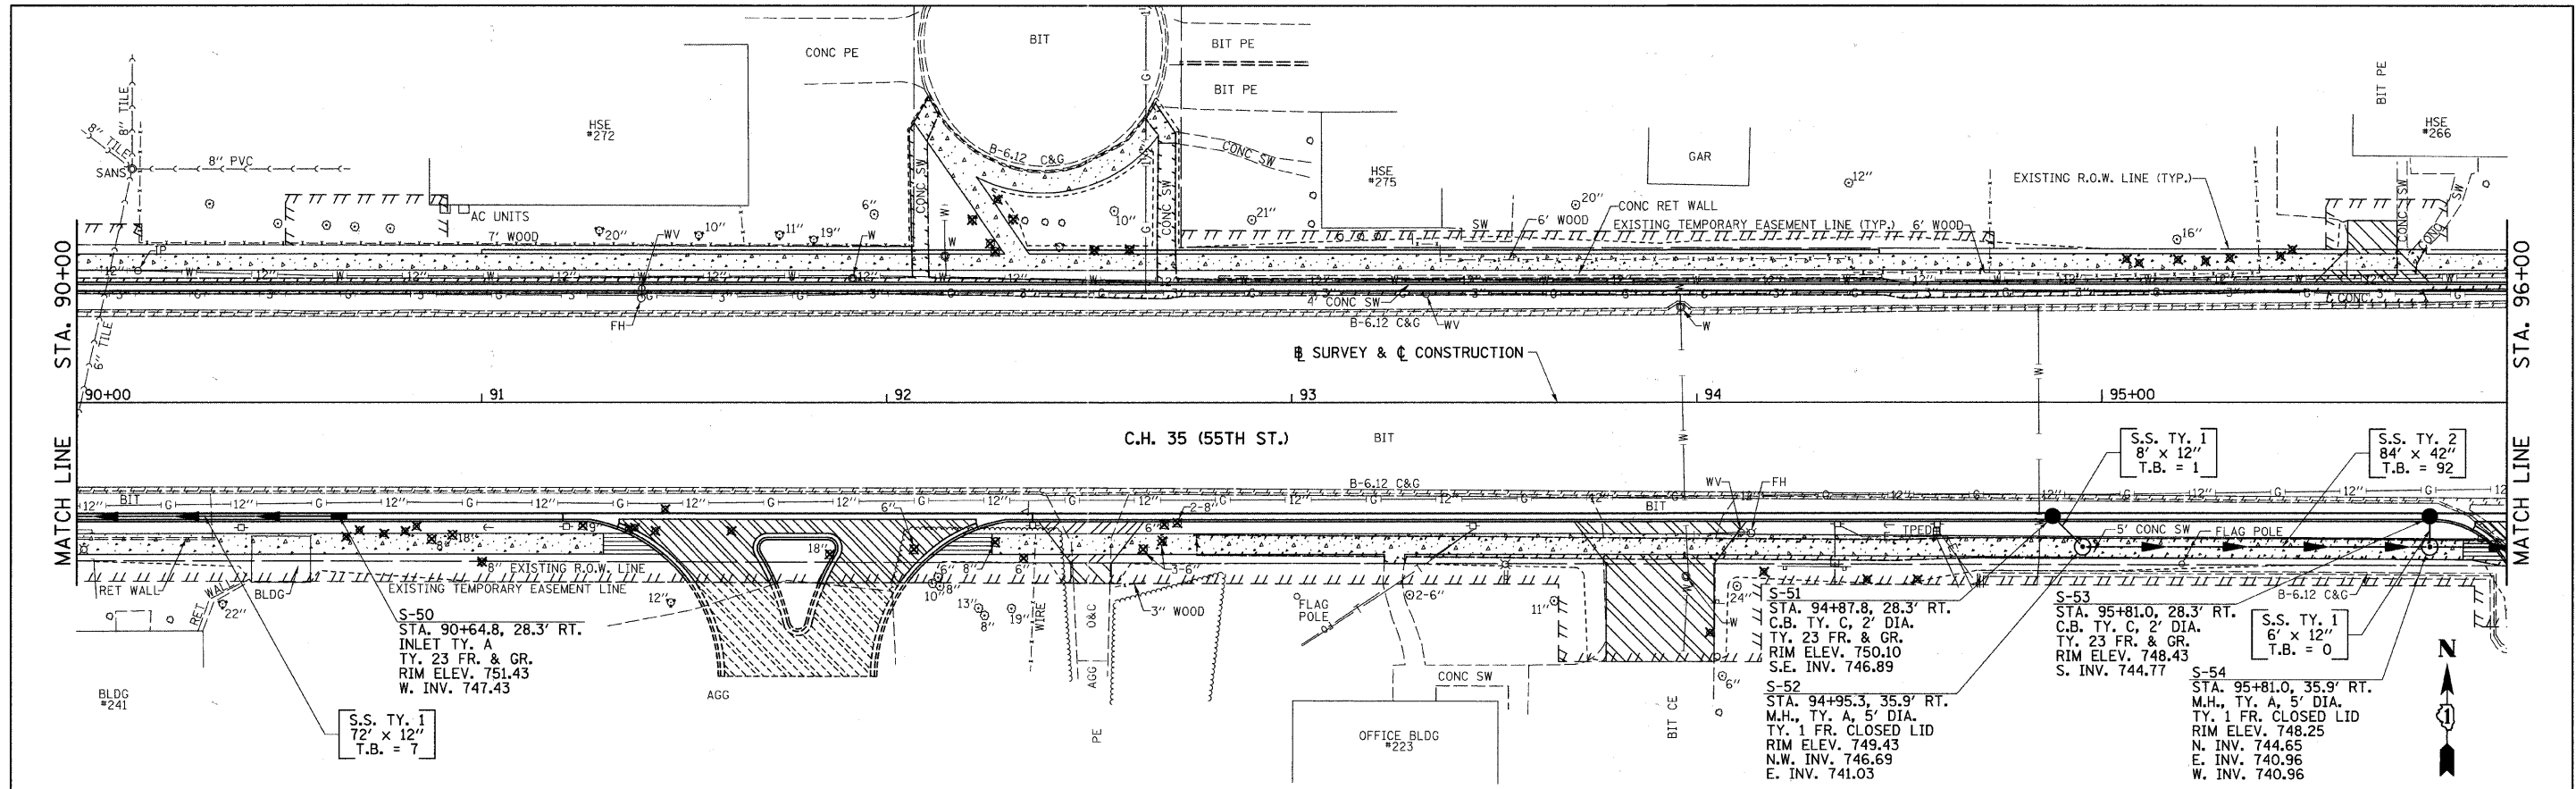

FILE NAME = V:\2791\2791d009.dgn	USER NAME = shughes	DESIGNED -	REVISED -	STATE OF ILLINOIS DEPARTMENT OF TRANSPORTATION	C.H. 35 (55TH ST.) DRAINAGE PLAN & PROFILE			F.A.U. RTE. 1504	SECTION 94-00302-00-FP	COUNTY DU PAGE	TOTAL SHEETS 240	SHEET NO. 111	
	PLOT SCALE = 20.0000' / IN.	CHECKED -	REVISED -		SCALE: H=20 V=5	SHEET NO. 10 OF 11 SHEETS	STA. 90+00 TO STA. 96+00	ILLINOIS FED. AID PROJECT		CONTRACT NO. 63609			
	PLOT DATE = 5/19/2011	DATE -	REVISED -										