


|                     |                |                  |              |           |
|---------------------|----------------|------------------|--------------|-----------|
| F.A. RTE.           | SECTION        | COUNTY           | TOTAL SHEETS | SHEET NO. |
| TR55                | 90-16103-01-BR | WILL             | 255          | 110       |
| STA.                | TO STA.        |                  |              |           |
| FED. ROAD DIST. NO. | ILLINOIS       | FED. AID PROJECT |              |           |
| CONTRACT NO. 83126  |                |                  |              |           |

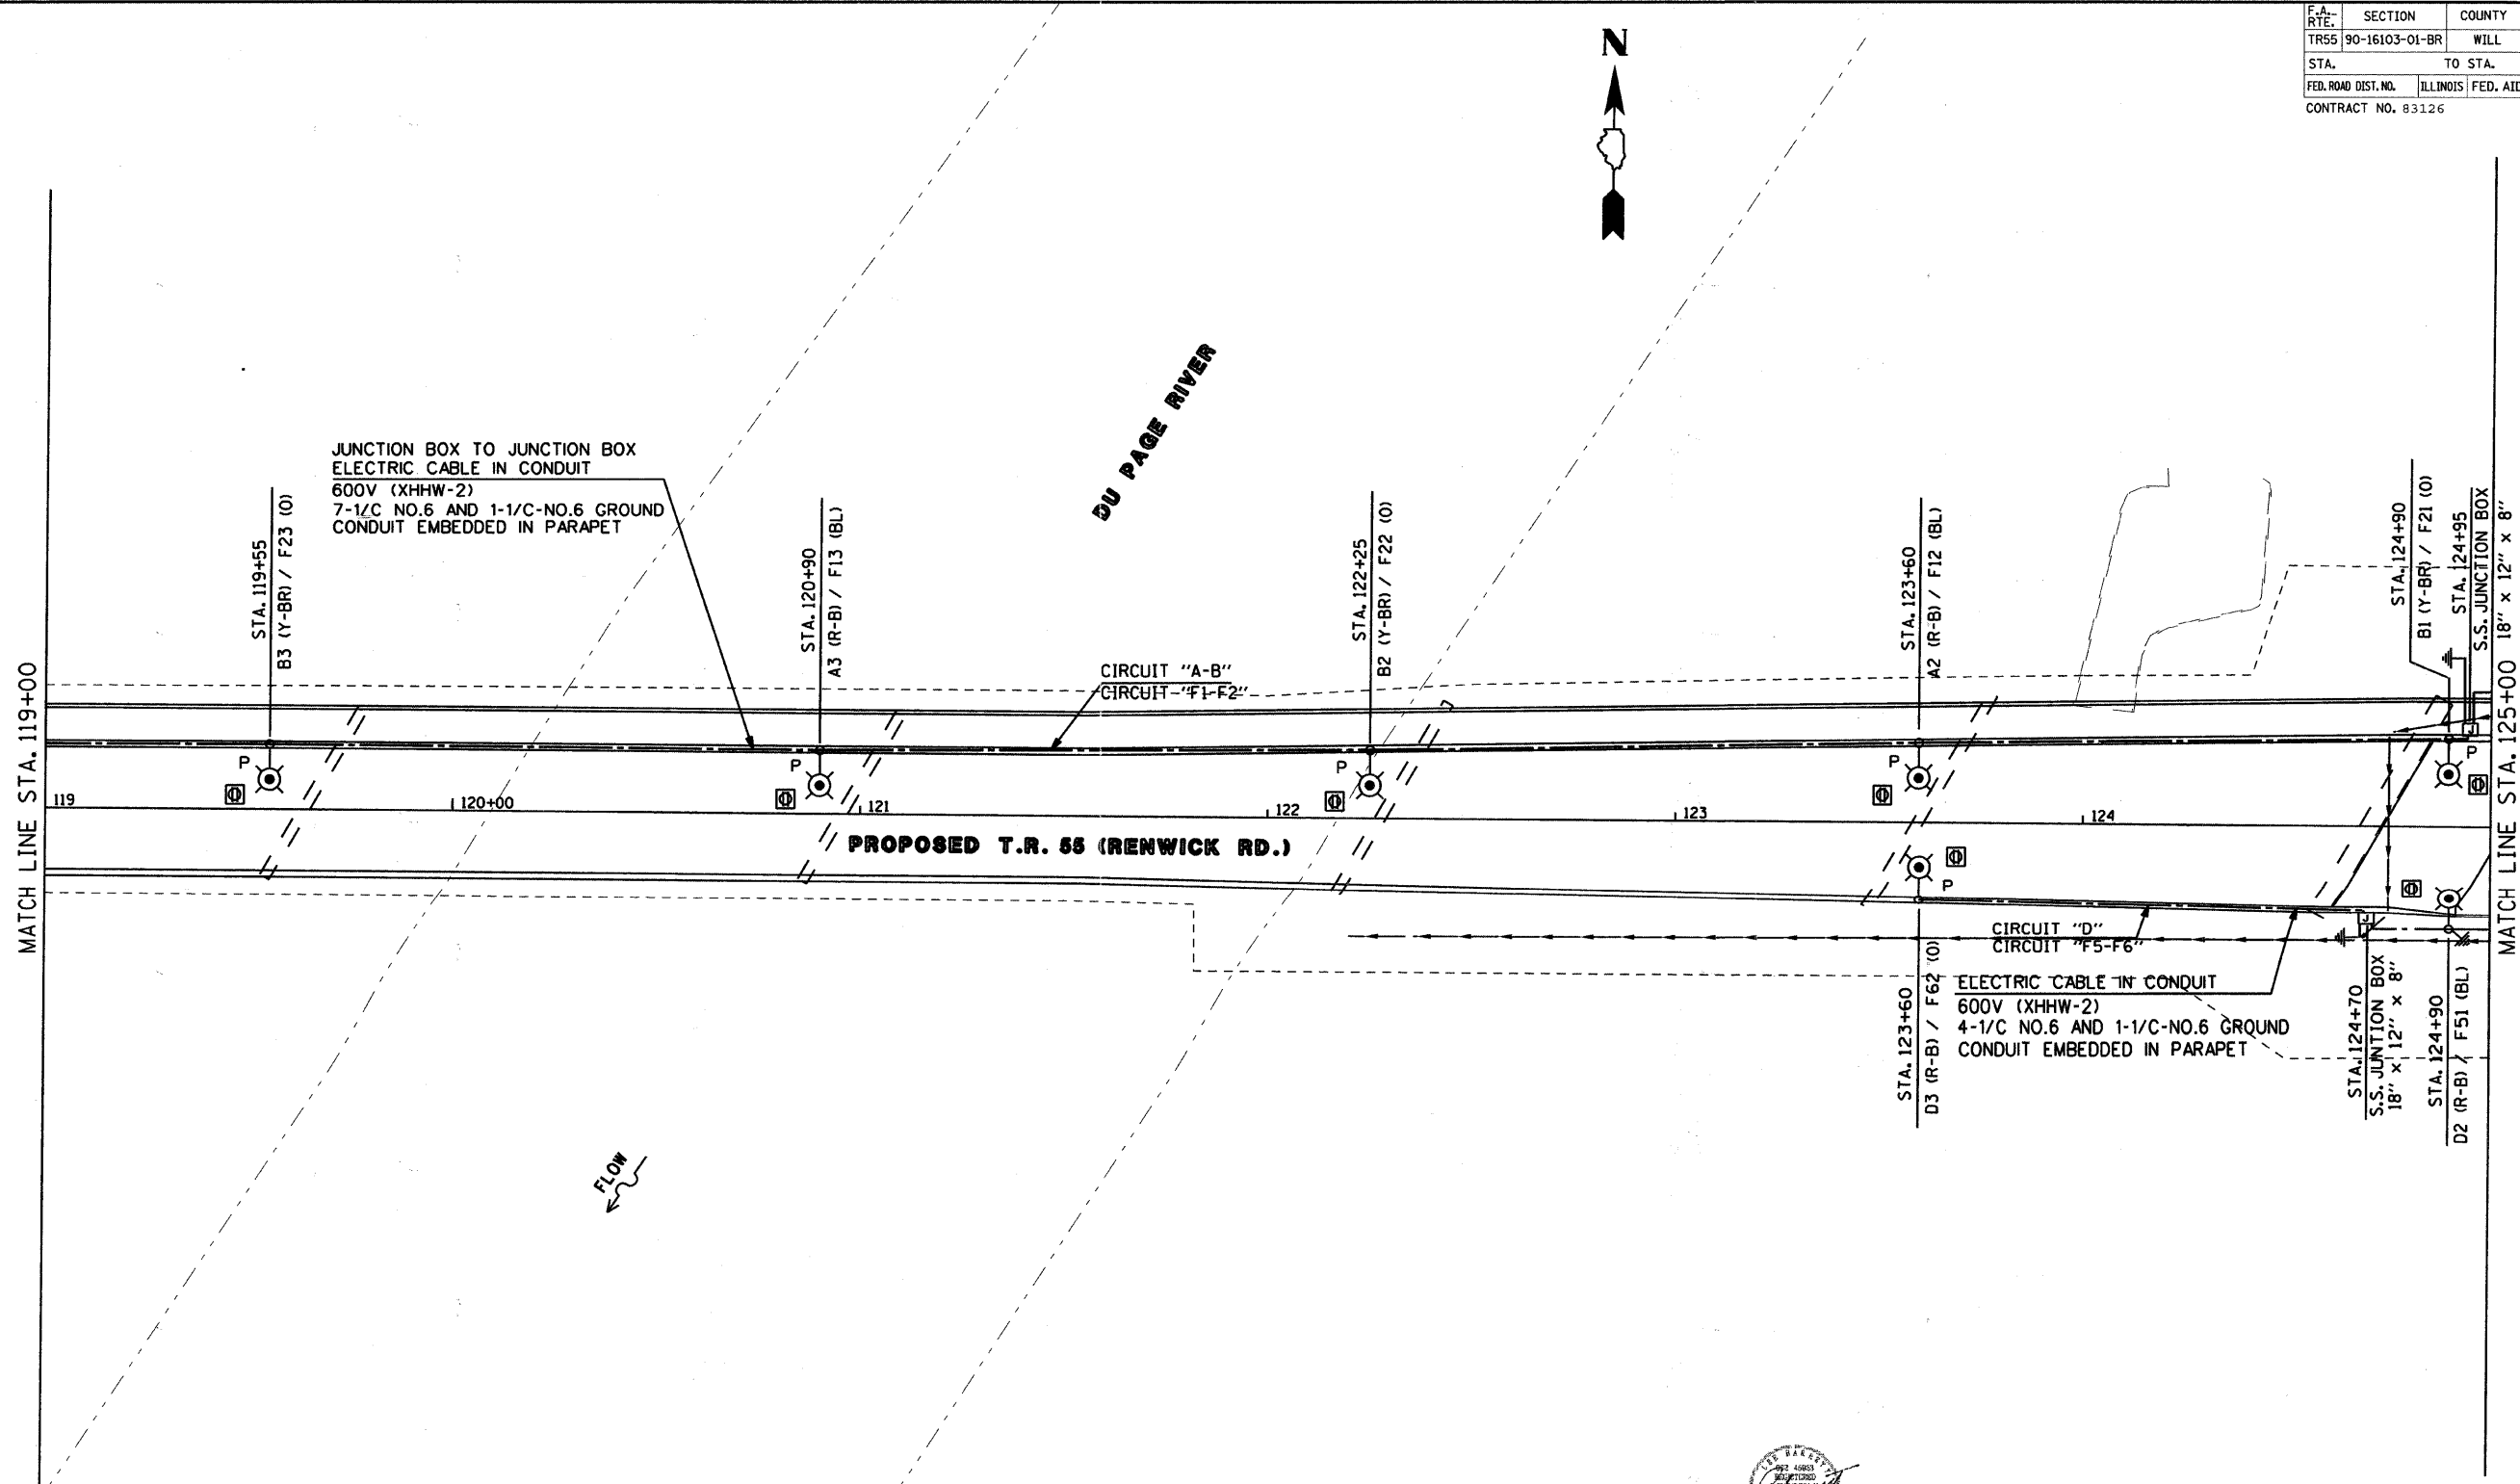

C:\SUNJOY\Projects\RENWICK ROAD\E-4\_of\_E-17.dgn  
4/8/2010



**Sunjoy Inc.**  
Area Lighting  
212 TIMBERCREST DRIVE  
SCHAUMBURG, ILLINOIS  
60193-1572

ILLINOIS DEPARTMENT OF TRANSPORTATION  
T.R. 55 (RENWICK RD.)  
PLANFIELD TOWNSHIP, WILL COUNTY  
**PROPOSED LIGHTING PLAN**  
SCALE:  
DATE: OCT. 30, 2009  
DRAWN BY HKQ  
CHECKED BY JS