
 



F.A. RY.	SECTION	COUNTY	TOTAL SHEETS	SHEET NO.
TR55	90-16103-01-BR	WILL	255	112
STA.		TO STA.		
FED. ROAD DIST. NO.	ILLINOIS	FED. AID PROJECT		
CONTRACT NO. 83126				



C:\SUNJOY\Projects\RENWICK ROAD\E-6_of_E-17.dgn
4/8/2010

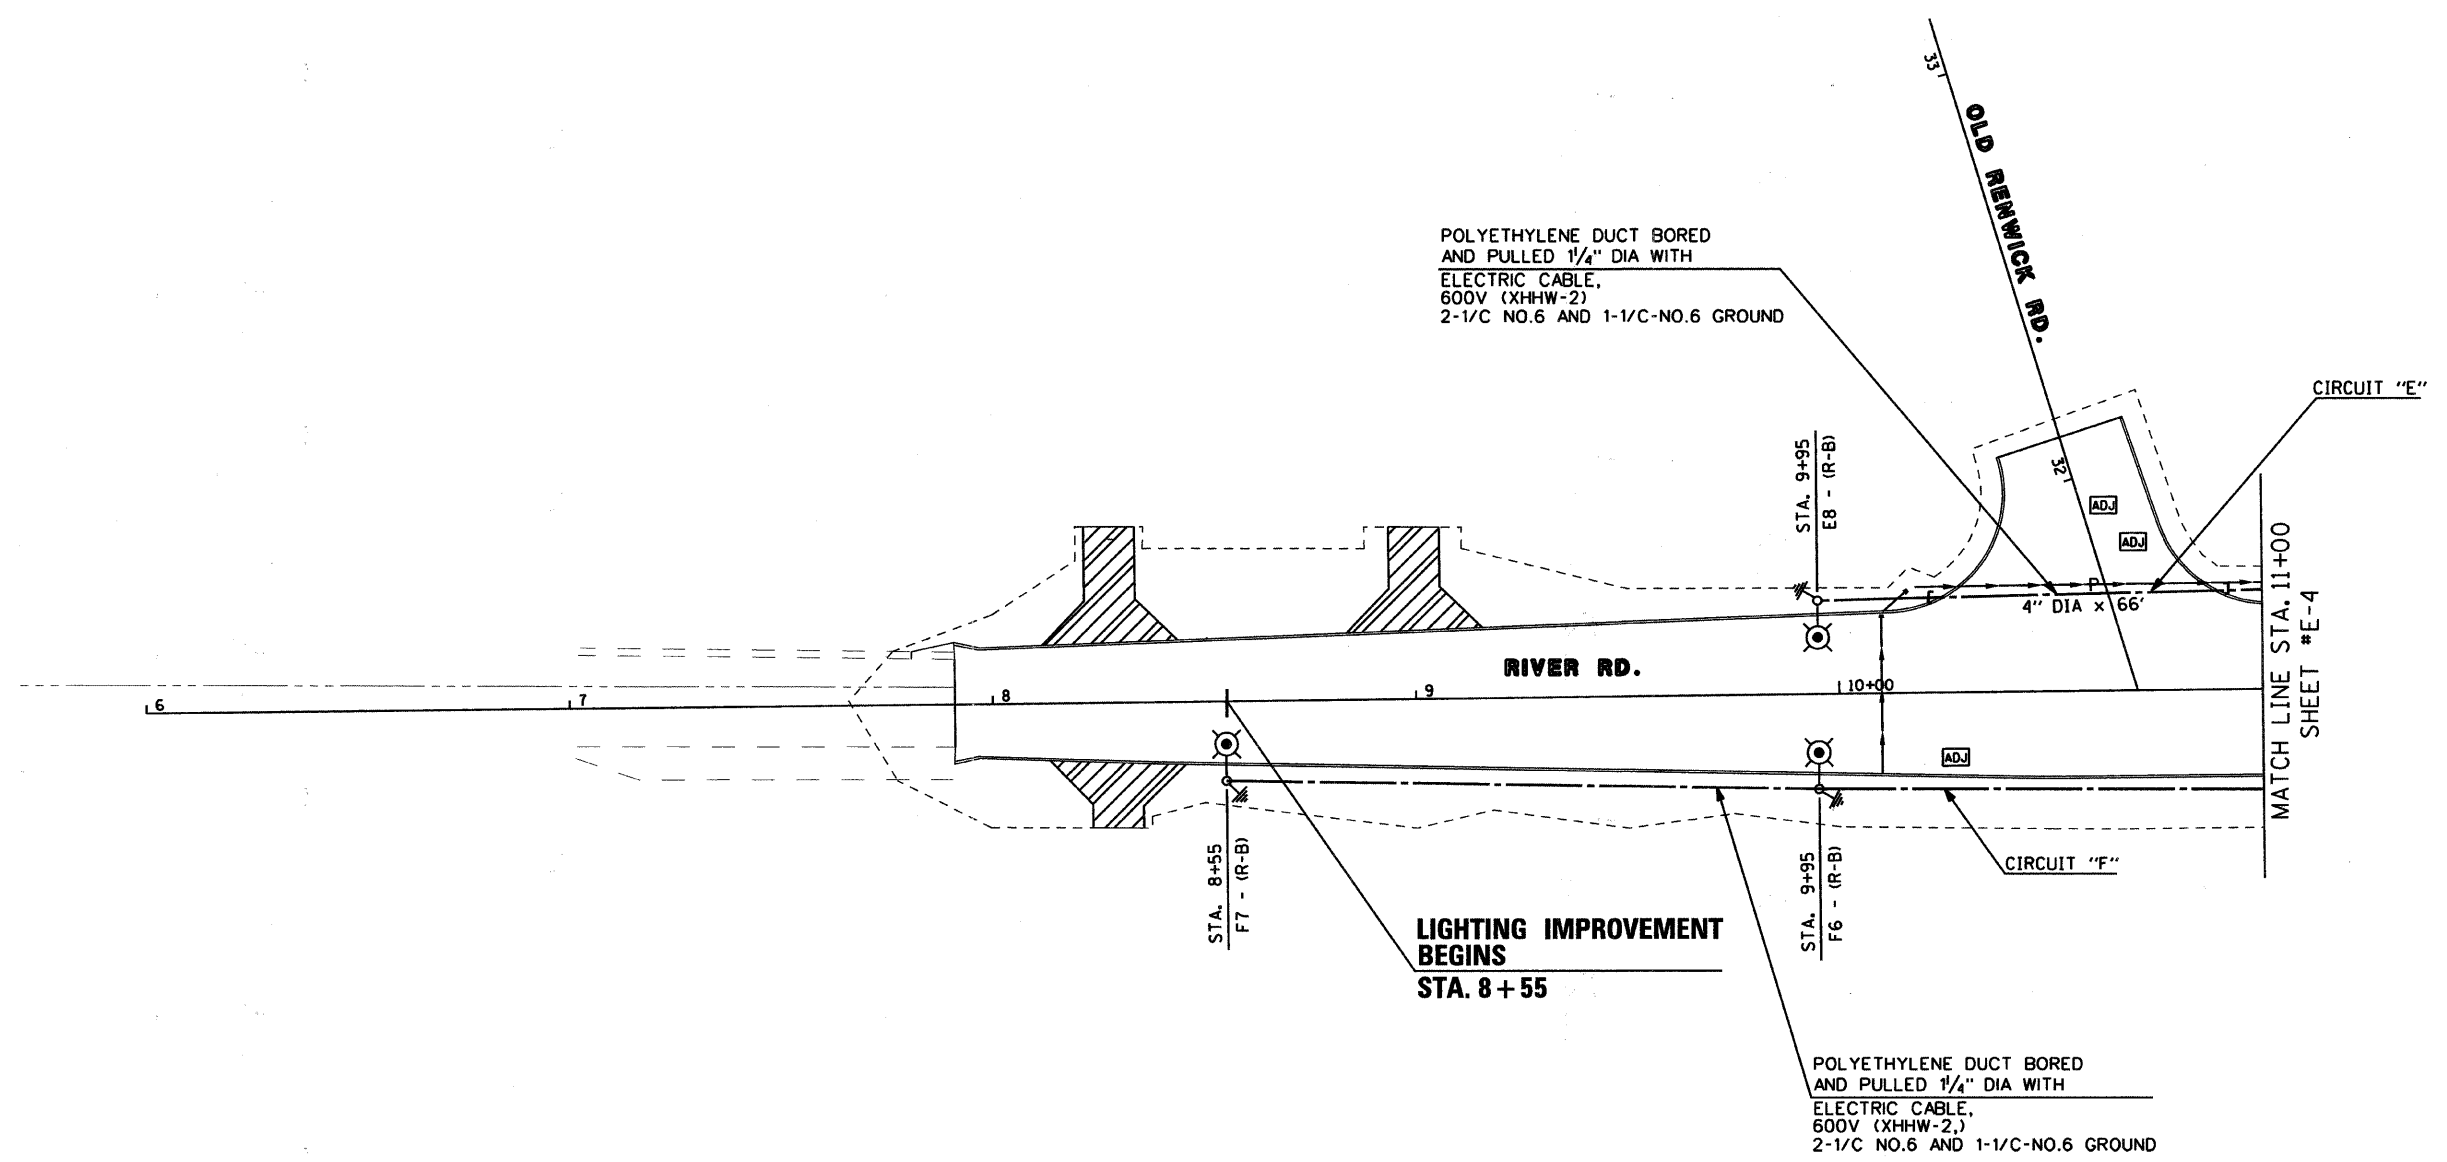



Sunjoy Inc.
Area Lighting
212 TIMBERCREST DRIVE
SCHAUMBURG, ILLINOIS
60193-1572

ILLINOIS DEPARTMENT OF TRANSPORTATION
T.R. 55 (RENWICK RD.)
PLANFIELD TOWNSHIP, WILL COUNTY

PROPOSED LIGHTING PLAN

SCALE: _____
DATE: OCT. 30, 2009

DRAWN BY HKQ
CHECKED BY JS