


**NOTES:**

1. REFER TO DRAWINGS E-04 AND E-05 FOR ELECTRICAL SYMBOLS.
2. REFER TO DRAWING E-06 FOR ELECTRICAL ABBREVIATIONS.
3. REFER TO DRAWING E-10 FOR ELECTRICAL CONDUIT BLOCK DIAGRAM.

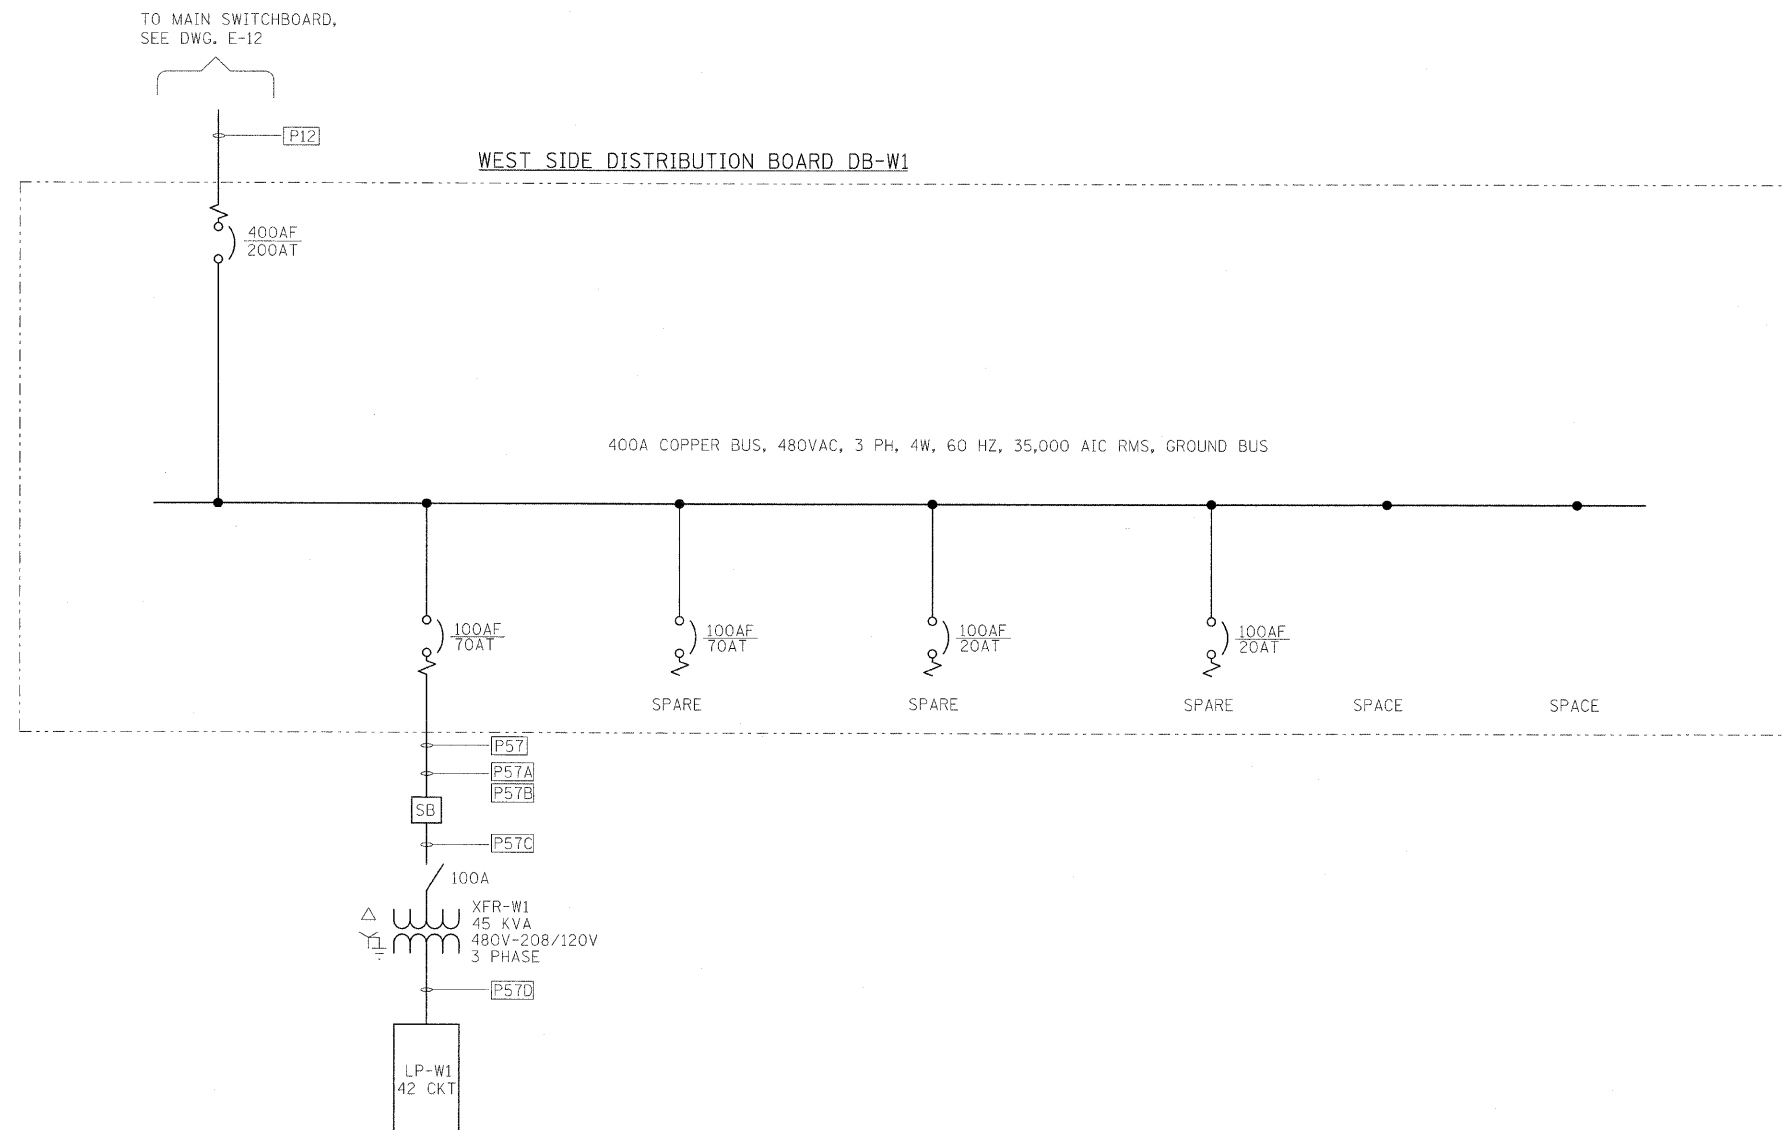

**PB Americas, Inc.**  
 230 WEST MONROE STREET,  
 SUITE 900  
 CHICAGO, IL. 60606

USER NAME = sharma  
 FILE NAME = 0160d61-shr-elo-15.dgn  
 PLOT SCALE = NONE  
 PLOT DATE = 5/7/2009

DESIGNED - A. CENTENO  
 DRAWN - S. SHARMA  
 CHECKED - M. INTATANO  
 DATE - MAY 8, 2009

REVISED -  
 REVISED -  
 REVISED -  
 REVISED -

**STATE OF ILLINOIS  
 DEPARTMENT OF TRANSPORTATION**

**ELECTRICAL ONE LINE DIAGRAM  
 WEST SIDE MCC-W1**

SCALE: AS SHOWN SHEET NO. E-15 OF E-125 SHEETS STA. 379+06.09 TO STA. 382+45.28

F.A.P. RTE.	SECTION	COUNTY	TOTAL SHEETS	SHEET NO.
389	2424-2B-R	COOK	398	266
CONTRACT NO. 60D61				
FED. ROAD DIST. NO. 1 ILLINOIS FED. AID PROJECT				