




**NOTES:**

1. FOR ELECTRICAL SYMBOLS AND ABBREVIATIONS SEE DWGS E-04, E-05 AND E-06.
2. FOR GENERAL NOTES SEE DWG E-02 AND E-04.
3. FOR PANEL SCHEDULES SEE DWG E-64.
4. FOR LIGHT FIXTURES DESCRIPTIONS SEE ELECTRICAL SPECIFICATIONS.

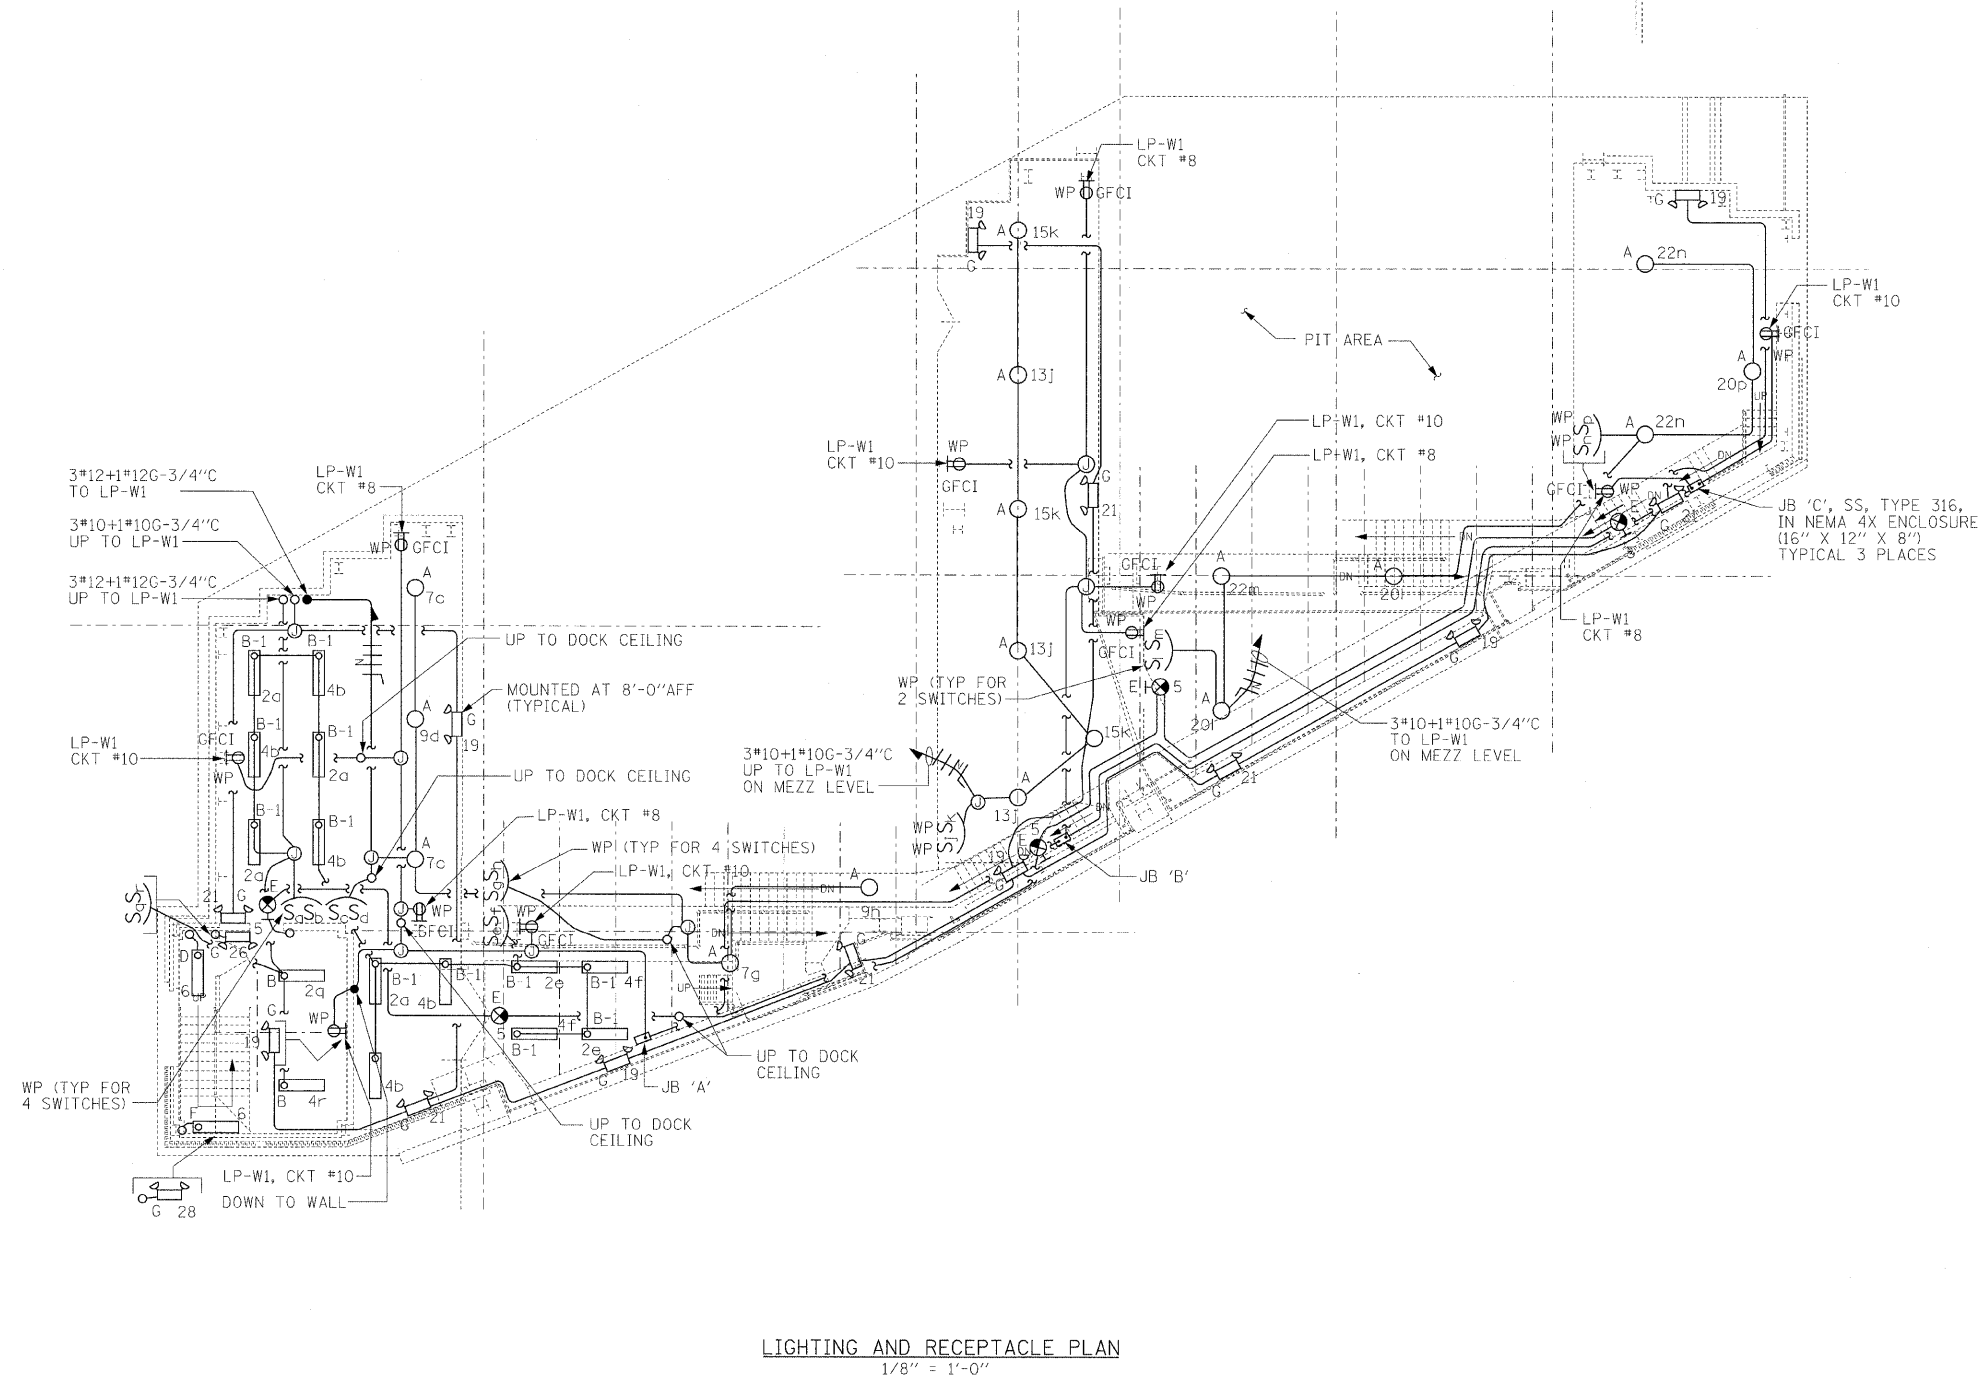

**LIGHTING AND RECEPTACLE PLAN**  
1/8" = 1'-0"

**PB Americas, Inc.**  
230 WEST MONROE STREET,  
SUITE 900  
CHICAGO, IL. 60606

USER NAME = sharma  
FILE NAME = D168d61-shr-elc-35.dgn  
PLOT SCALE = NONE  
PLOT DATE = 5/7/2009

DESIGNED - R. GODULIAS  
DRAWN - S. SHARMA  
CHECKED - M. INTATANO  
DATE - MAY 8, 2009

REVISED -  
REVISED -  
REVISED -  
REVISED -

**STATE OF ILLINOIS**  
**DEPARTMENT OF TRANSPORTATION**

**LIGHTING AND RECEPTACLE PLAN**  
**WEST SIDE DOCK LEVEL**

SCALE: AS SHOWN SHEET NO. E-35 OF E-125 SHEETS STA. 379+06.09 TO STA. 382+45.28

F.A.P. RTE.	SECTION	COUNTY	TOTAL SHEETS	SHEET NO.
389	2424-2B-R	COOK	398	306
CONTRACT NO. 60D61				
FED. ROAD DIST. NO. 1 ILLINOIS FED. AID PROJECT				