


**NOTES:**

1. FOR ELECTRICAL SYMBOLS SEE DWGS. E-04 AND E-05.
2. FOR ABBREVIATIONS SEE DWG. E-06.
3. FOR GENERAL NOTES SEE DWGS E-02 & E-03.
4. FOR PANEL SCHEDULES SEE DWG E-64.
5. FOR LIGHT FIXTURES DESCRIPTIONS SEE ELECTRICAL SPECIFICATIONS.

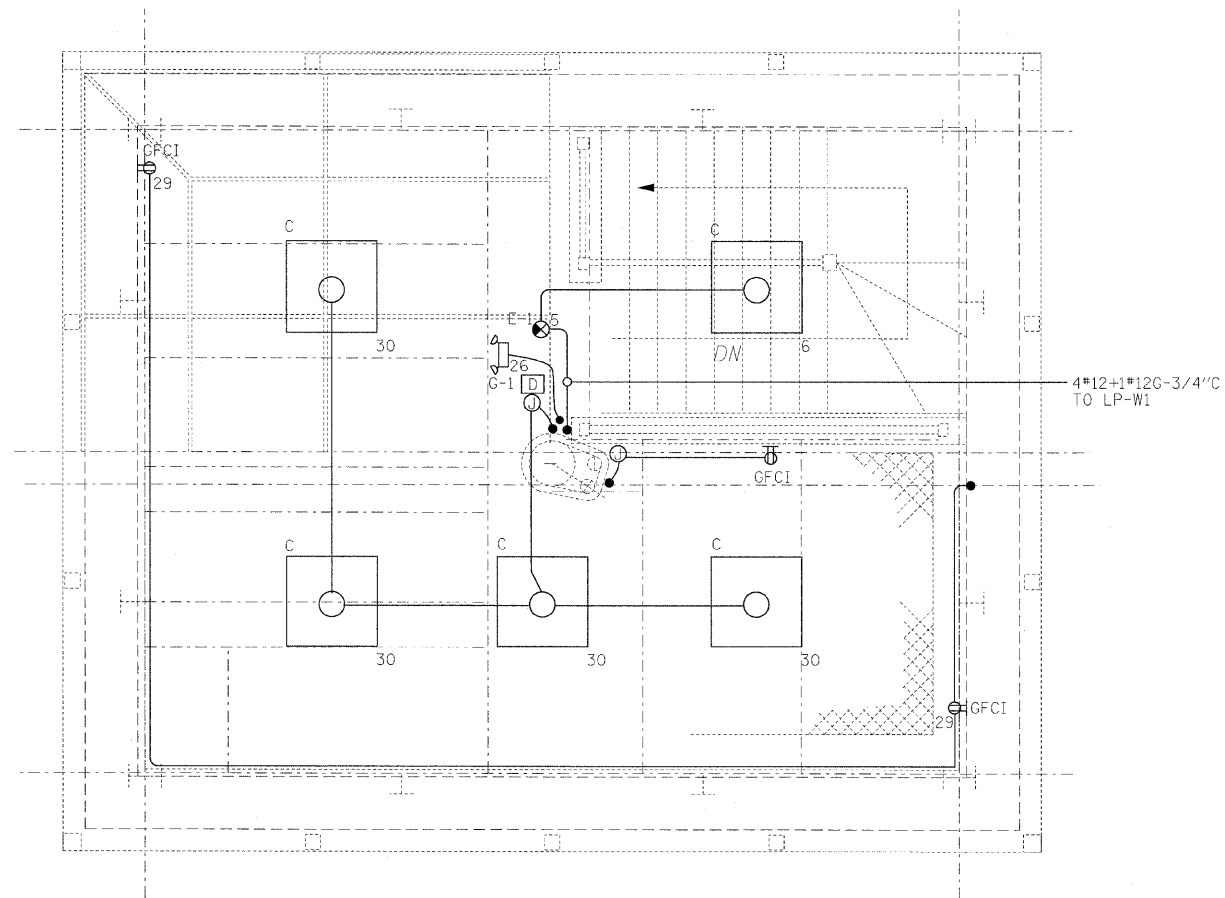

**LIGHTING AND RECEPTACLE PLAN**  
1/2"=1'-0"

**PB Americas, Inc.**  
230 WEST MONROE STREET,  
SUITE 900  
CHICAGO, IL. 60606

USER NAME = sharma  
FILE NAME = 0160c61-shr-e1o-38.dgn  
PLOT SCALE = NONE  
PLOT DATE = 5/7/2009

DESIGNED - R. GODULIAS  
DRAWN - S. SHARMA  
CHECKED - M. INTATANO  
DATE - MAY 8, 2009

REVISED -  
REVISED -  
REVISED -  
REVISED -

**STATE OF ILLINOIS  
DEPARTMENT OF TRANSPORTATION**

**LIGHTING AND RECEPTACLE PLAN  
WEST SIDE OPERATOR'S ROOM**

SCALE: AS SHOWN | SHEET NO. E-38 OF E-125 SHEETS | STA. 379+06.09 TO STA. 382+45.28

F.A.P. RTE.	SECTION	COUNTY	TOTAL SHEETS	SHEET NO.
389	2424-2B-R	COOK	398	309
CONTRACT NO. 60D61				
FED. ROAD DIST. NO. 1   ILLINOIS FED. AID PROJECT				